


TATUM BOULEVARD

SHEA BOULEVARD

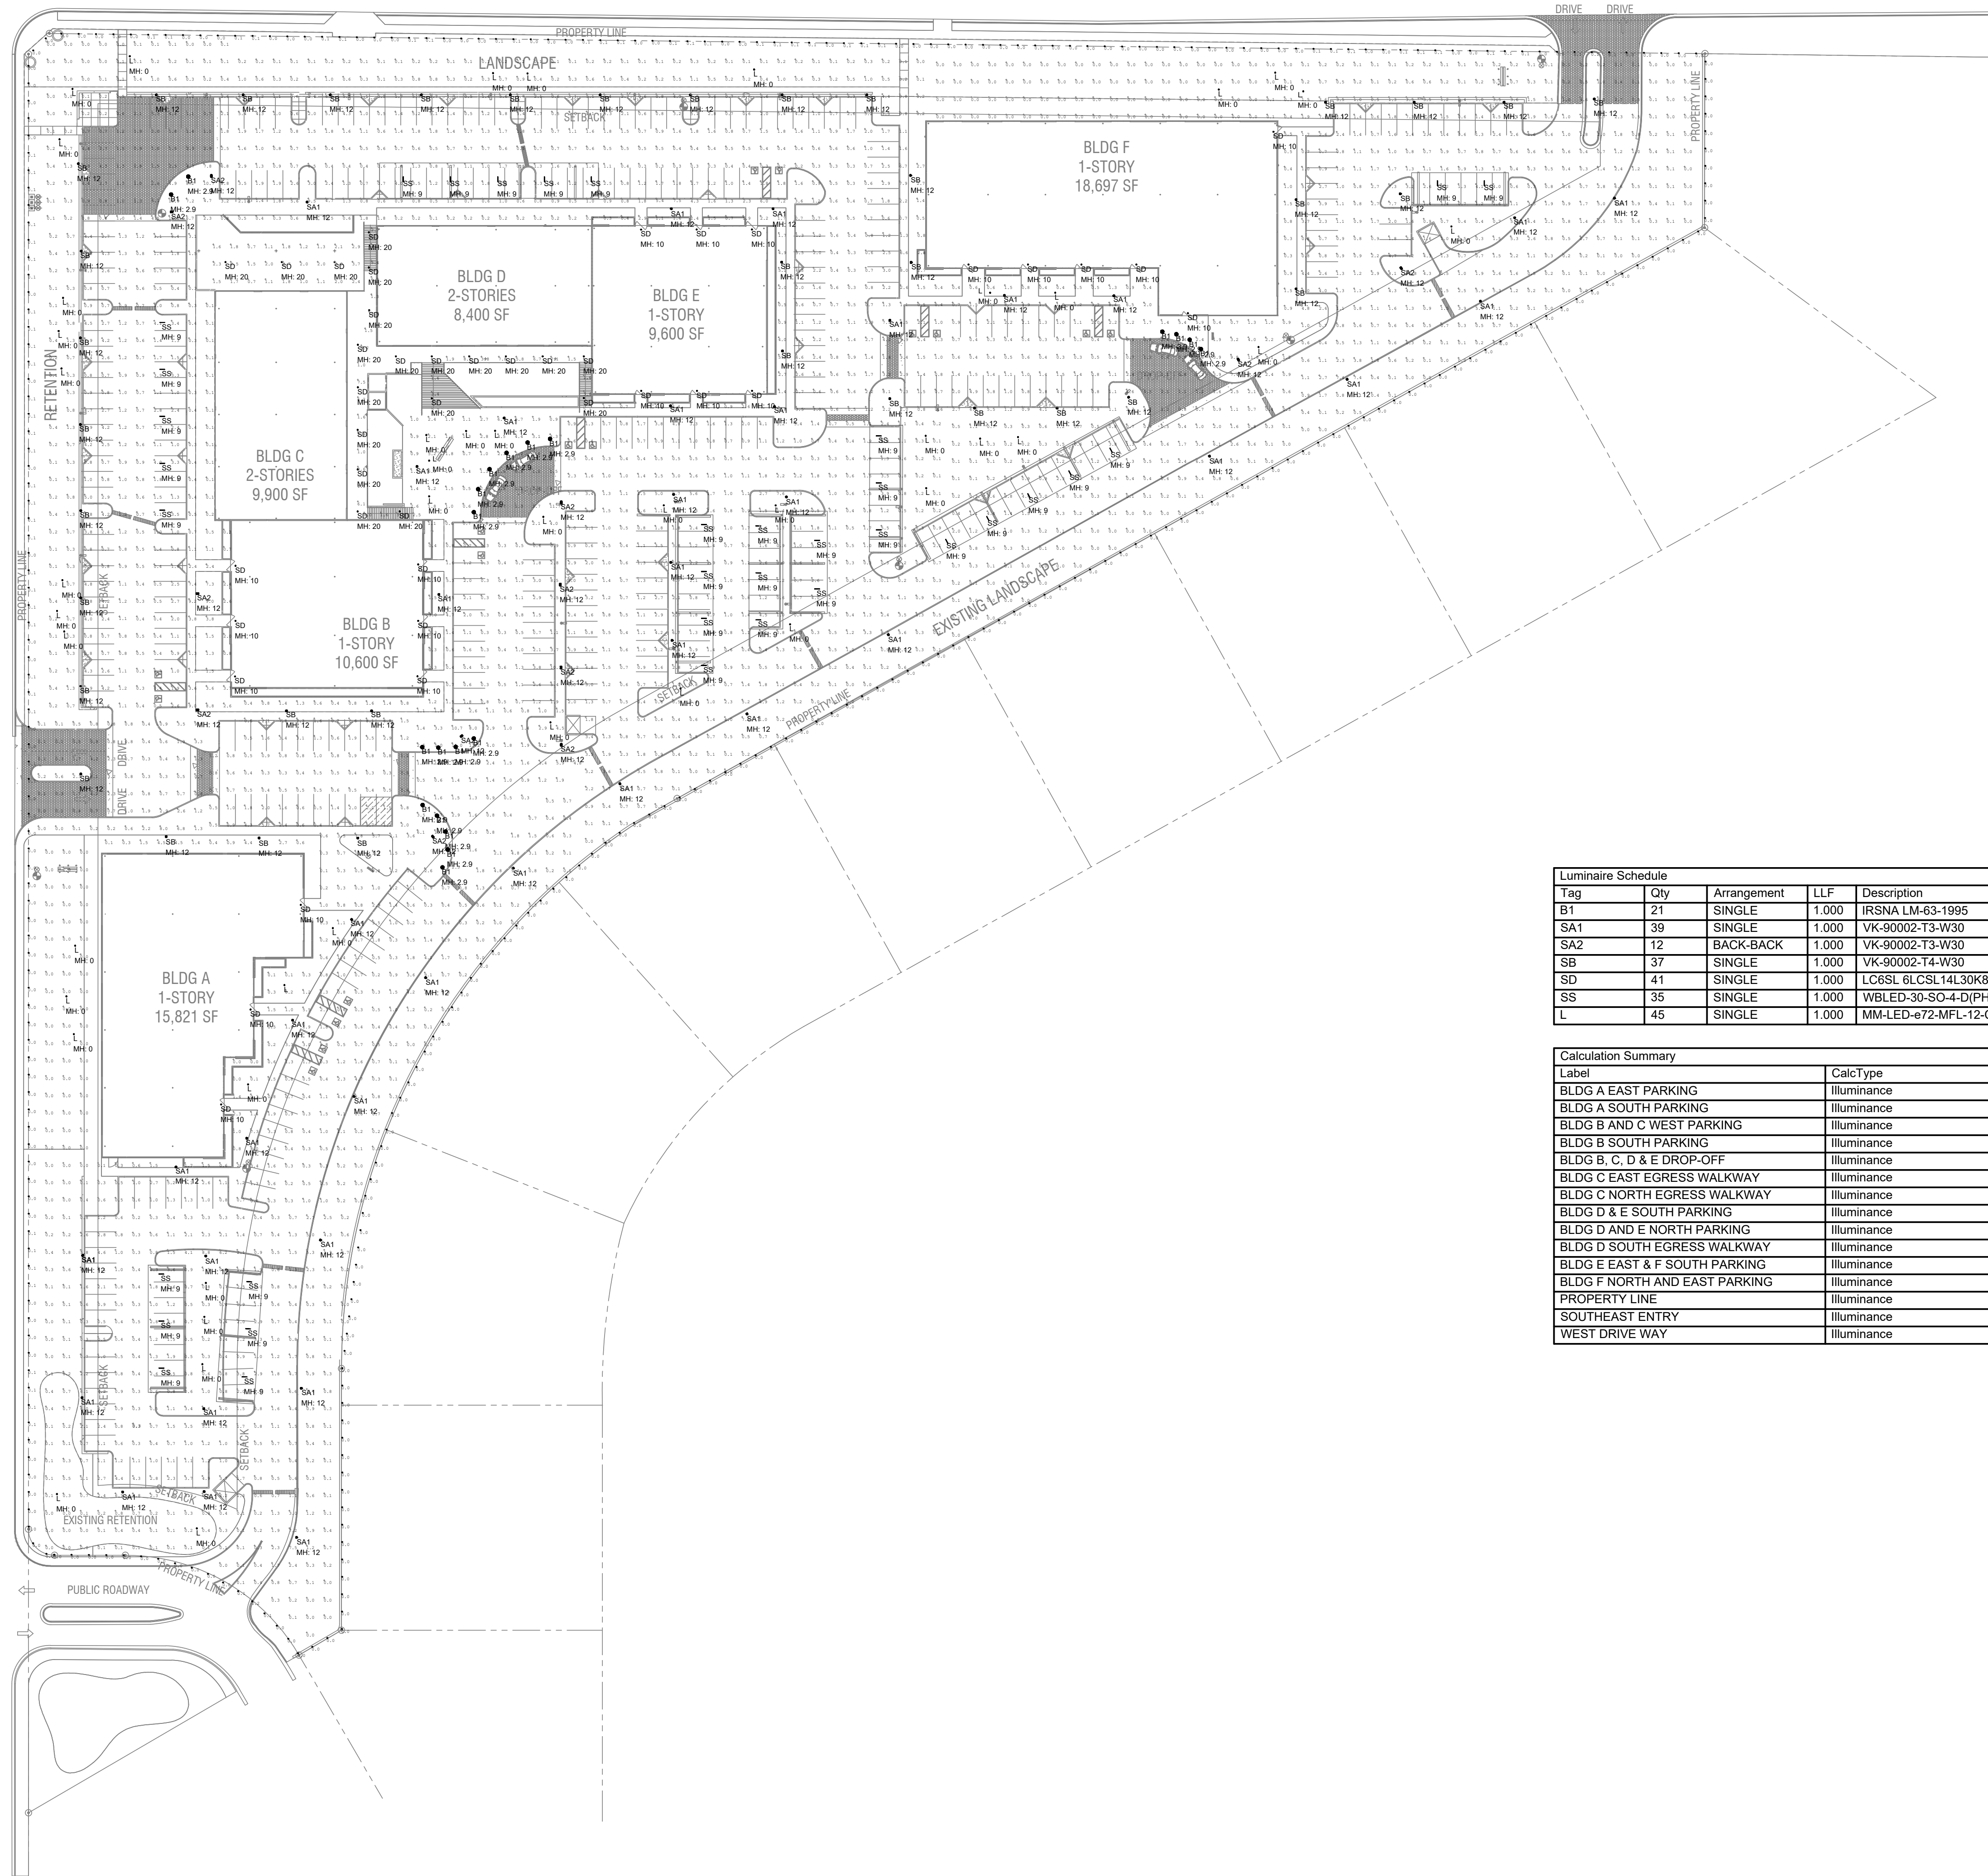

NOTE:
IF POLES LIGHT FIXTURE HEIGHTS LESS THAN 12' ARE USED WE
CREATE HOT SPOTS THAT EXCEED THE PARADISE VALLEY
MAXIMUM OF 1.6 AVERAGE FOOT CANDLE REQUIREMENT FOR
PARKING LOTS. (REFER TO SECTION 2 OF THE PARADISE
VALLEY ZONING ORDINANCE, SPECIAL USE PERMIT
GUIDELINES).
THE ILLUMINATION ENGINEERING SOCIETY (IES) OF AMERICA
HAS A 0.3 FOOT CANDLE MINIMUM LEVEL FOR SECURITY AND 0.5
FOOT CANDLES MINIMUM FOR ADVANCED LEVELS OF SECURITY.
(REFER TO APPLICATIONS SECTION 26 OF THE IES LIGHTING
HANDBOOK). THE CURRENT DESIGN FOR THIS PROJECT IS TO
HAVE 0.3 FOOT CANDLE MINIMUM STANDARD.

Luminaire Schedule						
Tag	Qty	Arrangement	LLF	Description	Mounting Height Above Finished Grade	Lum. Lumens Color Temp.
B1	21	SINGLE	1.000	IRSNA LM-63-1995	2'-11"	728 3000 k
SA1	39	SINGLE	1.000	VK-90002-T3-W30	12'	4150 3000 k
SA2	12	BACK-BACK	1.000	VK-90002-T3-W30	12'	4150 3000 k
SB	37	SINGLE	1.000	VK-90002-T4-W30	12'	4221 3000 k
SD	41	SINGLE	1.000	LC6SL 6LCSL14L30K8	SEE PLANS	1490 3000 k
SS	35	SINGLE	1.000	WBLED-30-SO-4-D(PHIL54)	9'	1984 3000 k
L	45	SINGLE	1.000	MM-LED-672-MFL-12-C	0' - GROUND MOUNTED	176 3000 k

Calculation Summary					
Label	CalcType	Units	Avg	Max	Min
BLDG A EAST PARKING	Illuminance	Fc	1.27	9.4	0.0
BLDG A SOUTH PARKING	Illuminance	Fc	1.07	8.8	0.0
BLDG B AND C WEST PARKING	Illuminance	Fc	1.59	9.2	0.1
BLDG B SOUTH PARKING	Illuminance	Fc	1.58	8.1	0.1
BLDG B, C, D & E DROP-OFF	Illuminance	Fc	2.20	11.7	0.4
BLDG C EAST EGRESS WALKWAY	Illuminance	Fc	4.80	10.3	1.0
BLDG C NORTH EGRESS WALKWAY	Illuminance	Fc	1.83	3.7	0.7
BLDG D & E SOUTH PARKING	Illuminance	Fc	1.59	11.2	0.0
BLDG D AND E NORTH PARKING	Illuminance	Fc	1.57	12.9	0.0
BLDG D SOUTH EGRESS WALKWAY	Illuminance	Fc	4.84	9.8	1.5
BLDG E EAST & F SOUTH PARKING	Illuminance	Fc	1.58	11.8	0.0
BLDG F NORTH AND EAST PARKING	Illuminance	Fc	1.21	10.8	0.0
PROPERTY LINE	Illuminance	Fc	0.02	0.2	0.0
SOUTHEAST ENTRY	Illuminance	Fc	2.97	13.2	0.3
WEST DRIVE WAY	Illuminance	Fc	1.43	9.9	0.0

mountain view medical center, LLC
**Mountain View Medical
Center Redevelopment**
10555,10565,10575,10585,10595,10599 N. Tatum Blvd ,
Paradise Valley, Arizona 85253

CLIENT CONTACT
mountain view medical center, LLC
1444 N. 14th St
Phoenix, AZ 85018
602.802.8106 t
602.802.8106 f

PROJECT NO.
2018_041
DATE OF ISSUE
04.16.2019

REVISION NO.
1
2
3
4
5
6
DATE
09.26.2018
11.01.2018
01.22.2019
02.19.2019
03.19.2019
04.08.2019

PROJECT TEAM
John Cantrell
DRAWN BY
BD

PROJECT PHASE
SUP major amendment
Review #4

SHEET CONTENTS

photometric site plan
option #1

SHEET NO.

E-1.1

2929 n central ave
eleventh floor
phoenix arizona 85012

602.257.1764 t
602.257.9029 f
www.owp.com




© 2017 The Board of Architects in the State of Arizona and the Board of Professional Engineers in the State of Arizona. The Board of Architects in the State of Arizona and the Board of Professional Engineers in the State of Arizona are the only entities authorized to practice architecture and engineering in the State of Arizona. The Board of Architects in the State of Arizona and the Board of Professional Engineers in the State of Arizona are the only entities authorized to practice architecture and engineering in the State of Arizona. The Board of Architects in the State of Arizona and the Board of Professional Engineers in the State of Arizona are the only entities authorized to practice architecture and engineering in the State of Arizona.

**HENDERSON
ENGINEERS**
5343 N. 16TH STREET, SUITE 460
PHOENIX, AZ 85016
TEL 602.336.5200 FAX 602.336.5201
WWW.HENDERSONENGINEERS.COM
1850003561
AZ CORPORATE NUMBER: 10470-0
EXPIRES 06/30/19

TATUM BOULEVARD

SHEA BOULEVARD

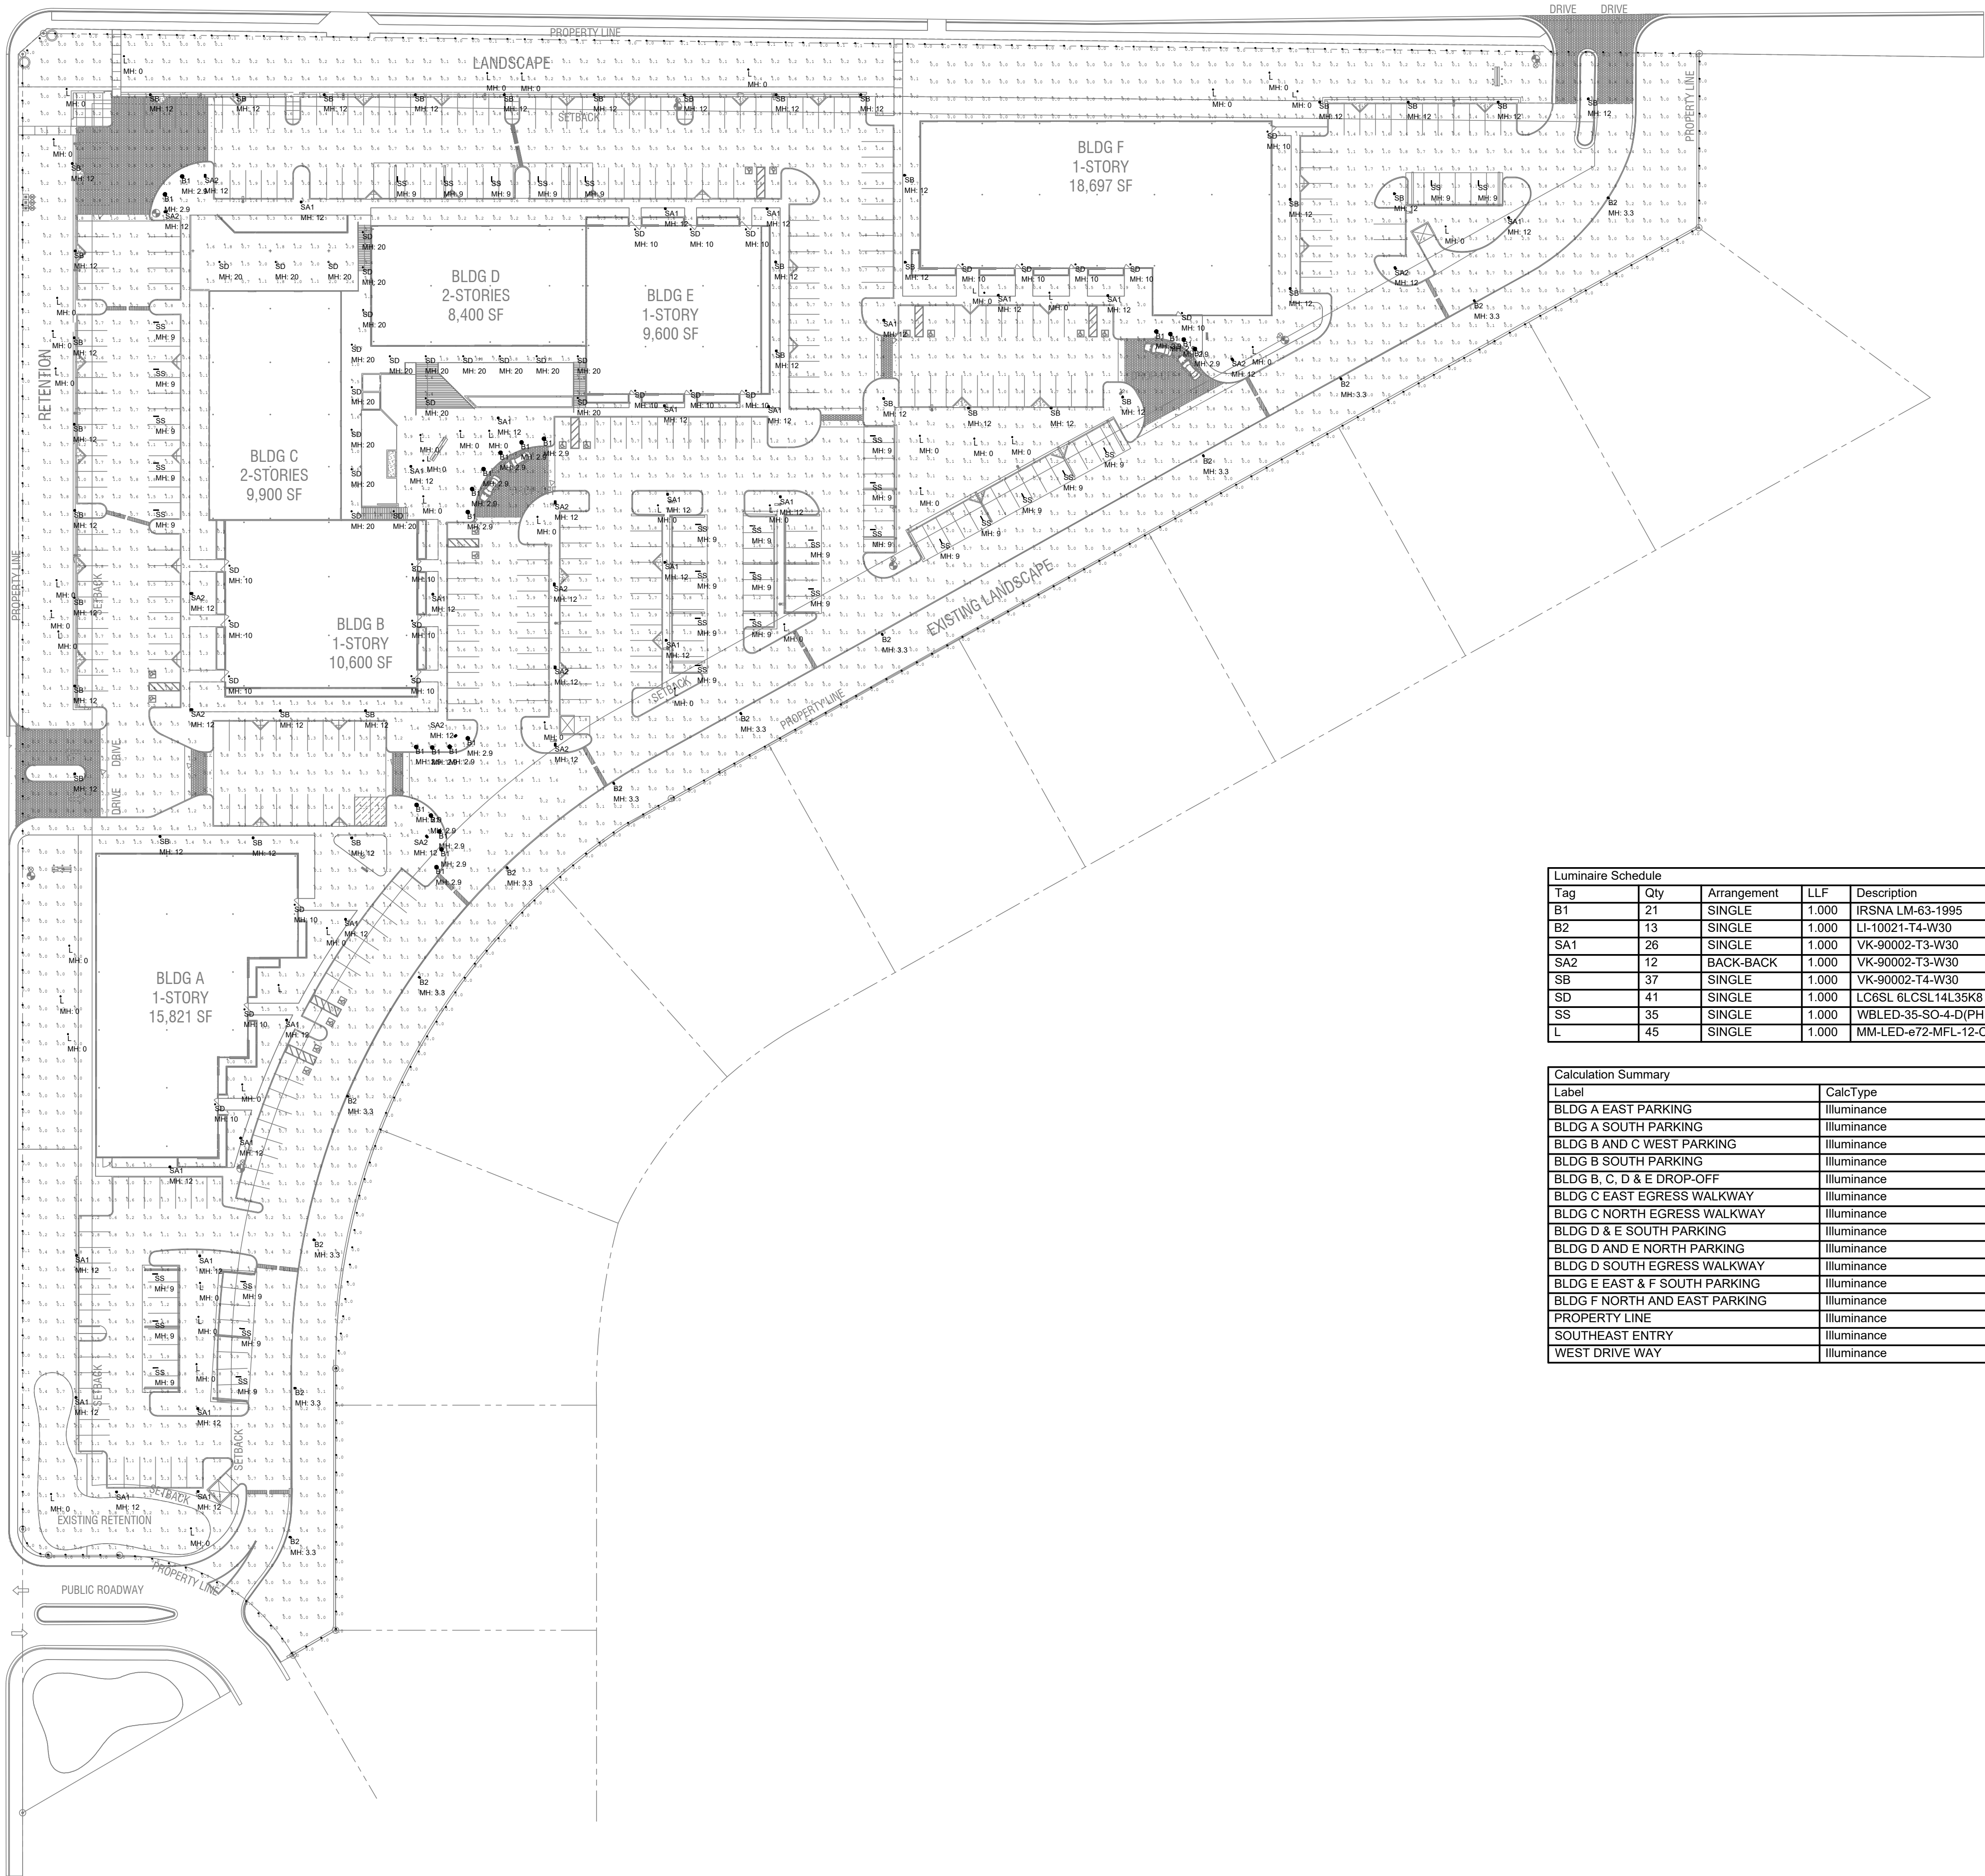

NOTE:
IF POLES LIGHT FIXTURE HEIGHTS LESS THAN 12' ARE USED WE
CREATE HOT SPOTS THAT EXCEED THE PARADISE VALLEY
MAXIMUM OF 1.6 AVERAGE FOOT CANDLE REQUIREMENT FOR
PARKING LOTS. (REFER TO SECTION 2 OF THE PARADISE
VALLEY ZONING ORDINANCE, SPECIAL USE PERMIT
GUIDELINES).
THE ILLUMINATION ENGINEERING SOCIETY (IES) OF AMERICA
HAS A 0.3 FOOT CANDLE MINIMUM LEVEL FOR SECURITY AND 0.5
FOOT CANDLES MINIMUM FOR ADVANCED LEVELS OF SECURITY.
(REFER TO APPLICATIONS SECTION 26 OF THE IES LIGHTING
HANDBOOK). THE CURRENT DESIGN FOR THIS PROJECT IS TO
HAVE 0.3 FOOT CANDLE MINIMUM STANDARD.

Luminaire Schedule						
Tag	Qty	Arrangement	LLF	Description	Mounting Height Above Finished Grade	Lum. Lumens Color Temp.
B1	21	SINGLE	1.000	IRSNA LM-63-1995	2'-11"	728 3000 k
B2	13	SINGLE	1.000	LI-10021-T4-W30	3'-4"	2232 3000 k
SA1	26	SINGLE	1.000	VK-90002-T3-W30	12'	4150 3000 k
SA2	12	BACK-BACK	1.000	VK-90002-T3-W30	12'	4150 3000 k
SB	37	SINGLE	1.000	VK-90002-T4-W30	12'	4221 3000 k
SD	41	SINGLE	1.000	LC6SL 6LCSL14L35K8	SEE PLANS	1490 3000 k
SS	35	SINGLE	1.000	WBLED-35-SO-4-D(PHIL54)	9'	1984 3000 k
L	45	SINGLE	1.000	MM-LED-672-MFL-12-C	0' - GROUND MOUNTED	176 3000 k

Calculation Summary					
Label	CalcType	Units	Avg	Max	Min
BLDG A EAST PARKING	illuminance	Fc	1.27	47.6	0.0
BLDG A SOUTH PARKING	illuminance	Fc	0.91	9.4	0.0
BLDG B AND C WEST PARKING	illuminance	Fc	1.59	9.2	0.1
BLDG B SOUTH PARKING	illuminance	Fc	1.57	8.1	0.1
BLDG B, C, D & E DROP-OFF	illuminance	Fc	2.20	11.7	0.4
BLDG C EAST EGRESS WALKWAY	illuminance	Fc	4.80	10.3	1.0
BLDG C NORTH EGRESS WALKWAY	illuminance	Fc	1.83	3.7	0.7
BLDG D & E SOUTH PARKING	illuminance	Fc	1.47	16.9	0.0
BLDG D AND E NORTH PARKING	illuminance	Fc	1.57	12.9	0.0
BLDG D SOUTH EGRESS WALKWAY	illuminance	Fc	4.84	9.8	1.5
BLDG E EAST & F SOUTH PARKING	illuminance	Fc	1.51	11.8	0.0
BLDG F NORTH AND EAST PARKING	illuminance	Fc	1.06	10.8	0.0
PROPERTY LINE	illuminance	Fc	0.02	0.1	0.0
SOUTHEAST ENTRY	illuminance	Fc	2.94	13.2	0.2
WEST DRIVE WAY	illuminance	Fc	1.43	9.9	0.0

mountain view medical center, LLC
**Mountain View Medical
Center Redevelopment**
10555,10565,10575,10585,10595,10599 N. Tatum Blvd ,
Paradise Valley, Arizona 85253

CLIENT CONTACT
mountain view medical center, LLC
3345 N. 14th St.
Phoenix, AZ 85018
602.802.8106 t

PROJECT NO.
2018_041
DATE OF ISSUE
04.16.2019

REVISION NO.
1
2
3
4
5
6
DATE
09.26.2018
11.01.2018
01.22.2019
02.19.2019
03.19.2019
04.08.2019

PROJECT TEAM
John Cantrell
DRAWN BY
BD

PROJECT PHASE
SUP major amendment
Review #4

SHEET CONTENTS

photometric site plan
option #2

SHEET NO.

E-1.2

2929 n central ave
eleventh floor
phoenix arizona 85012
602.257.1764 t
602.257.9029 f
www.owp.com



**HENDERSON
ENGINEERS**
5345 N. 16TH STREET, SUITE 460
PHOENIX, AZ 85016
TEL 602.336.5200 FAX 602.336.5201
WWW.HENDERSONENGINEERS.COM
1850003561
AZ CORPORATE NUMBER: 10470-0
EXPIRES 06/30/19

LED bollards with unshielded light

Post construction: Constructed of copper-free extruded and die-cast aluminum. Die-castings are marine grade, copper free (a 0.3% copper content) A500.0 aluminum alloy.

Lamp enclosure: Die-cast aluminum post cap with three-ply opal glass diffuser with screw neck. Fully gasketed for weather tight operation using high temperature silicone gasket.

Electrical: 0.2W LED luminaire, 12.5 total system watts, -30°C start temperature. Integral 120V through 277V electronic LED driver, 0-10V dimming (LED module) are available from factory for easy replacement. Standard LED color temperature is 3000K with a >60 CRI. Available in 4000K (>90 CRI), add suffix K4 to order.

Note: LEDs supplied with luminaire. Due to the dynamic nature of LED technology, LED luminaire data on this sheet is subject to change at the discretion of BEGA-US. For the most current technical data, please refer to www.bega-us.com.

Anchor base: Heavy cast aluminum, slotted for precise alignment. Mounts to BEGA 79 B24 anchorage kit. Bollard secures to base with one stainless steel set screw. The mounting system allows the luminaire to be adjusted independent of anchor bolt orientation.

Finishes: All BEGA standard finishes are polyester powder coat with minimum 3 mil thickness. Available in four standard BEGA colors: Black (BLK), White (WHT), Bronze (BRZ), Silver (SLV). To specify, add appropriate suffix to catalog number. Custom colors supplied on special order.

CSA certified to U.S. and Canadian standards, suitable for wet locations. Protection class IP65

Weight: 11.5 lbs.

Luminaire lumens: 728

Lamp: A = B = 0.2W LED 5% 30% 79117

77743 0.2W LED 5% 30% 79117

BEGA-US 1000 BEGA Way, Carpinteria, CA 93013 (805)684-0533 FAX (805)566-9474 www.bega-us.com
©Copyright BEGA-US 2016 Updated 1/18

1

NTS

Type:
Project:
Color:
Options:
Modified:

77743 0.2W LED 5% 30% 79117

2 LUMINAIRE TYPE "B1" NTS

ULI-10021
Light Linear PT 1 Single Head Bollard

Construction

Aluminum
Less Than 0.1% copper content - Marine Grade 6060 extruded & LM6 Aluminum High Pressure die casting provides excellent mechanical strength, clean detailed product lines and excellent heat dissipation.

Pre-paint
8 step degrease and phosphate process that includes degreasing and etching as well as a zinc and nickel phosphate process before product painting.

Memory Retention - Silicon Gasket
Provided with special injection molded "fit for purpose" long life high temperature memory retentive silicon gaskets. Maintains the gaskets exact profile and seal over years of use and compression.

Thermal management
LM6 Aluminum is used for its excellent mechanical strength and thermal dissipation properties in low and high ambient temperatures. The superior thermal heat sink design by Ligman used in conjunction with the driver, controls thermal build up critical temperature range to ensure maximum luminous flux output, as well as providing long LED service life and ensuring less than 10% lumen depreciation at 50,000 hours.

Surge Suppression
Standard 10w surge suppressor provided with all fixtures.

BUG Rating
B1 - LED C1

Finishing
All Ligman products go through an extensive finishing process that includes tefletting to improve paint adherence.

Paint
UV Stabilized 4.5MI thick powder coat paint and baked at 200 Deg C. This process ensures that Ligman products can withstand harsh environments. Rated for use in natoriums.

Hardware
Provided Hardware is Marine grade 316 Stainless steel.

Anti Seize Screw Holes
Tapped holes are infused with a special anti seize compound designed to prevent seizure of threaded connections, due to electrolysis from heat, corrosive atmospheres and moisture.

Crystal Clear Low Iron Glass Lens
Provided with tempered, impact resistant crystal clear low iron glass ensuring no green glass tinge.

Optics & LED
Precision optic design provides exceptional light control and precise distribution of light. LED CRI > 80.

Lumen - Maintenance Life
L80 B10 at 50,000 hours (This means that at least 80% of the LED still achieve 80% of their original flux)

microVos TECHNOLOGY

Ligman's micro Variable Optical System provides the ability to interchange, mix & rotate optics to provide specific light distributions for optimized spacing and uniformity.

The variable optic system allows for the designer to create hybrid distributions for precise lighting requirements.

HYBRID TYPE I & TYPE IV

Ligman LIGHTING USA

Area distribution bollard-integrated projectors. Stylish but technically precise area lighting solutions as part of a large flexible family.

Light Linear PT1 Bollard is an elegant minimalist bollard that is suitable for both modern and classic architecture. Ideal for creating visual guidance with exceptional visual comfort. The dual waisted optical chamber with integrated heat sinks houses a range of field interchangeable optically controlled LEDs, providing Type II, III, IV & V distribution, as well as variations of this for precise light distribution requirements.

An example of this, is using a combination of Type II and Type IV distribution optics inside the same fixture.

This product range is available in 29w and 55w options, as single & double head styles.

Customer specific wattages can be provided, contact the factory for more information.

This luminaire complies to Dark Sky requirements. Bollards can be provided with GFC boxes positioned to specific heights specified by the customer.

Internal house size shields are available as an option.

Optional Security Bollard:
The Light Linear Bollard is available as a traffic rated security bollard.

This security bollard provides restraint of vehicular traffic in unauthorized areas.

Impact calculations show this bollard will stop a 5,500lb/75 tons vehicle, travelling at 30mph.

For additional strength, the galvanized pole can be filled with concrete up to the weather proof driver housing to provide a solid concrete barrier.

Additional Options (Consult Factory For Pricing)

SB Security Bollard

RCBW or Static Color Laser Cut Lettering, Logos & Designs (LVT Bollard shown for visual reference)

Ligman can provide custom logos and signage in the Light Linear Bollard. The images above show this feature in the Light Linear VT Bollard.

3 LUMINAIRE TYPE "B2" NTS

ULI-10021
Light Linear PT 1 Single Head Bollard

Beam Options

Type II Distribution Type III Distribution Type IV Distribution

PROJECT DATE

QUANTITY TYPE NOTE

ORDERING EXAMPLE || ULI - 10021 - 29w - T2 - W30 - 02 - 120/27v - Options

LAMP	BEAM	LED COLOR	FINISH COLOR	VOLTAGE
29W LED	T2 - Type II Distribution - 2628lm T3 - Type III Distribution - 2650lm T4 - Type IV Distribution - 2650lm	W37 - 2700K W38 - 3000K W40 - 4000K	01 - BLACK RAL 9011 02 - DARK GREY RAL 7043 03 - WHITE RAL 9003 04 - METALLIC SILVER RAL 9006 05 - MATTE SILVER RAL 9006 06 - LIGMAN BRONZE 07 - CUSTOM RAL	00 - 120V 01 - 277V 02 - 347V 03 - 480V 04 - 575V 05 - 600V 06 - 720V 07 - 800V 08 - 900V 09 - 1000V 10 - 1200V 11 - 1380V 12 - 1500V 13 - 1650V 14 - 1800V 15 - 2000V 16 - 2200V 17 - 150800V 760 - 151000V 7