


The Scherr Residence

5416 E. Desert Jewel Drive, Paradise Valley, Arizona

A-0	COVER SHEET	C-2	GRADING & DRAINAGE IMPROVEMENT PLAN	L-2	LANDSCAPE LIGHTING PLAN	A-3.0	EXTERIOR BUILDING LIGHTING PLAN	A-5.0	BUILDING SECTIONS	A-7.0	EXTERIOR MATERIALS
S-1	BOUNDARY & TOPOGRAPHIC SURVEY	C-3	GRADING & DRAINAGE DETAILS	A-1.0	SITE PLAN	A-4.0	EXTERIOR ELEVATIONS	A-5.1	BUILDING SECTIONS		
C-1	COVER SHEET - GRADING & DRAINAGE PLAN	L-1	LANDSCAPE PLAN	A-2.0	RENDERING & SITE PHOTOS	A-4.1	EXTERIOR ELEVATIONS	A-6.0	MASSING MODEL		

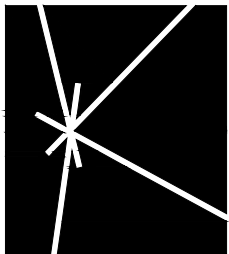

KENDLE DESIGN
COLLABORATIVE
6115 NORTH CATTLETRACK
SCOTTSDALE, ARIZONA 85250
PH 480.951.8558
BRENT@KENDLEDESIGN.COM
KENDLEDESIGN.COM

Scherr Residence

5416 E. Desert Jewel Drive,
Paradise Valley, AZ
85253

All drawings and written material appearing herein constitute the original and unpublished work of Kendle Design Collaborative. Any duplication or reproduction of these documents or any portion herein without the expressed written permission from Kendle Design Collaborative is prohibited by law.

5		
4		
3		
2		
1		
MARK	DATE	DESCRIPTION

ISSUE: 12/5/17 - FORMAL REVIEW

PROJECT NO:

CAD DWG FILE:

DRAWN BY: CK, RVH


CHECKED BY: BK

SHEET TITLE:

COVER

A-0

BOUNDARY & TOPOGRAPHIC SURVEY
5416 E DESERT JEWEL DR., PARADISE VALLEY, AZ 85253
LOT 27 - VISTA RICA
A SUBDIVISION PLAT RECORDED IN BOOK 171 OF MAPS, PAGE 28, MCR.,
LOCATED IN A PORTION OF THE SE 1/4 OF THE SW 1/4 OF THE SE 1/4 OF SECTION 32, T.3N, R.4E
OF THE GILA & SALT RIVER BASE AND MERIDIAN, MARICOPA COUNTY, ARIZONA

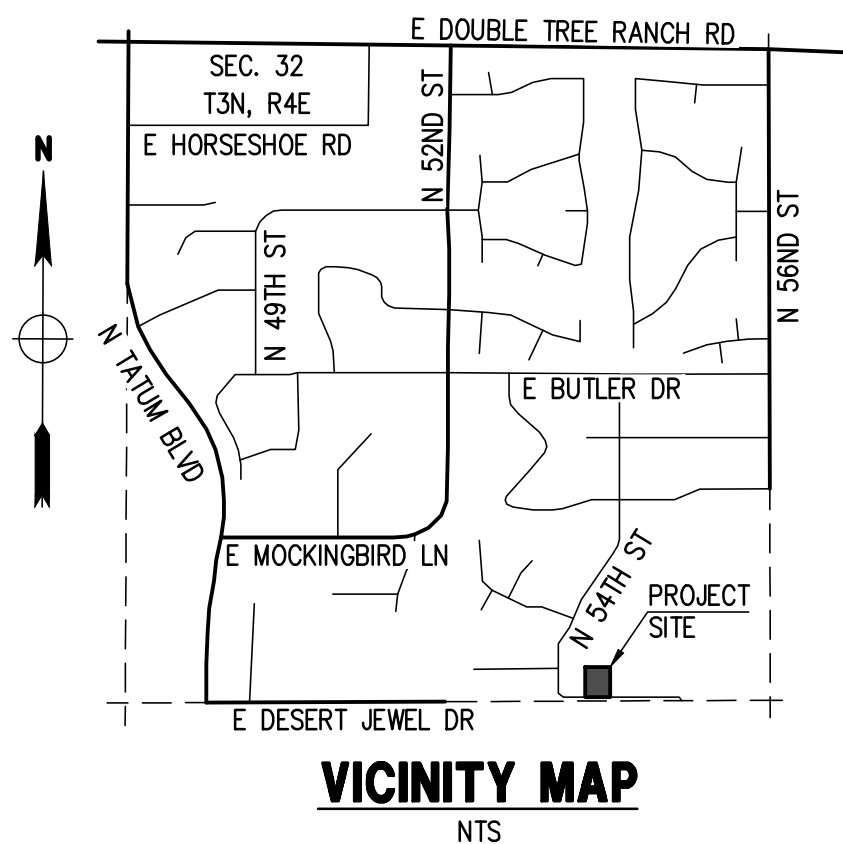

OWNER

JASON SCHERR
6843 LOST GARDEN TER
PARKLAND, FL 33076

SITE DATA

APN: 168-75-029
ADDRESS: 5416 E DESERT JEWEL DR
PARADISE VALLEY, AZ 85253
ZONING: R-43
LOT AREA: 43,655 S.F. (1.002 AC.)

LEGAL DESCRIPTION

LOT 27, OF VISTA RICA, ACCORDING TO THE PLAT OF RECORD IN THE OFFICE OF THE COUNTY RECORDER OF MARICOPA COUNTY, ARIZONA, RECORDED IN BOOK 171 OF MAPS, PAGE 28.

CONTAINING 43,655 S.F. (1.002 AC.); MORE OR LESS.

BASIS OF BEARINGS

THE SOUTH LINE OF LOTS 26, 27 AND 28 BASED ON THE FOUND MONUMENTATION SHOWN ON THE SURVEY. THE BEARING OF WHICH IS N89°49'14"E, PER PLAT OF VISTA RICA, BOOK 171, PAGE 28, MCR.

BENCHMARK

BRASS CAP FLUSH AT THE INTERSECTION OF MOCKINGBIRD LANE AND 56TH STREET HAVING AN ELEVATION OF 1349.97 TOWN OF PARADISE VALLEY (NAVD 88) DATUM, GDACS# 26101-1

SURVEY REFERENCES

- EASEMENTS, RESTRICTIONS, RESERVATIONS, CONDITIONS AND SETBACK LINES AS SET FORTH ON THE PLAT RECORDED IN BOOK 171 OF MAPS, PAGE 28, MCR.
- WARRANTY DEED RECORDED IN DOC. NO. 2017-0040925, M.C.R.


FLOOD INSURANCE RATE MAP (FIRM) DATA

COMMUNITY #	PANEL #	SUFFIX	BASED FLOOD ELEVATION
040049	1765 OF 4425	L	N/A
MAP #	PANEL DATE	ZONE	
04013C	10/16/2013	X*	

*AREAS DETERMINED TO BE OUTSIDE THE 0.2% ANNUAL CHANCE FLOODPLAIN

CERTIFICATE OF SURVEY

THIS IS TO CERTIFY THAT THIS MAP AND THE SURVEY ON WHICH IT IS BASED WERE MADE IN ACCORDANCE WITH THE CURRENT "MINIMUM STANDARDS FOR ARIZONA BOUNDARY AND TOPOGRAPHIC SURVEYS", AND THAT THE SURVEY IS SHOWN HEREON IS TRUE AND CORRECT TO THE BEST OF MY KNOWLEDGE AND BELIEF AND WAS SURVEYED AND DRAWN UNDER MY DIRECTION IN THE MONTH OF MARCH, 2017.

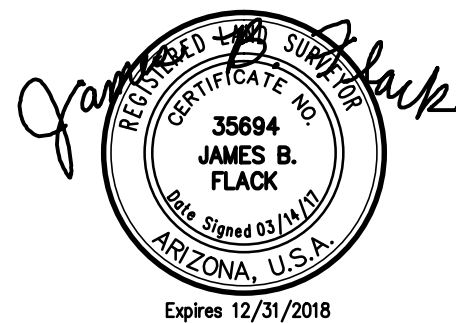

Expires 12/31/2018
JAMES FLACK, RLS



03/14/17
DATE

GENERAL NOTES


- THE PREMISES SURVEYED HAVE NO KNOWN DISCREPANCIES, BOUNDARY LINE CONFLICTS, ENCROACHMENTS, OVERLAPPING OF IMPROVEMENTS, EASEMENTS OR RIGHT-OF-WAYS EXCEPT AS SHOWN, AND HAS ACCESS TO OR FROM A DEDICATED ROADWAY.
- THIS IS AN ABOVE GROUND SURVEY. THE UNDERGROUND UTILITIES AS SHOWN ARE BASED ON INFORMATION PROVIDED BY THE VARIOUS UTILITY COMPANIES AND THESE LOCATIONS SHOULD BE CONSIDERED APPROXIMATE. THERE MAY BE ADDITIONAL UNDERGROUND UTILITIES, NOT SHOWN ON THIS DRAWING. THE SURVEYOR MAKES NO GUARANTEES THAT THE UNDERGROUND UTILITIES SHOWN COMPRISE ALL SUCH UTILITIES IN THE AREA, EITHER IN SERVICE OR ABANDONED. THE SURVEYOR FURTHER DOES NOT WARRANT THAT THE UNDERGROUND UTILITIES SHOWN HEREON ARE IN THE EXACT LOCATION INDICATED ALTHOUGH HE DOES CERTIFY THAT THEY ARE LOCATED AS ACCURATELY AS POSSIBLE FROM THE INFORMATION AVAILABLE AT THE TIME OF THE SURVEY.
- BUILDING SETBACK LINES, ZONING, FLOOD AREA ZONES, AND ADDRESSES THAT MAY BE SHOWN ARE SUPPLIED BY THE GOVERNING AGENCY OR TAKEN FROM THE BEST AVAILABLE RECORDS. THE SURVEYOR WILL NOT ACCEPT RESPONSIBILITY FOR THE ACCURACY OF ANY INFORMATION SUPPLIED BY OTHERS.
- EXCEPT AS SPECIFICALLY STATED OR SHOWN ON THIS MAP, THIS SURVEY DOES NOT PURPORT TO REFLECT ANY OF THE FOLLOWING WHICH MAY BE APPLICABLE TO THE SUBJECT REAL ESTATE: EASEMENTS, OTHER THAN POSSIBLE EASEMENTS, WHICH WERE VISIBLE AT THE TIME OF MAKING THIS SURVEY; BUILDING SETBACK LINES; RESTRICTIVE COVENANTS, SUBDIVISION RESTRICTIONS; ZONING OR OTHER LAND USE REGULATIONS, AND ANY OTHER FACTS WHICH AN ACCURATE AND CURRENT TITLE SEARCH MAY DISCLOSE.
- THE DESCRIPTION OF PROPERTY BOUNDARIES AND EASEMENTS SHOWN HEREON, REPRESENT THAT INFORMATION PROVIDED IN BOOK 171 OF MAPS, PAGE 28, AND DEED REC. DOC. 2017-0040925, RECORDS OF MARICOPA COUNTY, ARIZONA.
- EVERY DOCUMENT OF RECORD REVIEWED AND CONSIDERED AS A PART OF THIS SURVEY IS NOTED HEREON. ONLY THE DOCUMENTS NOTED HEREON WERE SUPPLIED OR AVAILABLE TO THE SURVEYOR AT THE TIME OF THE SURVEY. THERE MAY EXIST OTHER DOCUMENTS OF RECORD, WHICH WOULD AFFECT THIS PARCEL.
- ANY INFORMATION SHOWN WHICH MAY VARY FROM THE CONTENTS OF THE REPORT(S) NOTED ABOVE, REPRESENTS INFORMATION AND MEASUREMENTS FOUND DURING THE COURSE OF THE SURVEY.
- ON-SITE PLANT INFORMATION SHOWN HEREON IS FOR REFERENCE ONLY. SURVEYOR ASSUMES NO LIABILITY FOR THE EVALUATION, SALVAGEABILITY, REMOVAL AND/RELOCATION OF ON-SITE PLANT MATERIALS.
- ALL MEASURED BEARINGS AND DISTANCES EQUAL RECORD UNLESS NOTED OTHERWISE.
- THE SURVEY MAP WAS PREPARED WITHOUT THE BENEFIT OF A TITLE REPORT.
- ANY AERIAL MAPS SHOWN ON THIS PLAN ARE FOR REFERENCE ONLY AND DO NOT NECESSARILY DEPICT THE EXACT CURRENT CONDITIONS.

UTILITIES

WATER: CITY OF PHOENIX
SANITARY SEWER: TOWN OF PARADISE VALLEY
ELECTRIC: ARIZONA PUBLIC SERVICE
TELEPHONE: CENTURY LINK, COX COMMUNICATIONS
NATURAL GAS: SOUTHWEST GAS
CABLE TV: CENTURY LINK, COX COMMUNICATIONS

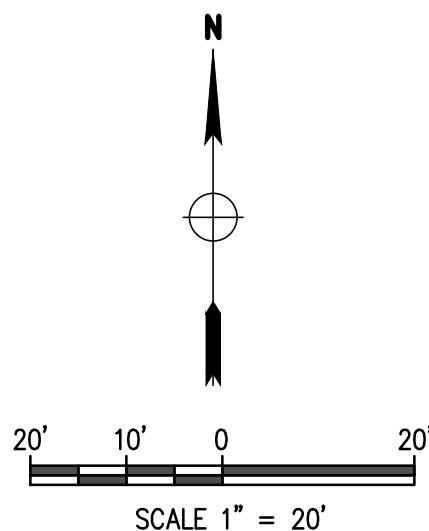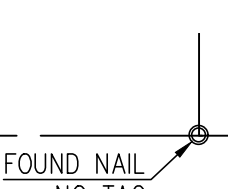

LEGEND

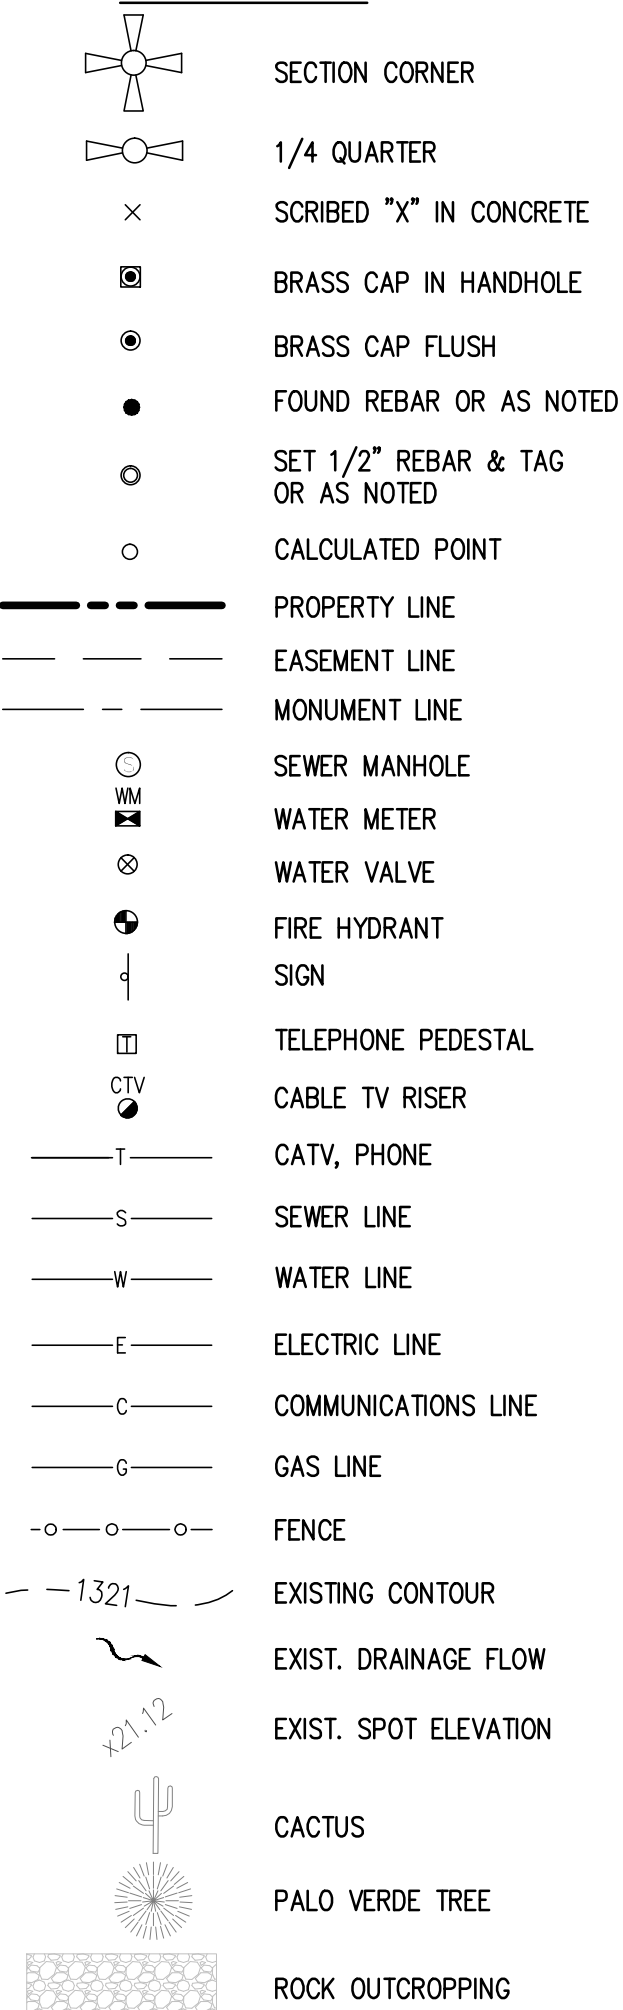

ABBREVIATIONS

BC	BACK OF CURB
BSL	BUILDING SETBACK LINE
C11	CURVE LABEL
CL	CENTERLINE
DE	DRAINAGE EASEMENT
EG	EXISTING GRADE
EL	ELEV
EP	EDGE OF PAVEMENT
ESMT	EASEMENT
EX	EXISTING
FG	FINISH GRADE
F	FLOW LINE
FND	FOUND
G	GUTTER, GAS
INV	INVERT
JBE	JOINT USE & BENEFIT EASEMENT
L11	LINE LABEL
(M)	MEASURED
MCR	MARICOPA COUNTY RECORDER
MH	MANHOLE
P, PWMT	PAVEMENT
PUE	PUBLIC UTILITY EASEMENT
(R), REC.	RECORDED
R	RADIUS
RET	RETAINING
R/W	RIGHT OF WAY
T	TANGENT, TELEPHONE
TC	TOP OF CURB
TG	TOP OF GRATE
TPV	TOWN OF PARADISE VALLEY
TRW	TOP OF RETAINING WALL
W	WEST, WATERLINE
WDO	WALL DRAINAGE OPENING
WM	WATER METER



54TH STREET

DESERT JEWEL DRIVE

54TH STREET

BOUNDARY & TOPOGRAPHIC
SURVEY MAP

LOT 27 - VISTA RICA
5416 E DESERT JEWEL DR
PARADISE VALLEY, AZ 85253

P 602 889 1984 | F 602 445 9482
8808 N CENTRAL AVE., SUITE 288
PHOENIX, AZ 85020
PHOENIX @ LDENG.COM




2. GRADING SHALL BE IN CONFORMANCE WITH 2015 IBC.
3. PRIOR TO FIRST FOOTING INSPECTION OF ANY TYPE, ALL PROPERTY PINS SHALL BE PLACED BY A REGISTERED LAND SURVEYOR OF THE STATE OF ARIZONA, AND PROPERTY LINES MUST BE PHYSICALLY IDENTIFIED PRIOR TO INSPECTION.
3. WHERE EXCAVATION IS TO OCCUR THE TOP 4" OF EXCAVATED NATIVE SOIL SHALL REMAIN ON THE SITE AND SHALL BE REUSED IN A MANNER THAT TAKES ADVANTAGE OF THE NATURAL SOIL SEED BANK IT CONTAINS.
4. ALL CONSTRUCTION SHALL CONFORM TO THE LATEST MARICOPA ASSOCIATION OF GOVERNMENTS (M.A.G.) SPECIFICATIONS AND STANDARD DETAILS.
5. ALL EXTERIOR SITE LIGHTING SHALL COMPLY WITH REQUIREMENTS OF SECTION 2208 OF THE TOWN OF PARADISE VALLEY ZONING ORDINANCES FOR FUTURE TYPE, LOCATION, HEIGHT, WATTAGE BASED UPON FIXTURE INSTALLATION.
6. A DUST CONTROL PLAN MEETING THE REQUIREMENTS OF RULE 310 OF THE MARICOPA COUNTY AIR POLLUTION CONTROL REGULATIONS, AS AMENDED, IS REQUIRED.
7. A SEPARATE PERMIT IS NECESSARY FOR ANY OFFSITE CONSTRUCTION.
8. AN APPROVED GRADING AND DRAINAGE PLAN SHALL BE ON THE JOB SITE AT ALL TIMES. DEVIATIONS FROM THE PLAN MUST BE PRECEDED BY AN APPROVED PLAN REVISION.
9. EAVE PROJECTIONS INTO REQUIRED SETBACKS ARE LIMITED TO A MAXIMUM OF 24" PURSUANT TO SECTION 1008 OF THE TOWN OF PARADISE VALLEY ZONING ORDINANCES.
10. ALL STRUCTURES AND LANDSCAPING WITHIN THE SIGHT VISIBILITY TRIANGLE SHALL HAVE A 2 FOOT MAXIMUM HEIGHT.
11. ALL NEW AND EXISTING ELECTRICAL SERVICE TO BE BURIED UNDERGROUND PER THE TOWN OF PARADISE VALLEY STANDARDS.
12. POOL, SPA, BARBEQUE AND ANY PROPOSED STRUCTURES OVER 8 INCHES ABOVE GRADE REQUIRE SEPARATE PERMIT APPLICATIONS.
13. POOLS SHALL BE CONSTRUCTED BY SEPARATE PERMIT AND SECURED FROM UNWANTED ACCESS PER SECTION 5-2-2 OF THE TOWN OF PARADISE VALLEY ORDINANCES.
14. A SETBACK CERTIFICATION IS REQUIRED AND MUST BE GIVEN TO TOWN INSPECTOR AT STEM WALL INSPECTION.
15. MAIL BOX TO COMPLY WITH THE TOWN OF PARADISE VALLEY STANDARDS FOR MAIL BOXES IN THE R.O.W. FOR HEIGHT, WIDTH AND BREAK AWAY FEATURES.
16. ALL PATIOS, WALKS, AND DRIVES TO SLOPE AWAY FROM BUILDING AND GARAGES AT A MINIMUM SLOPE OF 1/4" PER FOOT UNLESS SPECIFIED OTHERWISE. ALL LAWN AREAS ADJOINING WALKS OR SLABS WILL BE GRADED TO 2" BELOW THE TOP OF SLAB. TYPICAL FINISHED GRADE AROUND PERIMETER OF BUILDING IS MINUS 6" BELOW FINISHED FLOOR UNLESS SPECIFIED OTHERWISE.
17. ALL MATERIAL TO BE UNDER SLABS AND WALKS SHALL BE COMPACTED TO NOT LESS THAN 95% PER ASTM D698.
18. SOILS COMPACTION TEST RESULTS MUST BE SUBMITTED TO THE TOWN ENGINEER'S OFFICE FOR BUILDING PADS THAT HAVE ONE (1) FOOT OR MORE OF FILL MATERIAL INDICATED. THIS INFORMATION MUST BE SUPPLIED PRIOR TO REQUEST FOR FINAL INSPECTION.
19. TRENCH BED SHALL BE FREE OF ROCKS AND DEBRIS.
20. REGULATION II RULE 20-3 OF THE MARICOPA COUNTY HEALTH DEPARTMENT, BUREAU OF AIR POLLUTION CONTROL SHALL BE OBSERVED AND ENFORCED.
21. ALL WORK REQUIRED TO COMPLETE THE CONSTRUCTION COVERED BY THIS PLAN SHALL BE IN ACCORDANCE WITH THE M.A.G. STANDARD SPECIFICATIONS AND DETAILS AND CURRENT SUPPLEMENTS THEREOF PER THE LOCAL CITY OR TOWN UNLESS SPECIFIED OTHERWISE IN THESE PLANS OR ELSEWHERE IN THE CONTRACT DOCUMENTS. CONTRACTORS SHALL FAMILIARIZE THEMSELVES WITH REQUIRED STANDARD SPECIFICATIONS, DETAILS, AND SUPPLEMENTS PRIOR TO BIDDING THE WORK FOR THE CONSTRUCTION COVERED BY THIS PLAN.
22. THE CONTRACTOR IS TO COMPLY WITH ALL LOCAL STATE, AND FEDERAL LAWS AND REGULATIONS APPLICABLE TO THE CONSTRUCTION COVERED BY THIS PLAN.
23. THE CONTRACTOR IS RESPONSIBLE FOR OBTAINING AND COMPLYING WITH ALL PERMITS REQUIRED TO COMPLETE ALL WORK COVERED BY THIS PLAN.
24. ALL CONSTRUCTION IN THE PUBLIC RIGHTS-OF-WAY OR IN EASEMENTS GRANTED FOR PUBLIC USE MUST CONFORM TO THE LATEST MARICOPA ASSOCIATION OF GOVERNMENTS (MAG) UNIFORM STANDARD SPECIFICATIONS AND UNIFORM STANDARD DETAILS FOR PUBLIC WORKS CONSTRUCTION.
25. THE TOWN ONLY APPROVES THE SCOPE, NOT THE DETAIL, OF ENGINEERING DESIGNS; THEREFORE, IF CONSTRUCTION QUANTITIES ARE SHOWN ON THESE PLANS, THEY ARE NOT VERIFIED BY THE TOWN.
26. THE APPROVAL OF PLANS IS VALID FOR SIX (6) MONTHS. IF AN ENCROACHMENT PERMIT FOR THE CONSTRUCTION HAS NOT BEEN ISSUED WITHIN SIX MONTHS, THE PLANS MUST BE RESUBMITTED TO THE TOWN FOR RE-APPROVAL.
27. A PUBLIC WORKS INSPECTOR WILL INSPECT ALL WORKS WITHIN THE TOWN OF PARADISE VALLEY RIGHTS-OF-WAY AND IN EASEMENTS. NOTIFY INSPECTION SERVICES 24 HOURS PRIOR TO BEGINNING CONSTRUCTION BY CALLING 480- 312-5750.
28. WHENEVER EXCAVATION IS NECESSARY, CALL THE BLUE STAKE CENTER, 602-263-1100, TWO WORKING DAYS BEFORE EXCAVATION BEGINS. THE CENTER WILL SEE THAT THE LOCATION OF THE UNDERGROUND UTILITY LINES IS IDENTIFIED FOR THE PROJECT. CALL "COLLECT" IF NECESSARY.
29. ENCROACHMENT PERMITS ARE REQUIRED FOR ALL WORK IN PUBLIC RIGHTS-OF-WAY AND EASEMENTS GRANTED FOR PUBLIC PURPOSES. AN ENCROACHMENT PERMIT WILL BE ISSUED BY THE TOWN ONLY AFTER THE REGISTRANT HAS PAID A BASE FEE PLUS A FEE FOR INSPECTION SERVICES. COPIES OF ALL PERMITS MUST BE OBTAINED ON-SITE AND BE AVAILABLE FOR INSPECTION AT ALL TIMES. FAILURE TO PRODUCE THE REQUIRED PERMITS WILL RESULT IN IMMEDIATE SUSPENSION OF ALL WORK UNTIL THE PROPER PERMIT DOCUMENTATION IS OBTAINED.
30. ALL EXCAVATION AND GRADING THAT IS NOT IN THE PUBLIC RIGHTS-OF-WAY OR NOT IN EASEMENTS GRANTED FOR PUBLIC USE MUST CONFORM TO CHAPTER 70, EXCAVATION AND GRADING, OF THE LATEST EDITION OF THE IBC BY THE ICC. A PERMIT FOR THIS GRADING MUST BE SECURED FROM THE TOWN FOR A FEE ESTABLISHED BY THE UNIFORM BUILDING CODE.
31. EXCAVATIONS SHALL COMPLY WITH REQUIREMENTS OF OSHA EXCAVATION STANDARDS (29 CFR, PART 1926, SUBPART P). UNDER NO CIRCUMSTANCES WILL THE CONTRACTORS BE ALLOWED TO WORK IN A TRENCH LOCATED WITHIN THE TOWN'S RIGHT-OF-WAY WITHOUT PROPER SHORING OR EXCAVATION METHODS.
32. ON DEMOLITION, GRADING, REMODELING AND NEW CONSTRUCTION PROJECTS, PERMITTEE MUST NOTIFY ADJACENT PROPERTY OWNERS REGARDING THE NATURE OF THE PROJECT, THE TIME PERIOD FOR CONSTRUCTION, AND ANY UNUSUAL ACTIVITIES THAT MAY CAUSE DISRUPTION OF THE NORMAL COURSE OF BUSINESS DURING CONSTRUCTION.
33. ALL PERMITTEES MUST POST A 6 SQUARE FOOT (2'X3') IDENTIFICATION SIGN, MADE OF DURABLE MATERIAL, IN THE FRONT YARD OF SUBJECT PROPERTY AND NOT IN THE TOWN RIGHT-OF-WAY. THE SIGN MAY NOT EXCEED A MAXIMUM OF 6 FEET IN HEIGHT FROM GRADE TO TOP OF THE SIGN. THE SIGN MUST INCLUDE THE PERMITTEE OR COMPANY NAME, PHONE NUMBER, TYPE OF WORK, AND ADDRESS OF PROJECT.
34. WHEN DEEMED NECESSARY, A 6-FOOT HIGH CHAIN LINK FENCE MUST BE INSTALLED AROUND THE CONSTRUCTION AREA TO PREVENT ANY POTENTIAL SAFETY HAZARD FOR THE PUBLIC. THE FENCE SHALL BE SETBACK AT LEAST 10 FEET FROM ALL RIGHTS-OF-WAY AND HAVE A 50-FOOT STREET CORNER SITE TRIANGLE WHERE APPLICABLE.
35. CLEAR ACCESS FOR NEIGHBORING PROPERTIES AND EMERGENCY VEHICLES MUST BE MAINTAINED AT ALL TIMES. CONSTRUCTION RELATED VEHICLES MUST BE LEGALLY PARKED ONLY ON ONE SIDE OF THE STREET OR ON ONE SIDE OF THE PROPERTY. A STAGING AREA IS NEEDED ON A PROPERTY OTHER THAN THE CONSTRUCTION SITE FOR CONSTRUCTION SUPPLIES AND EQUIPMENT. THE PERMITTEE MUST OBTAIN PROPERTY OWNER AND TOWN APPROVAL FIRST AND MUST INFORM THE ADJACENT PROPERTY OWNERS OF THE LOCATION OF STAGING AREA, AND TIME AND HOURS DURING THE DAY THE AREA WILL BE USED.
36. EXCEPT AS OUTLINED IN ITEM 4, ALL CONSTRUCTION DEBRIS AND EQUIPMENT MUST BE CONTAINED ON SITE AT ALL TIMES. CONTRACTOR AND PROPERTY OWNER MUST MAINTAIN THE JOB SITE FREE OF LITTER AND UNSIGHTLY MATERIALS AT ALL TIMES. CONSTRUCTION MATERIALS ARE PROHIBITED IN THE TOWN RIGHT-OF-WAY OR NEAR ADJACENT PROPERTIES.
37. BUILDING CONSTRUCTION MUST NOT START SOONER THAN SUNRISE AND MUST STOP NO LATER THAN SUNSET. ALSO, ORDINANCE #661 IMPOSES RESTRICTIONS ON CONSTRUCTION WORK ON SATURDAYS, SUNDAYS AND PUBLIC HOLIDAYS. THE BUSINESS HOURS MAY BE ADJUSTED BY THE TOWN WITH THE FOLLOWING RESTRICTIONS: EQUIPMENT WITH AUDIBLE REVERSE DIRECTION WARNINGS MUST NOT BE OPERATED PRIOR TO 7:00 A.M.
38. THE USE AND OPERATION OF FUEL-FIRED GENERATORS ON ANY CONSTRUCTION SITE, NEW, EXISTING OR REMODELING, IS PROHIBITED UNLESS DUE TO A HARSH TOWN APPROVAL IS OBTAINED.
39. THE CONTRACTOR AND PROPERTY OWNER WILL BE LIABLE FOR ANY DAMAGE DONE TO ANY PUBLIC PROPERTY AS A RESULT OF ANY CONSTRUCTION OR CONSTRUCTION RELATED ACTIVITIES. NO CERTIFICATE OF OCCUPANCY WILL BE ISSUED UNTIL ALL AFFECTED RIGHTS-OF-WAY ARE CLEANED AND/OR REPAIRED TO THEIR ORIGINAL CONDITION AND UNTIL ANY AND ALL DAMAGES TO AFFECTED PROPERTIES ARE RESTORED TO ORIGINAL CONDITION, OR UNTIL SUCH TIME THAT A WRITTEN, SIGNED AND LEGALLY BINDING AGREEMENT HAS BEEN REACHED BY THE PARTIES INVOLVED TO REMEDY ANY VIOLATION WITHIN A REASONABLE TIME PERIOD, AND ALL REQUIRED FEES ARE PAID IN FULL.
40. THE NATURAL FLOW OF RAINWATER AND OTHER SURFACE DRAINAGE FROM THE PROPERTY MAY NOT BE ALTERED IN ANY WAY.
41. A KEY SWITCH SHALL BE REQUIRED ON ALL NEW AND EXISTING ELECTRIC ENTRY CONTROL GATES. THE KEY SWITCH SHALL BE INSTALLED IN A LOCATION ON THE GATE CONTROL PANEL THAT IS READILY VISIBLE AND ACCESSIBLE. KNOX BOX ORDER FORMS ARE AVAILABLE AT THE PARADISE VALLEY BUILDING DEPARTMENT.
42. ALL EQUIPMENT OF ALL TRADES ON OR AFFECTING THE JOB MUST BE CLEANED ONLY IN A PRE-DETERMINED AND DESIGNATED AREA. DEBRIS AND RUNOFF FROM SAID AREA MAY NOT EXTEND BEYOND THE BUILDING AREA.
43. PROPERTY OWNER, BUILDER, OR GENERAL CONTRACTOR WILL BE RESPONSIBLE FOR CONTROLLING DUST FROM ALL TRUCKS AT ALL TIMES. ALL MEANS MUST BE USED BY THE BUILDER OR GENERAL CONTRACTOR TO CONTROL THE EXISTENCE OF DUST CAUSED BY ANY AIRWORK, SPRAY APPLICATION OF MATERIALS, OR OTHER DUST-CAUSING PRACTICES REQUIRED BY THE CONSTRUCTION PROCESS.
44. AN INSPECTION FEE WILL BE CHARGED IF THE INSPECTION IS REQUIRED AS A RESULT OF A CODE VIOLATION.
45. FOR DEMOLITION INSPECTION OWNER OR PERMITTEE SHALL NOTIFY OSHA FOR ASBESTOS INSPECTION. ALL DEMOLITIONS AND ALL RENOVATION ACTIVITIES THAT WILL DISTURB FRIABLE ASBESTOS CONTAINING MATERIALS MUST BE REPORTED TO THE MARICOPA COUNTY ENVIRONMENTAL SERVICES DEPARTMENT.

ENGINEERS NOTES

1. MARICOPA ASSOCIATION OF GOVERNMENTS (M.A.G.) UNIFORM STANDARD SPECIFICATIONS AND DETAILS FOR PUBLIC WORKS CONSTRUCTION (LATEST EDITION INCLUDING LATEST REVISION AND CURRENT SUPPLEMENTS THEREOF PER THE LOCAL TOWN OR CITY) ARE INCORPORATED INTO THIS PLAN IN THEIR ENTIRETY.
2. ALL WORK REQUIRED TO COMPLETE THE CONSTRUCTION COVERED BY THIS PLAN SHALL BE IN ACCORDANCE WITH THE M.A.G. STANDARD SPECIFICATIONS AND DETAILS AND CURRENT SUPPLEMENTS THEREOF PER THE LOCAL CITY OR TOWN UNLESS SPECIFIED OTHERWISE IN THESE PLANS OR ELSEWHERE IN THE CONTRACT DOCUMENTS.
3. CONTRACTORS SHALL FAMILIARIZE THEMSELVES WITH ALL REQUIRED STANDARD SPECIFICATIONS, DETAILS AND SUPPLEMENTS PRIOR TO BIDDING THE WORK FOR THE CONSTRUCTION COVERED BY THIS PLAN.
4. GRADING SHALL BE IN CONFORMANCE WITH 2012 IBC SEC. 1803 AND APPENDIX J.
5. 5% MINIMUM SLOPE AWAY FROM BUILDING FOR A MINIMUM 10', U.N.O.
6. ALL CONSTRUCTION SHALL CONFORM TO THE LATEST MARICOPA ASSOCIATION OF GOVERNMENTS (M.A.G.) SPECIFICATIONS AND STANDARD DETAILS.
7. A DUST CONTROL PLAN MEETING THE REQUIREMENTS OF RULE 310 OF THE MARICOPA COUNTY AIR POLLUTION CONTROL REGULATIONS, AS AMENDED, IS REQUIRED.
8. A SEPARATE PERMIT IS NECESSARY FOR ANY OFFSITE CONSTRUCTION.
9. AN APPROVED GRADING AND DRAINAGE PLAN SHALL BE ON THE JOB SITE AT ALL TIMES. DEVIATIONS FROM THE PLAN MUST BE PRECEDED BY AN APPROVED PLAN REVISION.
10. ALL DRAINAGE PROTECTIVE DEVICES SUCH AS SWALES, INTERCEPTOR DITCHES, PIPES, PROTECTIVE BERMS, BARRIER WALLS, CONCRETE CHANNELS OR OTHER MEASURES DESIGNED TO PROTECT ADJACENT BUILDINGS OR PROPERTY FROM STORM RUNOFF MUST BE COMPLETED PRIOR TO BUILDING CONSTRUCTION.
11. ALL STRUCTURES AND LANDSCAPING WITHIN THE SIGHT VISIBILITY TRIANGLE SHALL HAVE A 2 FOOT MAXIMUM HEIGHT.
12. ALL PATIOS, WALKS, AND DRIVES TO SLOPE AWAY FROM BUILDING AND GARAGES AT A MINIMUM SLOPE OF 1/4" PER FOOT UNLESS SPECIFIED OTHERWISE. ALL LAWN AREAS ADJOINING WALKS OR SLABS WILL BE GRADED TO 2" BELOW THE TOP OF SLAB. TYPICAL FINISHED GRADE AROUND PERIMETER OF BUILDING IS MINUS 6" BELOW FINISHED FLOOR UNLESS SPECIFIED OTHERWISE.
13. ALL MATERIAL TO BE UNDER SLABS AND WALKS SHALL BE COMPACTED TO NOT LESS THAN 95% PER ASTM D698.
14. THE QUANTITIES AND SITE CONDITIONS DEPICTED IN THESE PLANS ARE FOR INFORMATIONAL PURPOSES ONLY AND ARE SUBJECT TO ERROR AND OMISSION. CONTRACTORS SHALL SATISFY THEMSELVES AS TO ACTUAL QUANTITIES AND SITE CONDITIONS PRIOR TO BIDDING THE WORK FOR THE CONSTRUCTION COVERED BY THIS PLAN.
15. THE CONTRACTOR IS RESPONSIBLE FOR OBTAINING AND COMPLYING WITH ALL PERMITS REQUIRED TO COMPLETE ALL WORK COVERED BY THIS PLAN.
16. THE CONTRACTOR IS RESPONSIBLE FOR ALL METHODS, SEQUENCING, AND SAFETY CONCERNS ASSOCIATED WITH THIS PROJECT DURING CONSTRUCTION, UNLESS SPECIFICALLY ADDRESSED OTHERWISE IN THIS PLAN OR ELSEWHERE.
17. A REASONABLE EFFORT HAS BEEN MADE TO SHOW THE LOCATIONS OF EXISTING UNDERGROUND FACILITIES AND UTILITIES IN THE CONSTRUCTION AREA. THE CONTRACTOR IS RESPONSIBLE FOR ANY DAMAGE TO UTILITIES AND/OR FACILITIES CAUSED DURING THEIR CONSTRUCTION OPERATIONS. THE CONTRACTOR SHALL CALL 48 HOURS IN ADVANCE FOR BLUE STAKE (1-800-STAKE-11) PRIOR TO ANY EXCAVATION.
18. THE CONTRACTOR IS RESPONSIBLE FOR ALL COORDINATION OF CONSTRUCTION AFFECTING UTILITIES AND THE COORDINATION OF ANY NECESSARY UTILITY RELOCATION WORK.
19. ALL PAVING, GRADING, EXCAVATION, TRENCHING, PIPE BEDDING, CUT, FILL AND BACKFILL SHALL COMPLY WITH THE RECOMMENDATIONS SET FORTH IN THE SOILS (GEOTECHNICAL) REPORT FOR THIS PROJECT IN ADDITION TO THE PRESENTED REQUIRED SPECIFICATIONS AND DETAILS.
20. THE CONTRACTOR IS TO VERIFY THE LOCATION AND THE ELEVATIONS OF ALL EXISTING UTILITIES AT POINTS OF TIE-IN PRIOR TO COMMENCING ANY NEW CONSTRUCTION. SHOULD ANY LOCATION OR ELEVATION DIFFER FROM THAT SHOWN ON THESE PLANS, THE CONTRACTOR SHALL CONTACT THE OWNER'S AGENT.
21. CONTRACTOR TO VERIFY AND COORDINATE ALL DIMENSIONS AND SITE LAYOUT WITH ARCHITECTURE'S FINAL SITE PLAN AND FINAL BUILDING DIMENSIONS BEFORE STARTING WORK. REPORT DISCREPANCIES TO OWNER'S AGENT.
22. COORDINATION BETWEEN ALL PARTIES IS ESSENTIAL PART OF CONTRACT.
23. CONTRACTOR IS RESPONSIBLE FOR PROJECT AND SITE CONDITIONS, AND TO WORK WITH WEATHER CONDITIONS AS THE PROJECT SITE MAY BE LOCATED IN A FLOOD PRONE AREA AND SUBJECT TO FLOODING AND ITS HAZARDS.
24. THE CONTRACTOR IS TO VERIFY THE LOCATION, ELEVATION, CONDITION, AND PAVEMENT CROSS-SLOPE OF ALL EXISTING SURFACES AT POINTS OF TIE-IN AND MATCHING, PRIOR TO COMMENCEMENT OF GRADING, PAVING, CURB AND GUTTER, OR OTHER SURFACE CONSTRUCTION. SHOULD EXISTING LOCATIONS, ELEVATIONS, CONDITION, OR PAVEMENT CROSS-SLOPE DIFFER FROM THAT SHOWN ON THESE PLANS, RESULTING IN THE DESIGN INTENT REFLECTED ON THESE PLANS NOT ABLE TO BE CONSTRUCTED, THE CONTRACTOR SHALL NOTIFY THE OWNER'S AGENT IMMEDIATELY FOR DIRECTION ON HOW TO PROCEED PRIOR TO COMMENCEMENT OF CONSTRUCTION. THE CONTRACTOR ACCEPTS RESPONSIBILITY FOR ALL COSTS ASSOCIATED WITH CORRECTIVE ACTION IF THESE PROCEDURES ARE NOT FOLLOWED.
25. CONTRACTOR IS RESPONSIBLE TO COORDINATE UTILITY CROSSINGS AT CULVERT CROSSINGS BEFORE STARTING WORK ON CULVERT. COORDINATE WITH OWNER REPRESENTATIVE. VERIFY UTILITY LINES AND/OR CONDUITS ARE IN PLACE BEFORE STARTING CULVERT WORK.
26. ALL ON-SITE UTILITIES PER OTHERS.
27. THIS PROJECT REQUIRES A REGULAR ONGOING MAINTENANCE PROGRAM FOR THE DESIGNED DRAINAGE SYSTEM(S) TO PRESERVE THE DESIGN INTEGRITY AND THE ABILITY TO PERFORM ITS OPERATIONAL INTENT. FAILURE TO PROVIDE MAINTENANCE TO COMBARE DRAINAGE SYSTEM(S)' PERFORMANCE AND MAY LEAD TO ITS INABILITY TO PERFORM PROPERLY AND/OR CAUSE DAMAGE ELSEWHERE IN THE PROJECT.
28. IF A DISCREPANCY IS FOUND BETWEEN ENGINEER'S PLAN OR SURVEYOR'S STAKING AND THE ARCHITECTURAL PLAN, ENGINEER SHALL BE NOTIFIED IMMEDIATELY. FAILURE TO NOTIFY ENGINEER SHALL NEGATE ENGINEER'S LIABILITY.
29. ALL DISTURBED AREAS ARE TO BE ROPED AND ROPING MUST MATCH PLAN.
30. VEGETATION OUTSIDE OF CONSTRUCTION AREA TO REMAIN.
31. AREAS OUTSIDE THE WALL AND CUT AND FILL SLOPES SHALL BE REVEGETATED WITH SIMILAR PLANT TYPES AND DENSITIES FOUND ON THE SITE. REVEGETATION SHALL BE COMPLETED PRIOR TO OCCUPANCY AND THE ISSUANCE OF A CERTIFICATE OF OCCUPANCY.
32. MECHANICAL EQUIPMENT SHALL BE SCREENED TO A MINIMUM OF ONE FOOT ABOVE TOP OF EQUIPMENT.
33. ANY FUTURE IMPROVEMENTS SHOWN HEREON SHALL REQUIRE A SEPARATE PERMIT.
34. ANY POINTS OF DRAINAGE CONCENTRATION SHOULD BE PROTECTED AGAINST EROSION WITH NATIVE STONE.
35. THIS PLAN IS DESIGNED TO SHOW SITE GRADING AND DRAINAGE. CONTRACTOR SHALL USE THE ARCHITECTURAL SITE PLAN TO DETERMINE FINAL HOUSE, WALL, STEP, ETC., LOCATIONS AND ELEVATIONS.
36. ALL DRAINAGE FACILITIES TO BE MAINTAINED BY HOMEOWNER.
37. SEE ARCHITECTURAL AND STRUCTURAL PLANS FOR SITE AND RETAINING WALLS LAYOUT, DIMENSIONS, AND DETAILS. TOP OF FOOTING ELEVATIONS SHOWN IN PLAN ARE APPROXIMATE ONLY. ACTUAL TOP OF FOOTINGS TO BE DETERMINED AT TIME OF CONSTRUCTION AND TO BE A MINIMUM OF SIX INCHES BELOW EXISTING NATURAL GRADE OR FINISHER GRADE (WHICHEVER IS LOWER).
38. REFER TO ARCHITECTURAL DRAWINGS FOR BUILDING LAYOUT, DIMENSIONS AND ELEVATIONS.
39. REFER TO STRUCTURAL DRAWINGS, DETAILS AND CALCULATIONS FOR ALL PROPOSED RETAINING WALLS.
40. FOR CHANGE IN ELEVATION THAT ARE GREATER THAN 30", PROVIDE 36" HIGH GUARDRAILS FOR TOTAL OF 42" FALL PROTECTION BARRIER U.N.O.
41. CONTRACTOR TO PROVIDE POSITIVE DRAINAGE AWAY FROM STRUCTURE - 5% MIN SLOPE FOR FIRST 10 FEET, U.N.O.
42. ALL WATER AND SEWER LINES AND CONNECTIONS MUST BE INSTALLED PER IPC 2012, MAG AND TOWN OF PARADISE VALLEY SUPPLEMENT TO MAG.
43. WATERPROOF ALL EXTERIOR WALLS 18" ABOVE FINISH GRADE-(BITUTHENE @ 3000 HC MEMBRANE W/ GRACE PROTECTION 03 OR APPROVED EQUAL).
44. ALL PIPES AND FITTINGS SHALL BE INSTALLED PER MANUFACTURER'S SPECIFICATIONS AND DETAILS.
45. ABANDONMENT OF EXISTING AND INSTALLATION OF NEW SEWIC SYSTEMS SHALL BE PERFORMED IN ACCORDANCE WITH THE MARICOPA COUNTY ENVIRONMENTAL SERVICES DEPARTMENT RULES AND STANDARDS, AND WILL REQUIRE SEPARATE PERMIT.
46. COORDINATE RIPRAP COLOR WITH LANDSCAPE PLANS AND DETAILS.
47. VERIFY AND COORDINATE WITH LANDSCAPE PLANS FINAL LOCATION AND GRATE TYPE OF SPECIFIED AREA DRAINS AND TRENCH DRAINS.
48. VERIFY AND COORDINATE WITH ARCHITECTURAL AND LANDSCAPE PLANS LOCATION AND HEIGHT OF ALL SITE WALLS.
49. REFER TO ARCHITECTURAL PLANS AND DETAILS FOR DEMOLITION AND REMOVAL OF ANY EXISTING BUILDING STRUCTURES, SITE WALLS, POOL AND PAVEMENT ETC.
50. REFER TO GEOTECHNICAL REPORT FOR SPECIFIC RECOMMENDATIONS AND MAXIMUM ALLOWED FILL AND CUT SLOPES.



		SCHERR RESIDENCE 5416 E DESERT JEWEL DR PARADISE VALLEY, AZ 85253		PRELIMINARY GRADING & DRAINAGE PLAN COVER SHEET			
P 602 889 1934 F 602 445 5482 8892 CENTRAL AVE., SUITE 205 PHOENIX, AZ 85020 PHONEX @ LOGGING.COM		Land DEVELOPMENT GROUP					
REVISIONS:		DATE:		SCALE: N.T.S.		DATE: 12/05/17	
				DESIGNED BY: NP		JOB#: 1702018	
				DRAWN BY: DW		VERSION: 1.5	
				CHECKED BY: JJ		PLOT DATE: 12/05/17	
THIS DRAWING IS AN INSTRUMENT OF SERVICE AND AS SUCH SHALL REMAIN PROPERTY OF LAND DEVELOPMENT GROUP, LLC. NO PART OF THIS DRAWING MAY BE REPRODUCED OR TRANSMITTED IN ANY FORM OR BY ANY MEANS, ELECTRONIC OR MECHANICAL, INCLUDING PHOTOCOPYING, RECORDING, OR BY ANY INFORMATION STORAGE AND RETRIEVAL SYSTEM, WITHOUT THE WRITTEN PERMISSION OF LAND DEVELOPMENT GROUP, LLC. PERMITTED TO BE USED FOR THE PROJECT ONLY AND NOT BE REPRODUCED FOR OTHER PROJECTS. LAND DEVELOPMENT GROUP, LLC. ALL RIGHTS RESERVED TO LAND DEVELOPMENT GROUP, LLC. ORIGINAL SITE FOR WHICH IT WAS PREPARED.							

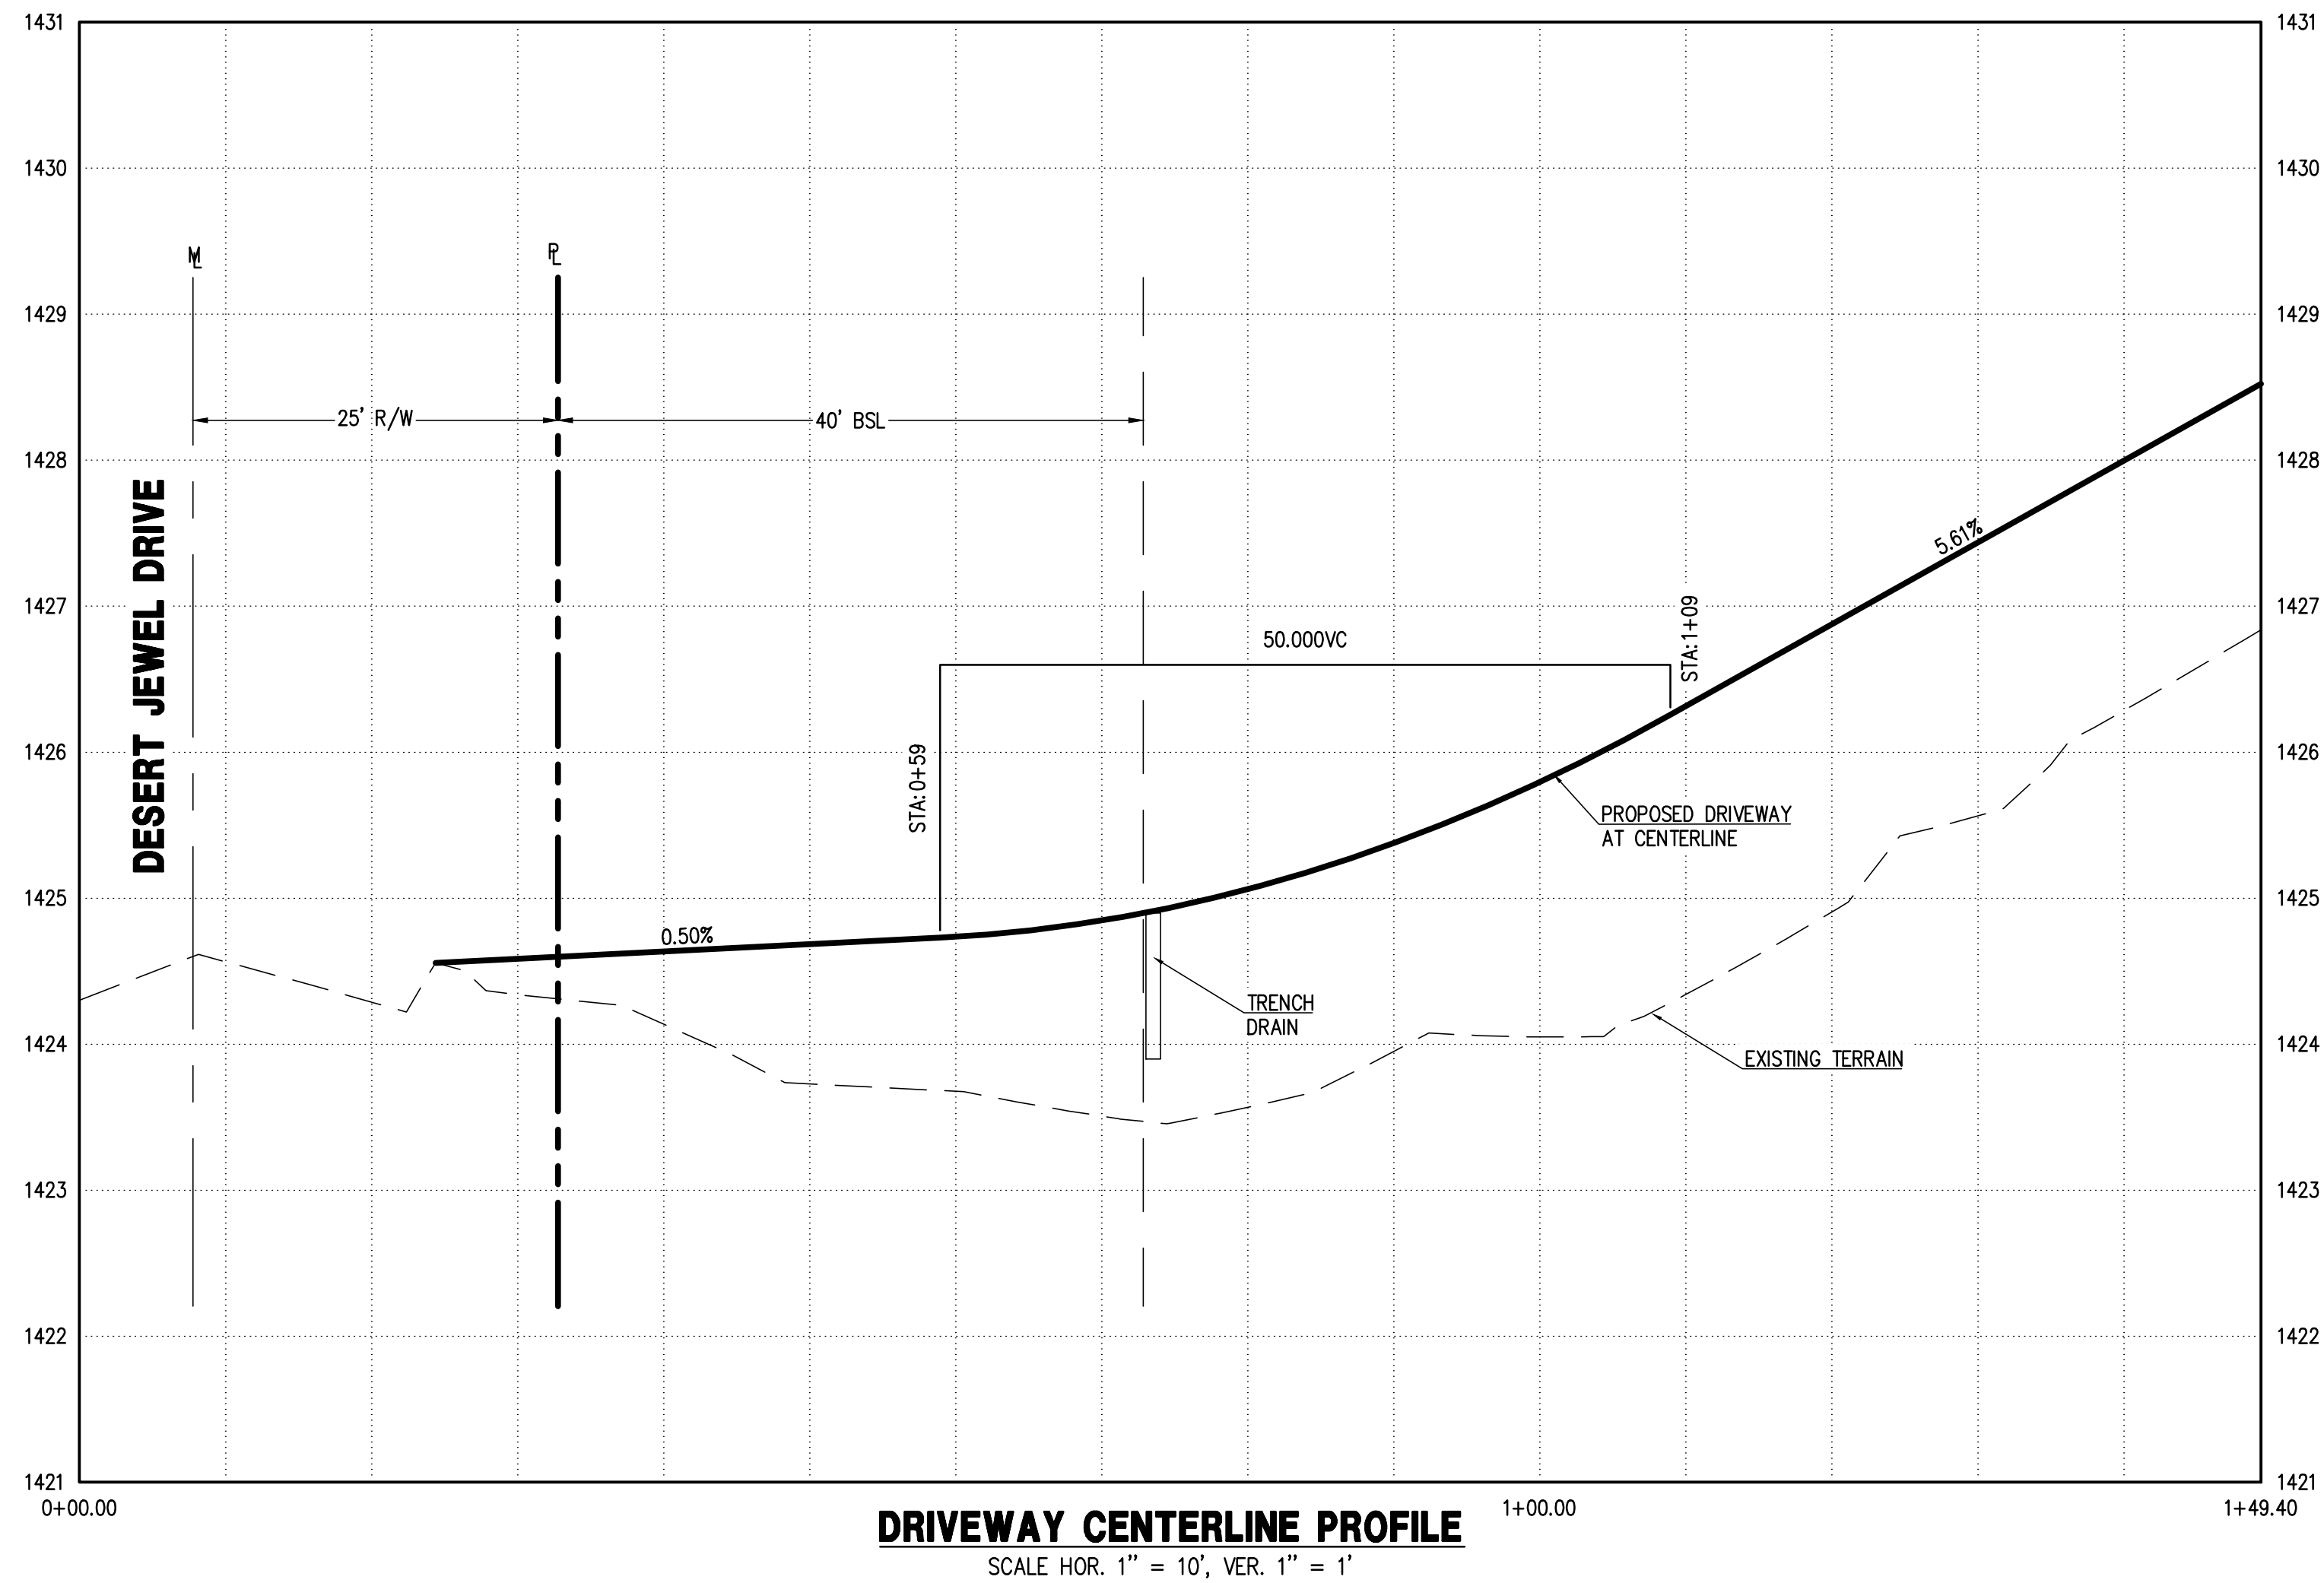

PERCENT PASSING	SIZE	D ₅₀ CLASS, INCHES				
		4	6	8	12	
100 TO 90	1.5 D ₅₀	6	8	12	18	
85 TO 70	1.3 D ₅₀	5	7	10	16	
50 TO 30	1.0 D ₅₀	4	6	8	12	
15 TO 5	0.67 D ₅₀	3	4	5	8	
5 TO 0	0.50 D ₅₀	2	3	4	6	


RIP-RAP GRADATION TABLE
N.T.S.

SPECIFYING ENGINEER IS RESPONSIBLE FOR CONCRETE ENCASEMENT AND REINFORCING BASED UPON APPLICATION AND LOCAL CODES

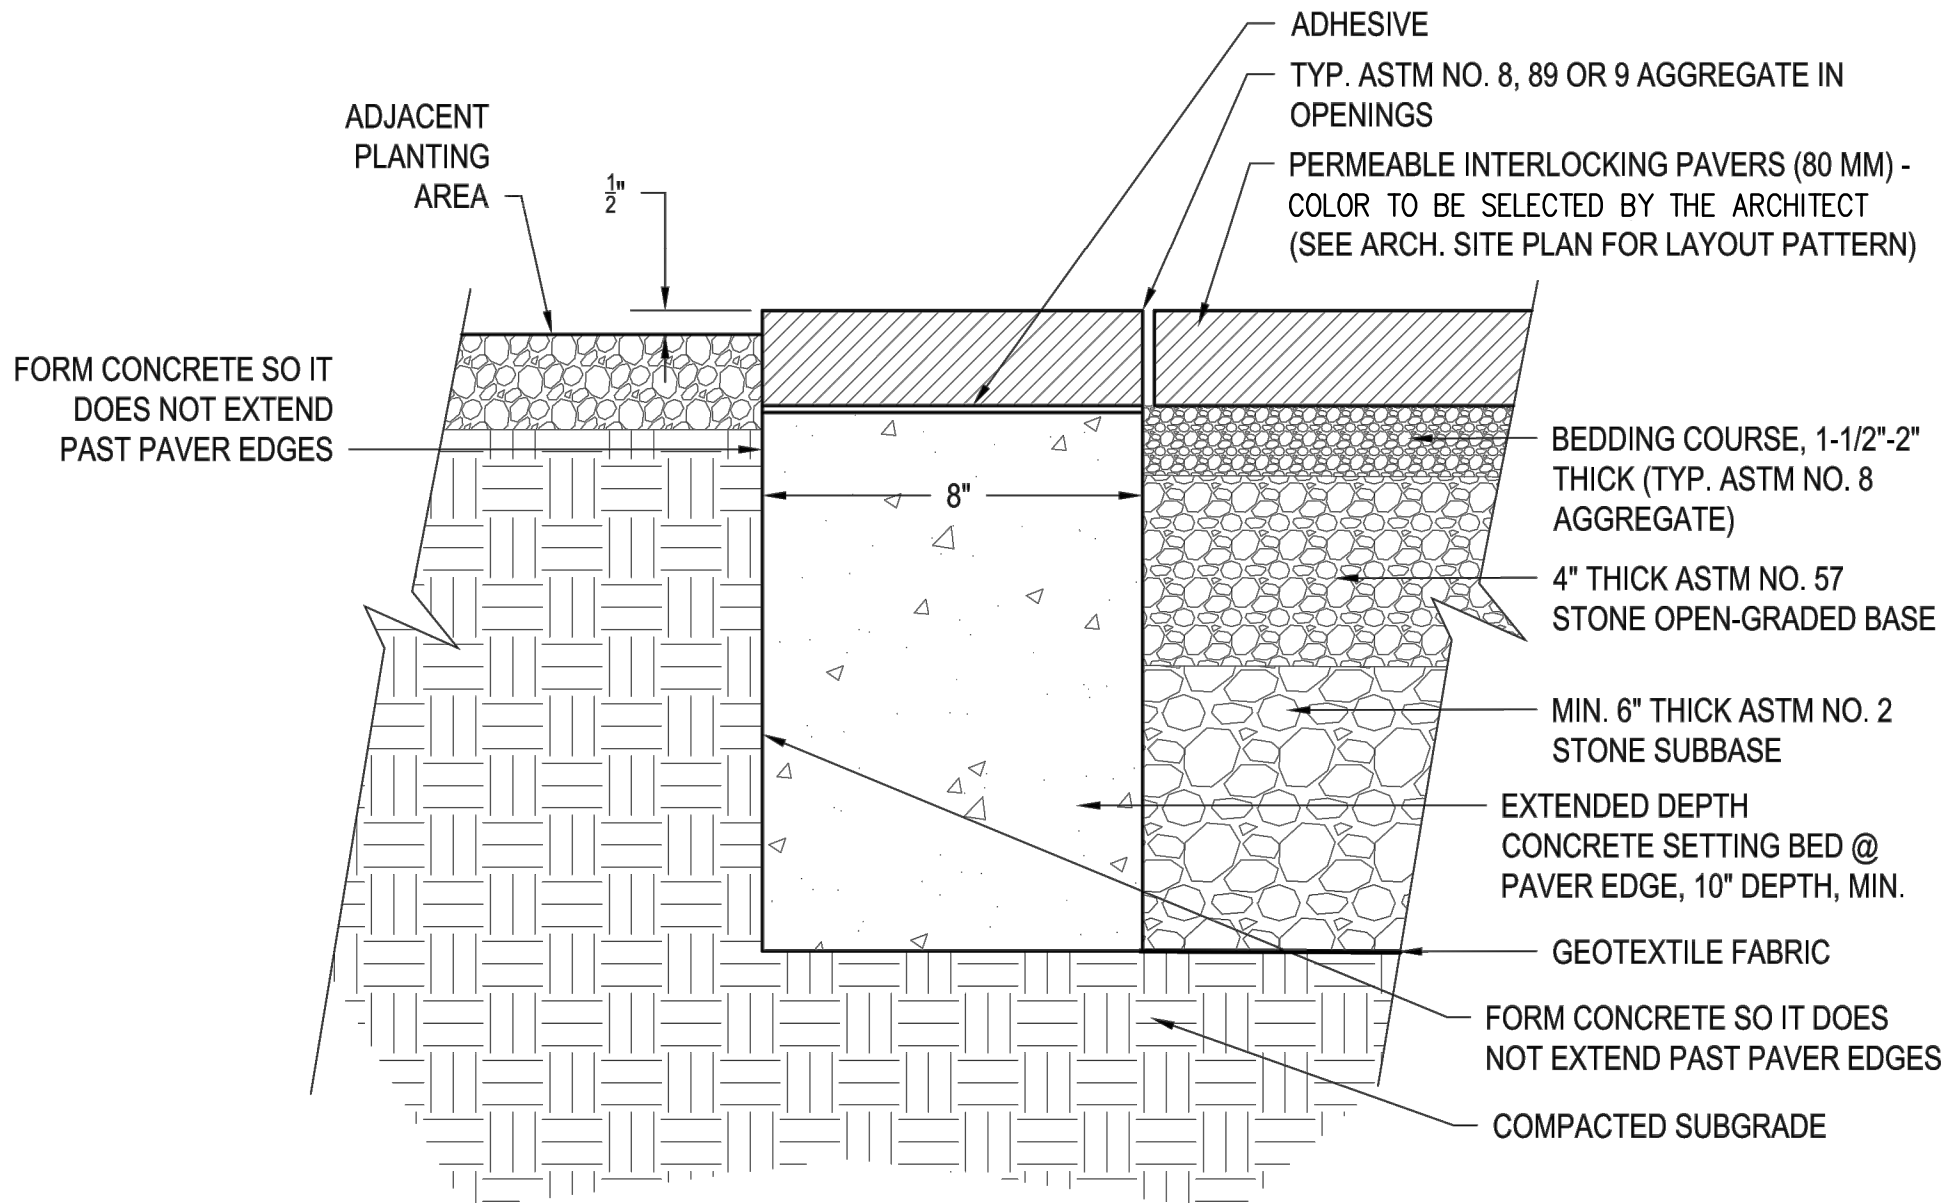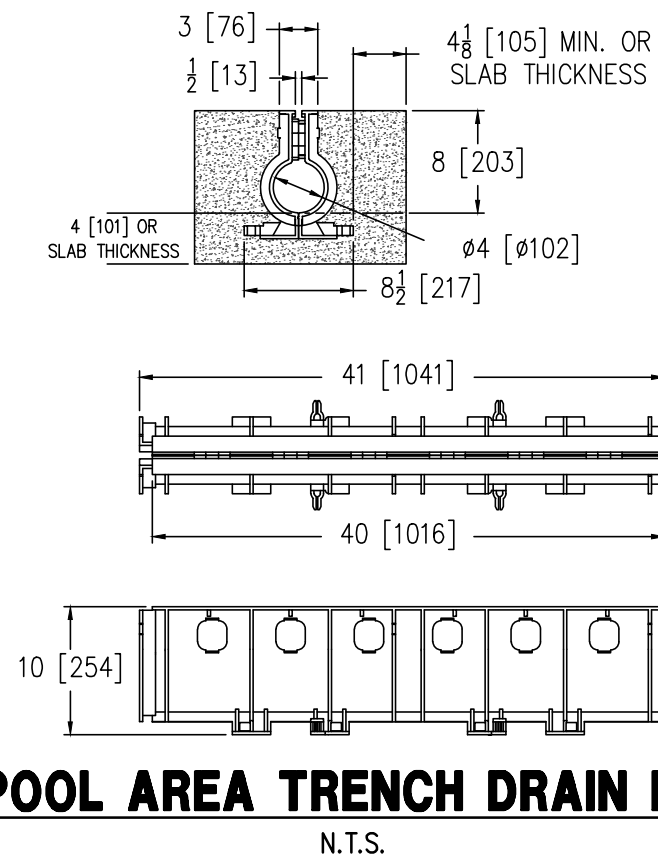

PERMEABLE PAVERS DETAIL

PureWell™ SINGLE-CHAMBER DRYWELL DETAIL

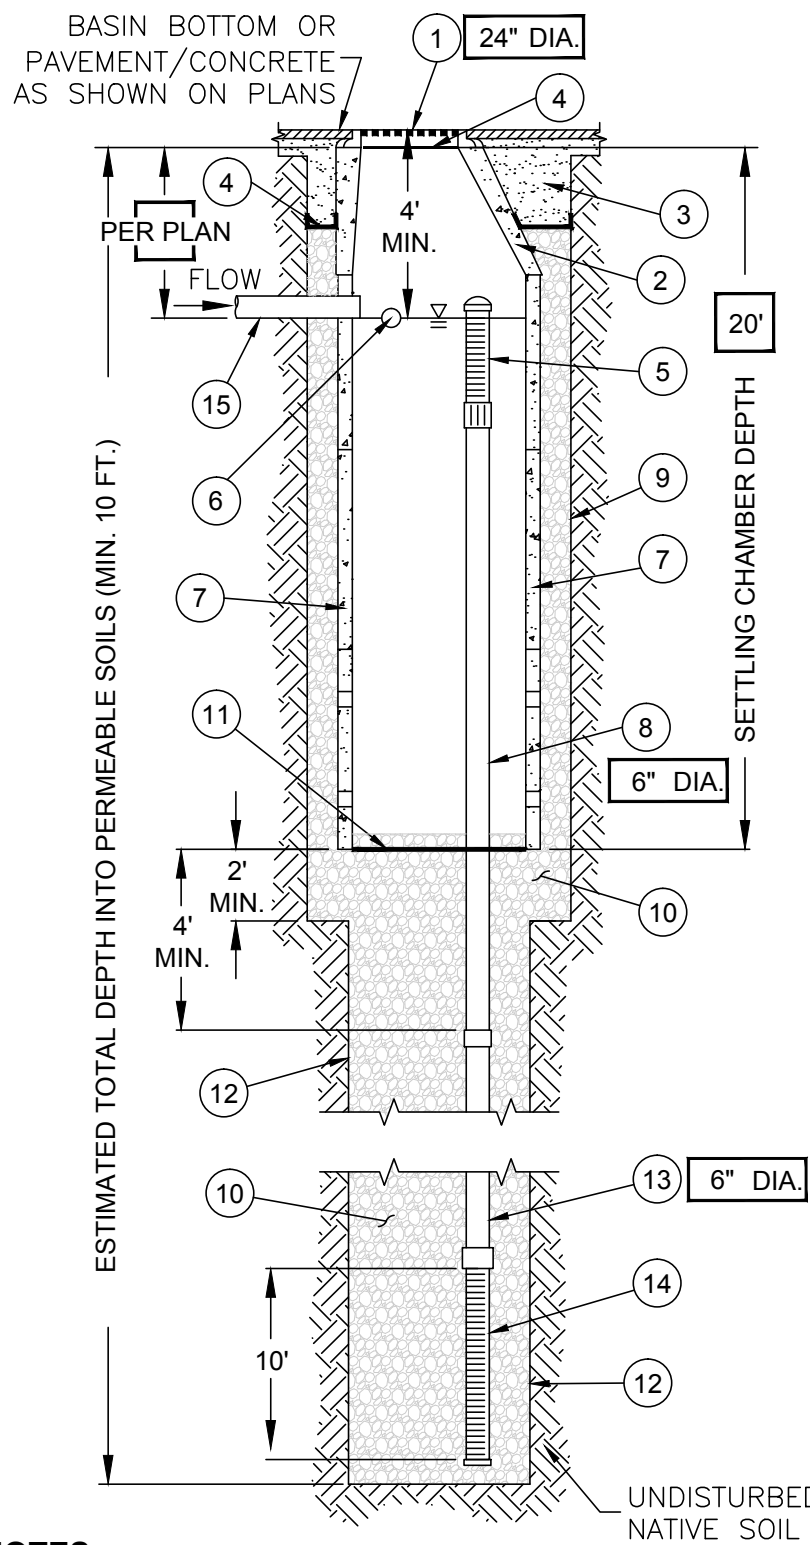

- DRYWELL SPECIFICATIONS**
1. **CAST-IRON GRATE** - CAST-IRON RING AND GRATE BOLTED IN TWO PLACES SECURED TO THE CONE WITH MORTAR. SEE DETAIL FOR GRATE DIAMETER SIZE. RIM/GRATE ELEVATION SET AS SHOWN ON PLANS.
 2. **PRECAST MANHOLE CONE** - SPECIFIED WITH 4000 PSI CONCRETE.
 3. **BACKFILL AROUND CONE** - COMPACTED FILL TO SUBGRADE FOR LANDSCAPE OR 1-SACK SLURRY STABILIZATION FOR PAVEMENT/CONCRETE SURFACING.
 4. **GEOTEXTILE FILTER FABRIC** - NON-WOVEN FABRIC. CONTRACTOR/OWNER TO REMOVE FABRIC ON GRATE ONLY AFTER ALL CONSTRUCTION IS COMPLETE.
 5. **DEBRIS FILTER/SCREEN** - OVERFLOW INTAKE SCREEN/FILTER WITH CAP. USE 2.5" OF SLOTTED, SCH-40 SCREEN PIPE.
 6. **OIL-ABSORBENT PILLOW** - MINIMUM 1 GALLON CAPACITY.
 7. **PRE-CAST DRYWELL LINER** - 48" ID. X 54" OD. USE 4000 PSI CONCRETE. LINER SECTIONS TO BE ALIGNED CENTERED WITH DRILLED SHAFT. BOTTOM SECTION OF LINER TO HAVE PERFORATIONS. SEAL ALL LINER GAPS WITH MORTAR.
 8. **OVERFLOW DRAIN STANDPIPE** - USE CONTINUOUS PVC SCH-40 PIPE MATERIAL WITH A MINIMUM EMBEDMENT OF 4" INTO THE GRAVEL PACK. SEE DETAIL FOR DIAMETER SIZE.
 9. **MINIMUM 6" DIA. DRILLED SHAFT** - SHAFT EXCAVATED IN A MANNER TO PROTECT DRAINAGE SOILS.
 10. **GRAVEL PACK** - 3/8" TO 1-1/2" WASHED, CLEAN GRAVEL PACK INCLUDING SURROUNDING CHAMBER.
 11. **GEOTEXTILE INFILTRATION BARRIER** - 4 OZ. NON-WOVEN FABRIC WITH 2 INCHES OF GRAVEL COVER FOR SECURING FABRIC.
 12. **MINIMUM 4" DIA. DRILLED SHAFT** - SHAFT EXCAVATED IN A MANNER TO PROTECT DRAINAGE SOILS.
 13. **DRYWELL DRAIN PIPE** - USE PVC SDR-35 PIPE MATERIAL. SEE DETAIL FOR DIAMETER SIZE (MIN. 6" DIA.).
 14. **INJECTION SCREEN** - USE SLOTTED SCH-40 SCREEN PIPE.
 15. **OPTIONAL INLET PIPE** - OPTIONAL CONNECTING PIPE, SIZE AND INVERT ELEVATION SPECIFIED PER PLANS (MINIMUM 4" DIA.). CONNECTION TO BE SECURED BY 1-SACK SLURRY BACKFILL.

NOTES:



1. IF 10' OF PERMEABLE MATERIAL IS NOT OBTAINED DURING DRILLING, IT IS RECOMMENDED TO PERFORM A CONSTANT HEAD PERCOLATION TEST TO DETERMINE DISPOSAL RATE. IF DISPOSAL RATE IS LESS THAN WHAT THE MUNICIPALITY/ENGINEER REQUIRES, THEN ADDITIONAL DRYWELLS ARE NEEDED.
2. UPON COMPLETION OF INSTALLATION, CONTRACTOR SHALL VERIFY REGISTRATION OF THE INSTALLED DRYWELLS WITH A.D.E.Q. AND FURNISH THE CITY, OWNER, AND ENGINEER OF RECORD ALL PERTINENT REGISTRATION DOCUMENTATION.
3. ALL DRYWELLS SHALL BE MAINTAINED AND ARE TO BE REPLACED WHEN THEY CEASE TO DRAIN SURFACE WATER WITHIN A 36-HR PERIOD. REGULAR MAINTENANCE OF THE DRYWELL SETTLING CHAMBER IS REQUIRED TO ACHIEVE THE BEST PERFORMANCE OF THE DRYWELL.



916 E. IMPALA AVENUE, STE. 101 (480) 926-1003 TEL
MESA, AZ 85204 (480) 813-9612 FAX

NOT TO SCALE

ROCK OUTLET DETAIL
N.T.S.

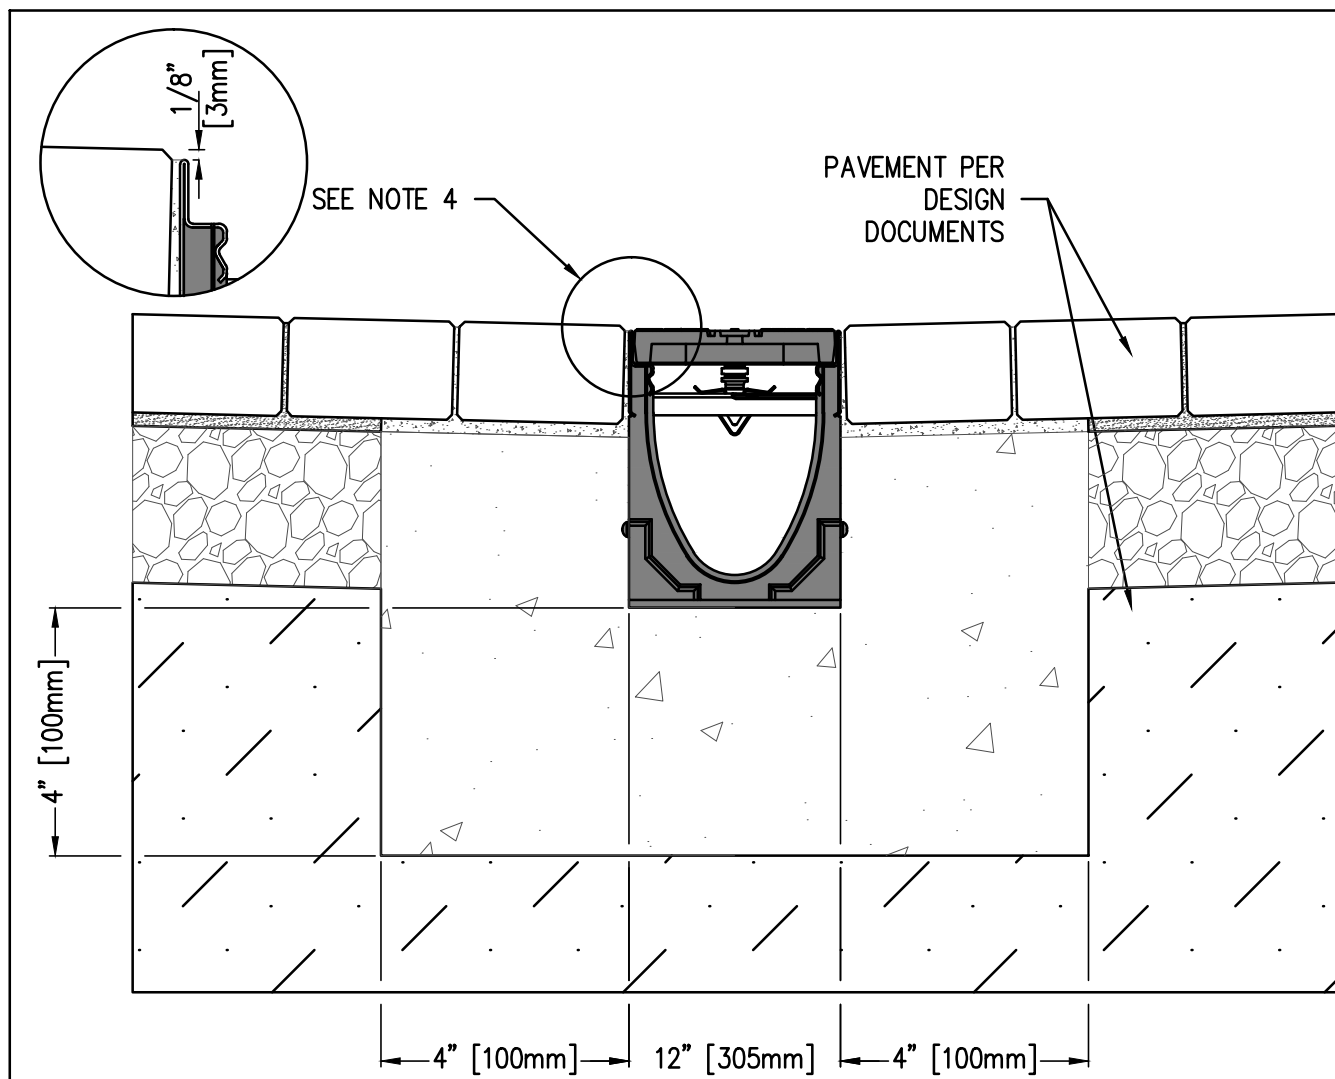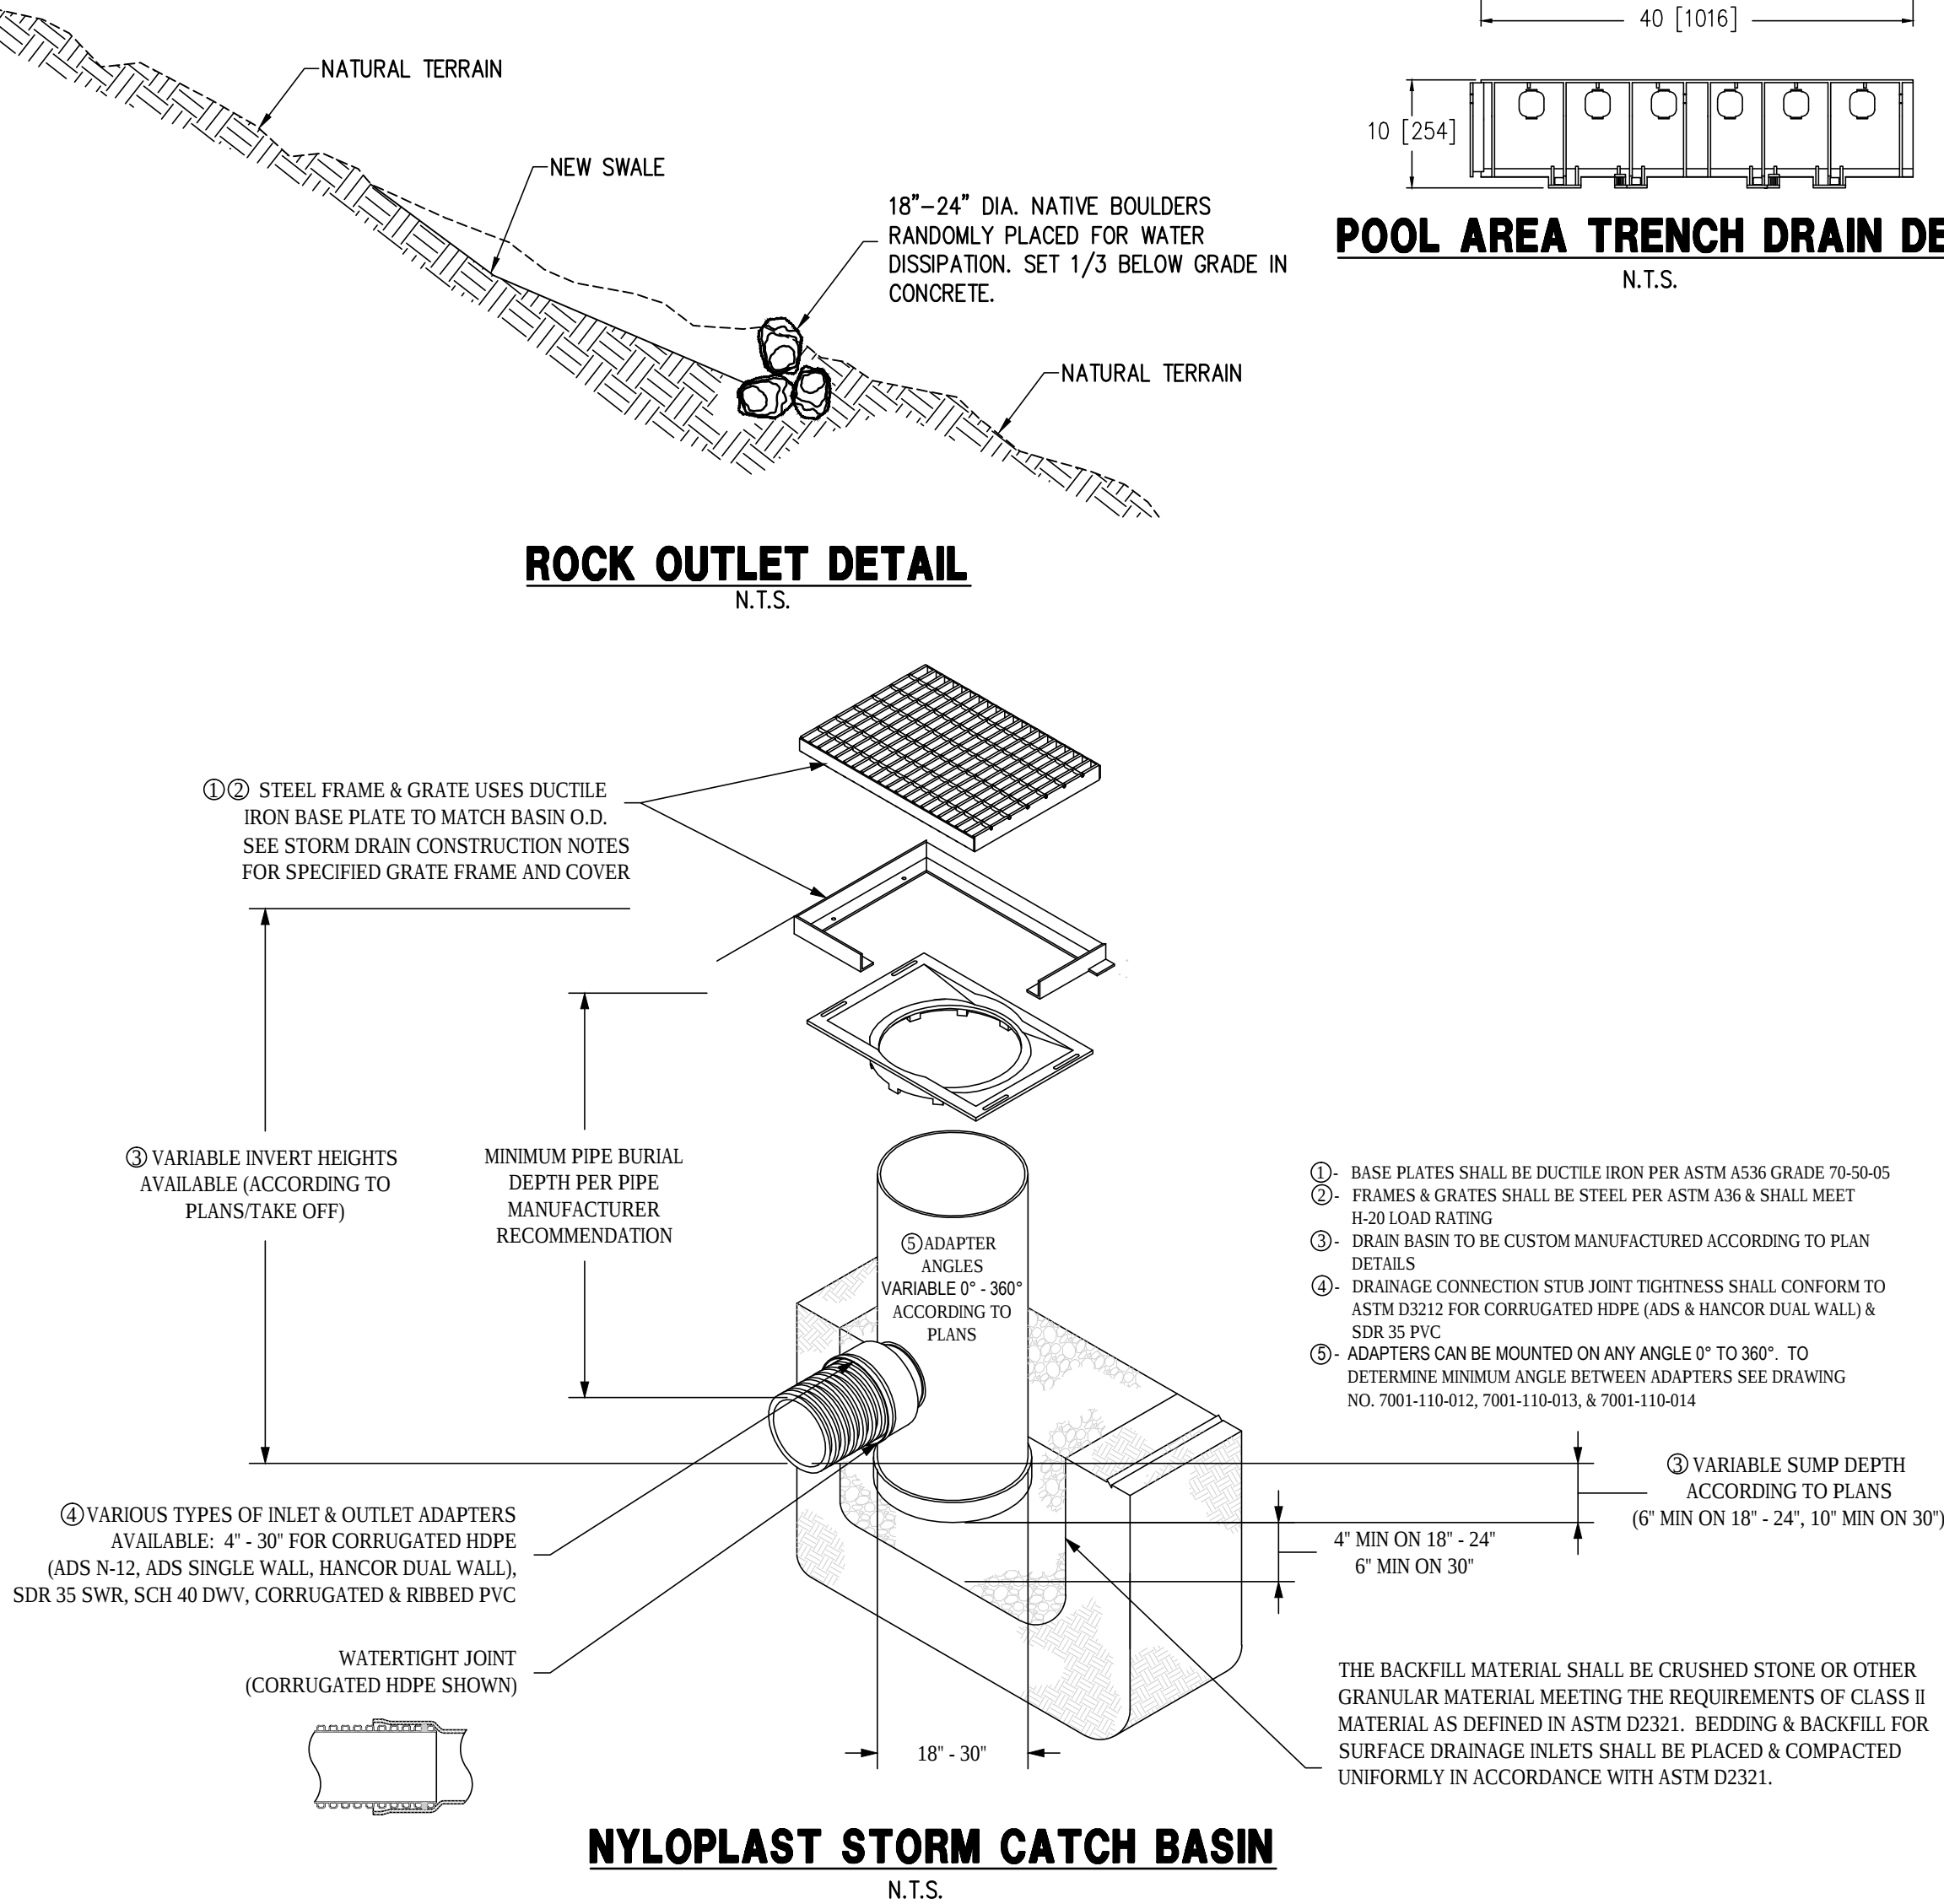

- NOTES:**
1. IT IS NECESSARY TO ENSURE MINIMUM DIMENSIONS SHOWN ARE SUITABLE FOR EXISTING GROUND CONDITIONS.
 2. MINIMUM CONCRETE STRENGTH OF 4,000 PSI IS RECOMMENDED. CONCRETE SHOULD BE VIBRATED TO ELIMINATE AIR POCKETS.
 3. EXPANSION AND CONTRACTION CONTROL JOINTS AND REINFORCEMENT ARE RECOMMENDED TO PROTECT CHANNEL AND CONCRETE SURROUND.
 4. THE FINISHED LEVEL OF THE CONCRETE SURROUND MUST BE APPROX. 1/8" [3mm] ABOVE THE TOP OF THE CHANNEL EDGE.
 5. CONCRETE BASE THICKNESS SHOULD MATCH SLAB THICKNESS. ENGINEERING ADVICE MAY BE REQUIRED TO DETERMINE PROPER LOAD CLASS.
 6. REFER TO ACO'S LATEST INSTALLATION INSTRUCTIONS FOR FURTHER DETAILS.

DRIVEWAY TRENCH DRAIN DETAIL
N.T.S.

SPECIFICATION CLAUSE

K300 KLASSIKDRAIN - LOAD CLASS A

GENERAL
THE SURFACE DRAINAGE SYSTEM SHALL BE POLYMER CONCRETE K100 CHANNEL SYSTEM WITH GALVANIZED STEEL EDGE RAILS AS MANUFACTURED BY ACO POLYMER PRODUCTS, INC.

MATERIALS
CHANNELS SHALL BE MANUFACTURED FROM POLYESTER RESIN POLYMER CONCRETE WITH AN INTEGRALLY CAST-IN GALVANIZED STEEL EDGE RAIL. MINIMUM PROPERTIES OF POLYMER CONCRETE WILL BE AS FOLLOWS:
COMPRESSIVE STRENGTH: 14,000 PSI
FLEXURAL STRENGTH: 4,000 PSI
TENSILE STRENGTH: 1,500 PSI
WATER ABSORPTION: 0.07%
FROST PROOF: YES
DILUTE ACID AND ALKALI RESISTANT: YES
B117 SALT SPRAY TEST COMPLIANT: YES

THE SYSTEM SHALL BE 4" (100mm) NOMINAL INTERNAL WIDTH WITH A 5.1" (130mm) OVERALL WIDTH AND A BUILT-IN SLOPE OF 0.5%. CHANNEL INVERT SHALL HAVE DEVELOPED "V" SHAPE. ALL CHANNELS SHALL BE INTERLOCKING WITH A MALE/FEMALE JOINT.

THE COMPLETE DRAINAGE SYSTEM SHALL BE BY ACO POLYMER PRODUCTS, INC. ANY DEVIATION OR PARTIAL SYSTEM DESIGN AND/OR IMPROPER INSTALLATION WILL VOID ANY AND ALL WARRANTIES PROVIDED BY ACO POLYMER PRODUCTS, INC.

CHANNEL SHALL WITHSTAND LOADING TO PROPER LOAD CLASS AS OUTLINED BY EN 1433. GRATE TYPE SHALL BE APPROPRIATE TO MEET THE SYSTEM LOAD CLASS SPECIFIED AND INTENDED APPLICATION. GRATES SHALL BE SECURED USING 'QUICKLOK' BOLTLESS LOCKING SYSTEM. CHANNEL AND GRATE SHALL BE CERTIFIED TO MEET THE SPECIFIED EN 1433 LOAD CLASS. THE SYSTEM SHALL BE INSTALLED IN ACCORDANCE WITH THE MANUFACTURER'S INSTRUCTIONS AND RECOMMENDATIONS.





REVISIONS:	DATE:	SCALE: HOR. 1"=10' VER. 1"=1'	DATE: 12/05/17
		DESIGNED BY: NP	JOB: 1702018
		DRAWN BY: DW	VERSION: 1.5
		CHECKED BY: JJ	PLOT DATE: 12/05/17





**PRELIMINARY
GRADING & DRAINAGE PLAN**

**SCHERR RESIDENCE
5416 E DESERT JEWEL DR
PARADISE VALLEY, AZ 85253**

P. 602.889.1984 | F. 602.445.9482
8808 N CENTRAL AVE., SUITE 288
PHOENIX, AZ 85020
PHOENIX @ LDENG.COM

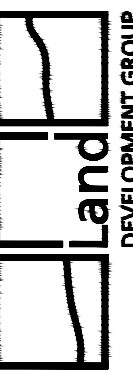

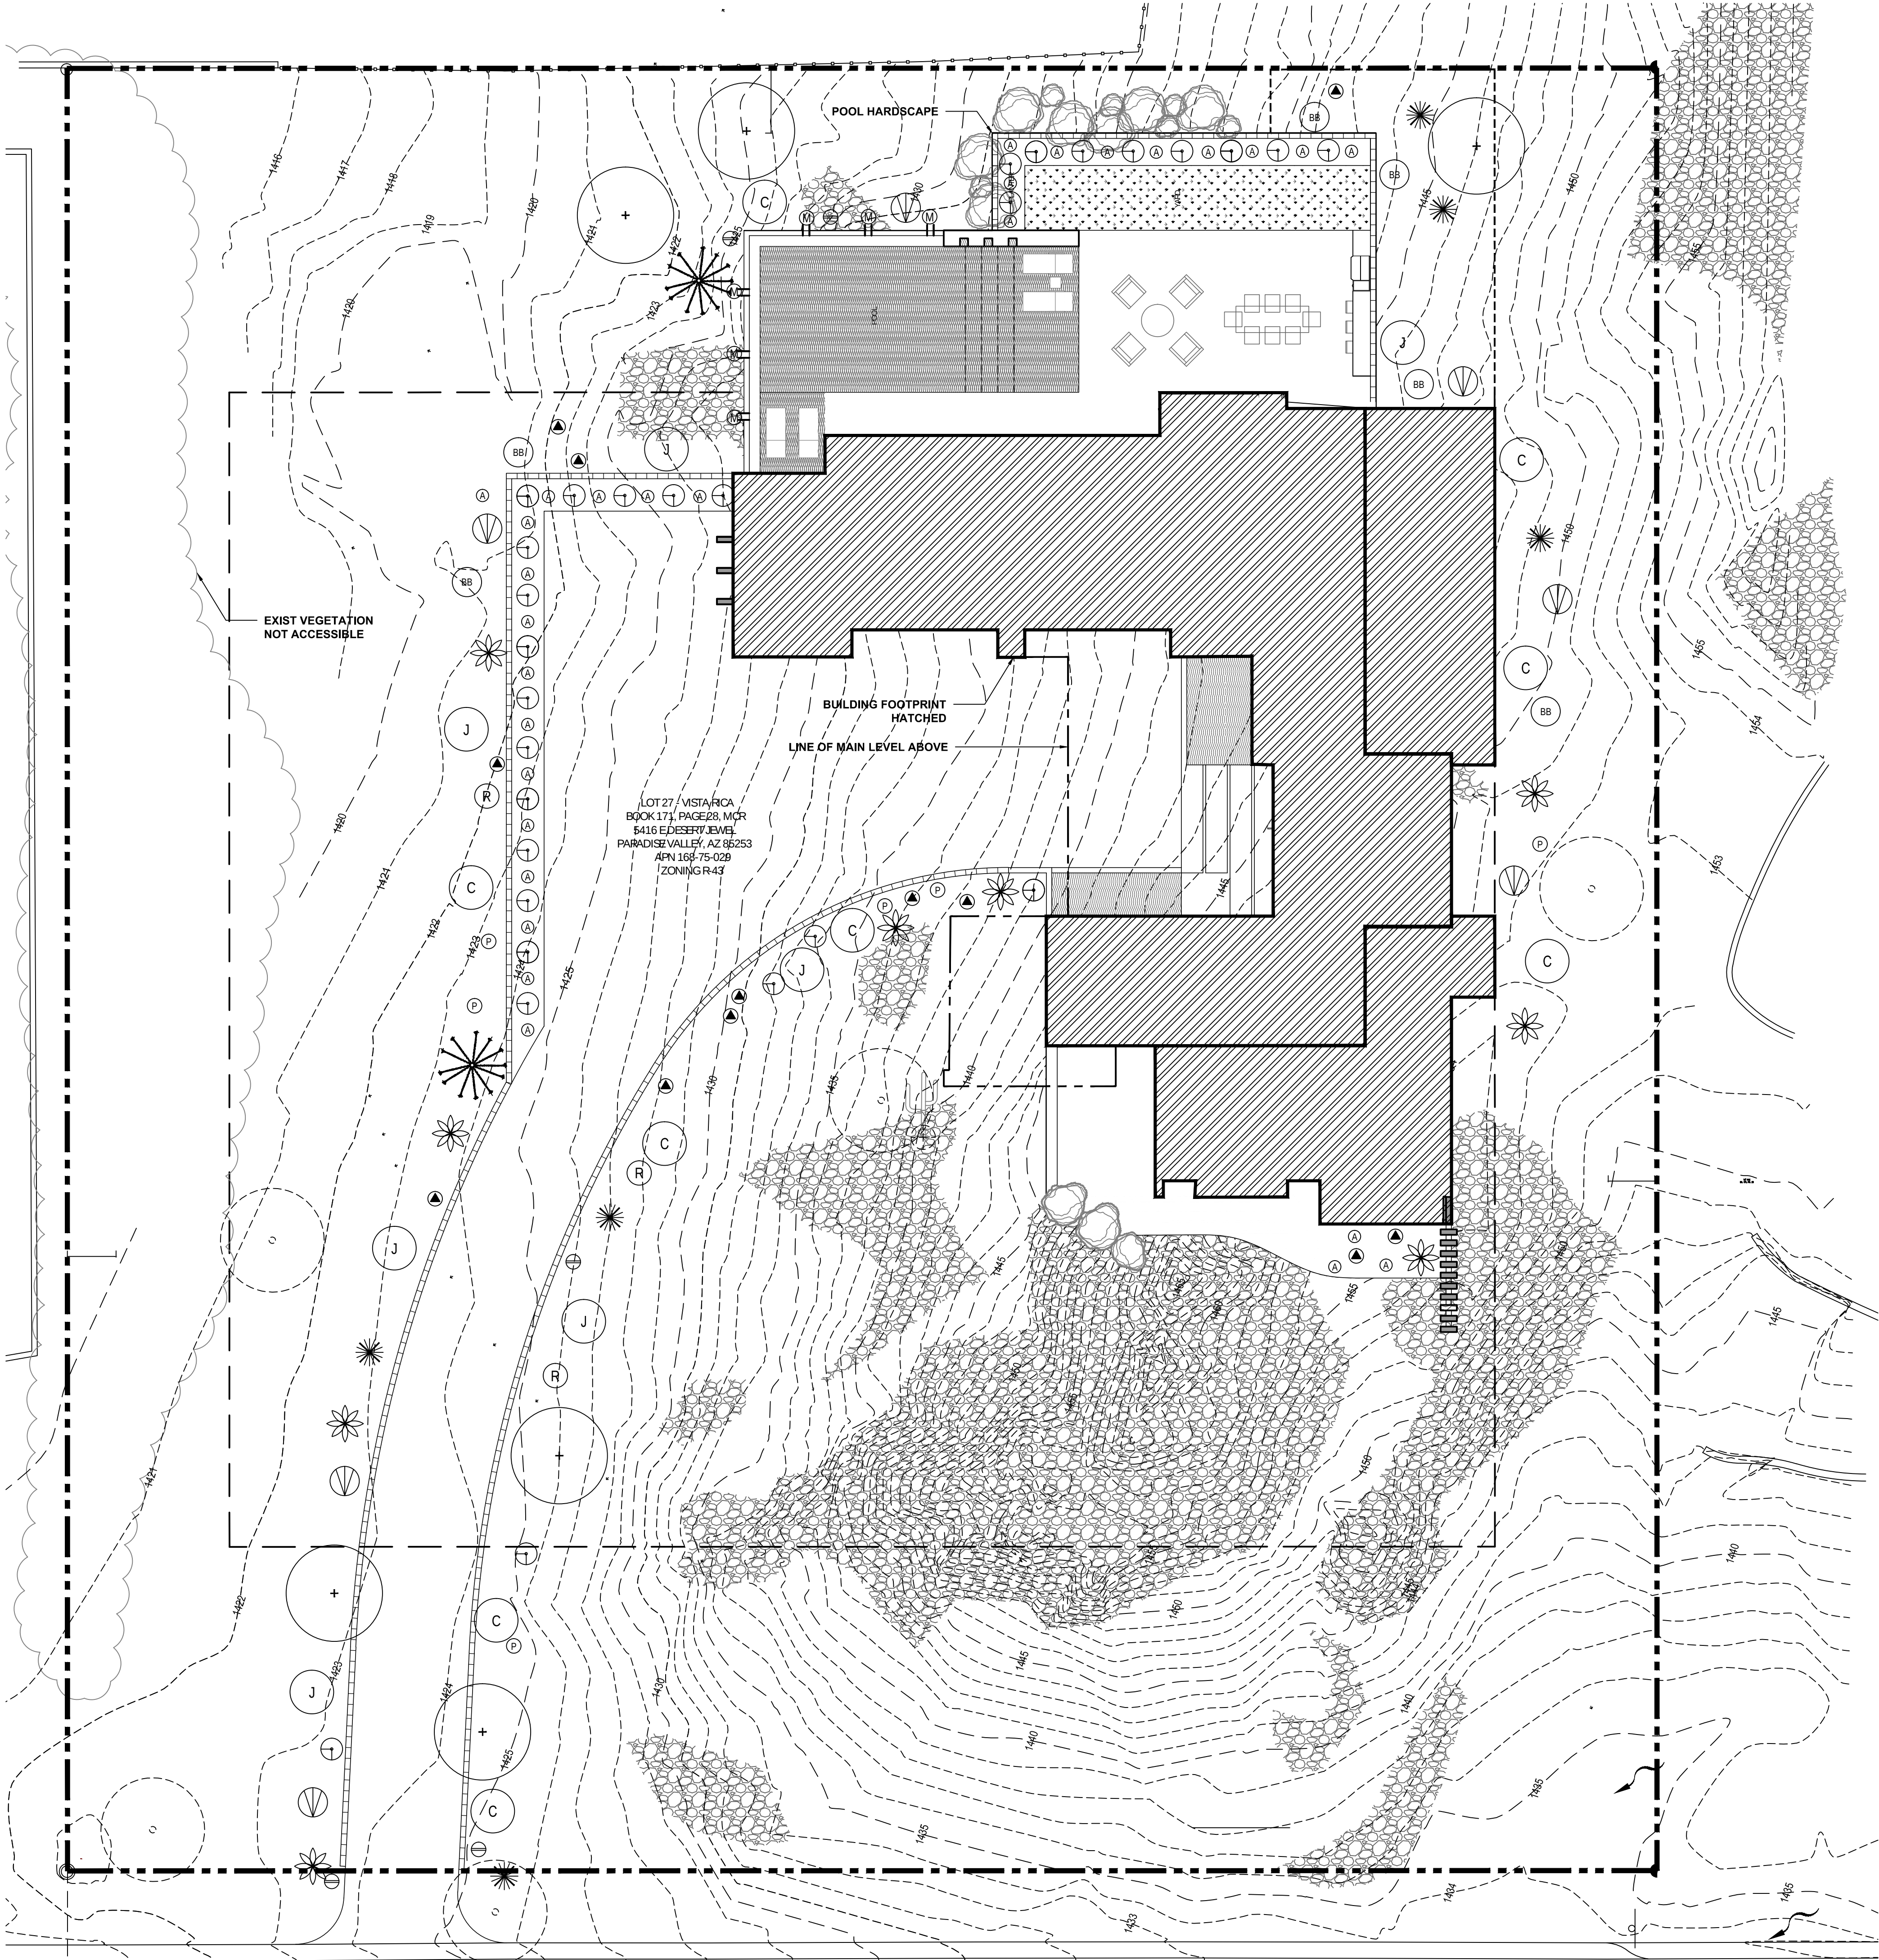

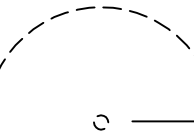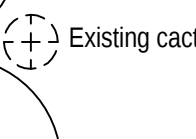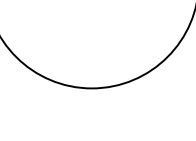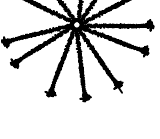PLANT LEGEND				
TREES	BOTANICAL NAME	COMMON NAME	SIZE	TOTAL QTY.
	Existing tree to remain			5
	Existing cactus to remain			1
	Cercidium microphyllum (recoated and salvaged)	Foothills Palo Verde (multi-trunk)		6
SHRUBS				
	Ambrosia deltoidea	Triangleleaf Bursage	1 Gal	12
	Encelia farinosa	Brittlebush	5 Gal	6
	Justicia californica	Chuparosa	5 Gal	6
	Larrea tridentata	Creosote	15 Gal	9
	Simmondsia chinensis	Jojoba	5 Gal	7
ACCENTS				
	Agave victoriae-reginae	Queen Victoria Agave	1 Gal	29
	Dasyliroon wheeleri	Desert Spoon	5 Gal	6
	Euphorbia rigida	Gopher Plant	5 Gal	27
	Fouquieria splendens	Ocotillo	8 cane min.	2
	Muhlenbergia capitaris	Regal Mist	5 Gal	2
	Opuntia imbricata	Tree Cholla	5 Gal	9

** Plant material to be salvaged from the site if possible. Otherwise, obtain new plant material

GROUNDCOVERS				
	Penstemon eatonii	Firecracker Penstemon	1 Gal	5
	Penstemon parryi	Parry's Penstemon	1 Gal	5
VINE				
	Mascagnia macrocarpa	Butterfly vine	1 Gal	6

OTHER				
	Bermuda grass			341 sq. ft.
	Existing Rock Outcropping			
[no symbol]	Decomposed Granite Rock Mulch	color and size TBD		

BOULDERS				
	2' X 2' X 2'			
	3' X 3' X 3'			

Revegetation Seed Mix - to include the following (or sim):


Larrea tridentata	Creosote	18.75%
Encelia farinosa	Brittlebush	19%
Baileya multiradiata	Desert Marigold	12.5%
Cassia covesii	Desert Senna	12.5%
Sphaeralcea ambigua	Desert Globemallow	12.5%
Bouteloua aristoides	Needle Gramma	6.25%

- Seed Mix Application Method
Seed Mix to be applied to all disturbed landscape on site
1. Rip or scarify all areas to be seeded to a minimum depth of 4".
 2. Cover all areas that have excessive amounts of hard granite (hardpan) or alkaline soil with a minimum of 6" of friable topsoil after ripping.
 3. Broadcast seed mix at the rates described above in a uniform manner, ensuring that all areas are evenly covered; either mechanical or hand broadcasting methods are acceptable.
 4. Hydroseeding is not an approved method for applying revegetation seed mix.
 5. Mechanically drag or rake all seeded areas after all seed is uniformly applied. Ideally, this should happen after the boxed plant material is installed and before the small containerized plants are installed.
 6. No supplemental irrigation to the seed mix application is required.

NATIVE PLANT PRESERVATION NOTES

1. Native plant inventory has been performed
2. A native plant preservation plan will be submitted at the time of building and/or demo permit
3. Existing native trees and cacti outside of disturbance limit shall be protected in place
4. Existing native trees that fall inside the disturbance limit that are deemed salvageable will be re-planted on site, non-salvaged will be removed
5. Existing cacti that fall inside the disturbance limit that are deemed salvageable will be re-planted on site, non-salvaged will be removed

 LANDSCAPE PLAN



Scherr Residence

5416 E Desert Jewel Drive,
Paradise Valley, AZ
85253

All drawings and written material appearing herein constitute the original and unpublished work of Kendle Design Collaborative. Any duplication or reproduction of these documents or any portion herein without the expressed written permission from Kendle Design Collaborative is prohibited by law.

6		
4		
3		
2		
1		
MARK	DATE	DESCRIPTION

ISSUE 12/5/17 - FORMAL REVIEW

PROJECT NO:

CAD DWG FILE

DRAWN BY: CK, RMH

CHECKED BY: BK

SHEET TITLE


LANDSCAPE PLAN

L-1.0

BUILDING LIGHTING FIXTURE SCHEDULE

TYPE	QTY	MFR	DESCRIPTION	LUMENS	WATTAGE
1	7	EUROFASE	In-Ground Drive Over Well Light	<80	1W LED
2	2	SPJ Lighting	Submersible Linear LED System	<120	4.4W LED
3	20	SOLLOS	Hat Path Light	<250	2.3W LED
4	8	SOLLOS	Adjustable LED Bullet Fixture	<200	2.5W LED

ALLOWABLE NUMBER OF UPLIGHTS = 8 MAX. (ONE LIGHT PER 1,000
ALLOWABLE DISTURBED AREA AT 8,116 S.F./1000= 8 UPLIGHTS)

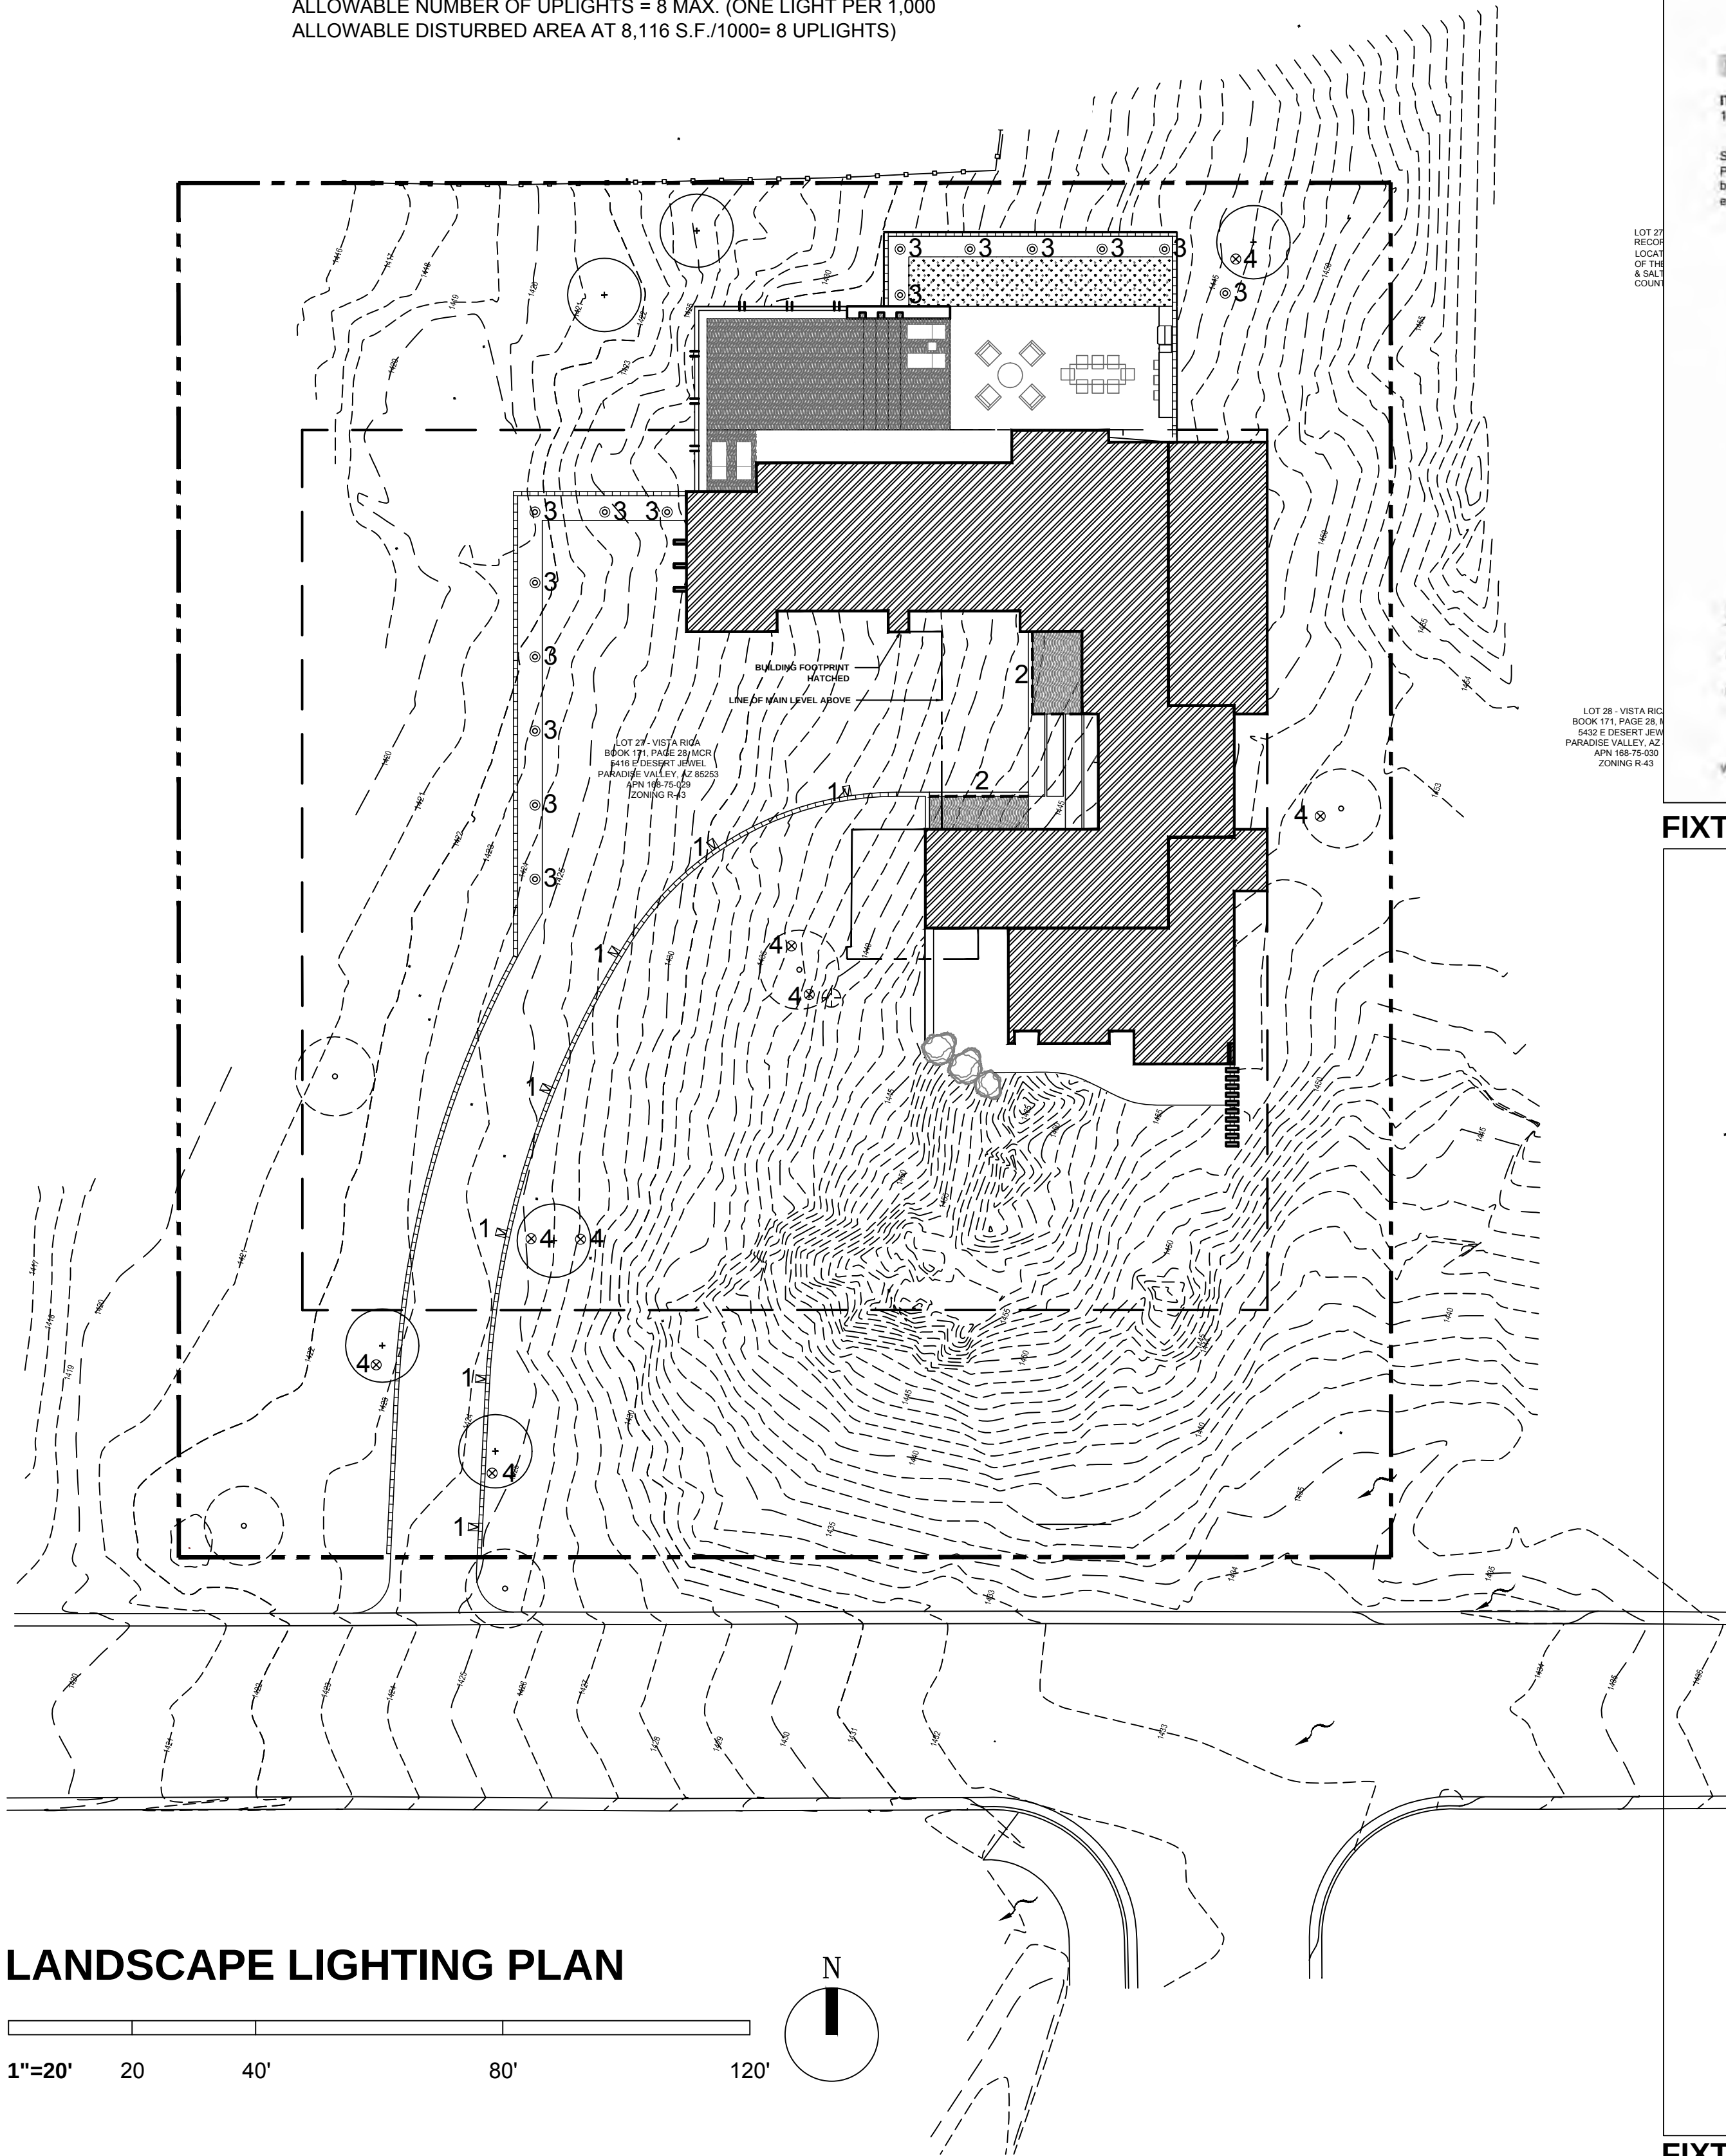

TEL 905.695.2055 FAX 905.695.2056

toll free 1.800.660.5391 toll free 1.800.660.5390

33 West Beaver Creek Road Richmond Hill, Ontario Canada L4B 1L8

14750, INGROUND.OSRAM LED,1X1W,BLACK

Product Details

Item No. 14750-014
Finish Black
Shade Black
Diameter 4.25"
Height 3.25"
Max Extension 0.75"
Est. Weight 1.98 lbs
IP Rating 67
Approval cETLus

BULB DETAILS

No. of Bulbs 1
Bulb Type LED
Bulb Voltage 120V
Bulb Wattage 1W
Bulb Socket LED
Input Voltage 120V
Dimmable No
Lumens 80lm
Kelvin 3000K
CRI 80+
Bulb Included Yes

TECHNICAL DETAILS

Driver Electronic Driver 120v 50/60hz
Cut Hole 4.25"

Options Available

ITEM NO.	FINISH	SHADE
14750-014	Black	Black

Single direction marker light. 120V input, built in driver. Polycarbonate lens. Powder coat finishing. Cast aluminum metal body. Polycarbonate mounting housing included. Long life, energy efficient, low maintenance LED technology.

PROJECT INFORMATION

Job Name: _____ Date: _____ Type: _____

Comments: _____

www.eurofase.com

FIXTURE TYPE: 1

PSH040
4" Straight Hat Path Light
Architectural Aluminum

Fixture Ordering Guide

Product Code	Finish	Stem
PSH040	TB - Textured Black	12"
	TZ - Textured Bronze	15"
		18"

JC20 Halogen lamp shipped with fixture. To substitute a ProLED® lamp, add lamp product code.
Example: PSH040-TB-15-JC20/2WW/LED

Housing:

- Aluminum construction
- Underside of 4" diameter hat is coated with white reflective paint for optimum output and diffusion
- Stepped, threaded collar for tool-less attachment facilitates easy relamping
- Clear 4mm thick lens protects the lamp

Stem:

- 7/8" diameter stem provides solid, stable mounting

Finish:

- Textured Black or Textured Bronze
- UV resistant powder coat protects the finish from salt-spray induced corrosion

Socket:

- Ceramic G4 bi-pin socket
- Heat-resistant wire leads

Lamp:

- T3-G4 bi-pin – 20W maximum
- ProLED® JC lamps provide up-to 40,000 hour rated life, 10-18V input voltage range and 3000K, amber, blue, green and red color options
- ProLED® IP65 Rated JC lamps are rated for use outdoors where exposed directly water from rain or irrigation

Mounting:

- 8" black ground stake included

Electrical:

- 12 Volt system
- Pre-wired with 36", 18-2 lead wire
- Two King® DryConn™ waterproof connectors included

Certifications:

- ETL Listed to UL Standard 1838 and CSA C22.2 No. 250.7

Warranty:

- Backed by a lifetime limited warranty to be free from defects in material and/or workmanship
- ProLED® IP65 Rated JC lamps installed in Sollos fixtures per installation instructions are backed by a 20-year limited warranty

Photometrics:

Product: _____

Type: _____

Project: _____

With 12" stem 14.4"
With 15" stem 17.4"
With 18" stem 20.4"

FIXTURE TYPE: 3

10 YEAR WARRANTY

SPECIFICATION FEATURES

Model: **SPJ-FLEX-STRIP**

SPJ-Flex-Strip series is a high performance LED strip designed to replace neon lighting for a smooth or continuous line of light. SPJ-Flex-Strip flexibility allows the light source to bend around various contours, curves and radiuses without being damaged. Also available in IP68 underwater series. Please consult factory for more info.

DESCRIPTION

Model#: SPJ-FLEX-STRIP
Material: PVC
Electrical: 24DC
Wattage: 4.4 Watts per FT
Lumen Range: 120 lumens
Color Temp: 2700K
Beam Angle: 120°
Max Run: 32 FL (64 FL loop)
Dimmable: Yes
Rated Life: 50,000 hours
Operating Temp.: -4° ~ 122°F
Bend Radius: 2.8"
IP65 Wet Location or IP68 Underwater / Submersible

ORDERING INFORMATION

Model#	Finishes	Wattage	Lumen Range	Color Temp.	Electrical
SPJ-FLEX-STRIP	W	4.4/FT	120	2700K	24DC

2700K: RESW
3000K: RED
3500K: PINK
4000K: BLUE
5000K: GREEN
AMBER
YELLOW

WWW.SPJLIGHTING.COM

Wet Listed

PVC Channel PVC-39

Aluminum Cup AC2

FIXTURE TYPE: 2

BSB060
Straight Bullet
Architectural Aluminum

Fixture Ordering Guide

Product Code	Finish
BSB060	TB - Textured Black
	TZ - Textured Bronze

Order Lamp Separately
Example: BSB060-TZ-MR16BAB/827/LED

Product: _____

Type: _____

Project: _____

Shroud:

- Textured Black or Textured Bronze
- UV resistant powder coat protects the finish from salt-spray induced corrosion
- Brass slotted thumb screw for easy, tool-free lamp replacement

Housing:

- Architectural-grade die cast aluminum base, knuckle and shroud
- Fully adjustable swivel arm with locking teeth maintains desired angles
- Two silicone o-rings provide a low-friction, watertight seal
- Gasketed knuckle to prevent water intrusion

Lens:

- Shock and heat-resistant clear, tempered glass

Socket:

- Ceramic GU5.3 bi-pin socket
- Stainless steel retention clip ensures secure lamp seating and protects the lamp from shock and vibration
- Heat-resistant wire leads

Lamp:

- MR16 – 50W maximum
- ProLED® MR16 lamps offer 40,000 hour rated life, 10-15V input voltage range, multiple beam spreads (flood, narrow flood, spot and wide flood) and 2700K, amber, blue, green, red and color changing options

Photometrics:

Product: _____

Type: _____

Project: _____

FIXTURE TYPE: 4

KENDLE DESIGN
COLLABORATIVE

6115 NORTH CATTLETRACK
SCOTTSDALE, ARIZONA 85250
PH 480.951.8558
BRENT@KENDLEDESIGN.COM
KENDLEDESIGN.COM

Scherr
Residence

5416 E. Desert Jewel Drive,
Paradise Valley, AZ
85253

All drawings and written material appearing herein constitute the original and unpublished work of Kendle Design Collaborative. Any duplication or reproduction of these documents or any portion herein without the expressed written permission from Kendle Design Collaborative is prohibited by law.

5		
4		
3		
2		
1		
MARK	DATE	DESCRIPTION

ISSUE: 12/5/17 - FORMAL REVIEW

PROJECT NO:

CAD DWG FILE:


DRAWN BY: CK, RVH

CHECKED BY: BK

SHEET TITLE:

LANDSCAPE
LIGHTING PLAN

L-2.0

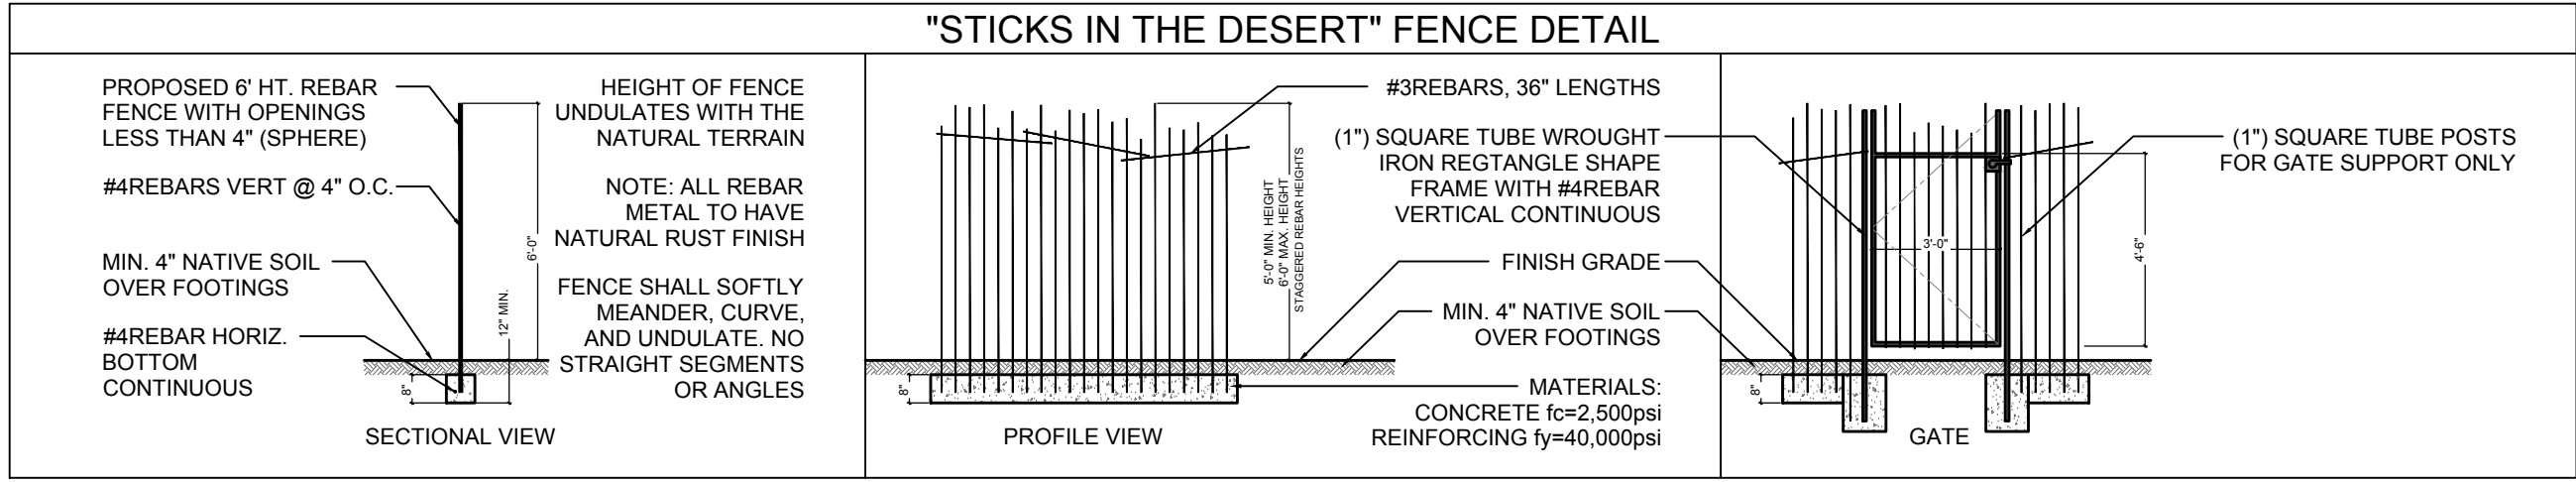

LOT 25 - VISTA RICA
BOOK 171, PAGE 28, MCR
8015 N 54TH ST
PARADISE VALLEY, AZ 85253
APN 188-75-027
ZONING R-43

LOT 27 - VISTA RICA, A SUBDIVISION PLAT
RECORDED IN BOOK 171 OF MAPS, PAGE 28, MCR,
LOCATED IN A PORTION OF THE SE 1/4 OF THE SW 1/4
OF THE S1/2 OF SECTION 32, T.30N, R.4E OF THE GILA
& SALT RIVER BASE AND MERIDIAN, MARICOPA
COUNTY, ARIZONA

LOT 28 - VISTA RICA
BOOK 171, PAGE 28, MCR
8432 E DESERT JEWEL
PARADISE VALLEY, AZ 85253
APN 188-75-030
ZONING R-43



LOT 26 - VISTA RICA
BOOK 171, PAGE 28, MCR
8400 E DESERT JEWEL
PARADISE VALLEY, AZ 85253
APN 188-75-028
ZONING R-43

LOT 27 - VISTA RICA
BOOK 171, PAGE 28, MCR
8418 E DESERT JEWEL
PARADISE VALLEY, AZ 85253
APN 188-75-029
ZONING R-43

DESERT JEWEL DRIVE

SITE PLAN

1"=16' 16" 32" 64' 96'

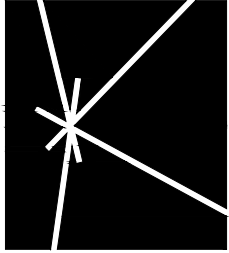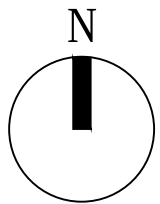

KENDLE DESIGN
COLLABORATIVE

6115 NORTH CATTLETRACK
SCOTTSDALE, ARIZONA 85250
PH 480.951.8558
BRENT@KENDLEDESIGN.COM
KENDLEDESIGN.COM

Scherr
Residence

5416 E. Desert Jewel Drive,
Paradise Valley, AZ
85253

All drawings and written material appearing
herein constitute the original and unpublished
work of Kendle Design Collaborative. Any
duplication or reproduction of these documents
or any portion herein without the expressed
written permission from Kendle Design
Collaborative is prohibited by law.

5		
4		
3		
2		
1		
MARK	DATE	DESCRIPTION

ISSUE: 12/5/17 - FORMAL REVIEW

PROJECT NO:

CAD DWG FILE:

DRAWN BY: CK, RVH

CHECKED BY: BK

SHEET TITLE:

SITE PLAN

A-1.0



IMAGE 1



IMAGE 2



IMAGE 3



IMAGE 4



IMAGE 5



IMAGE 6



IMAGE 7



IMAGE 8



IMAGE 9



IMAGE 10



IMAGE 11



IMAGE 12




IMAGE 13



IMAGE 14



IMAGE 15

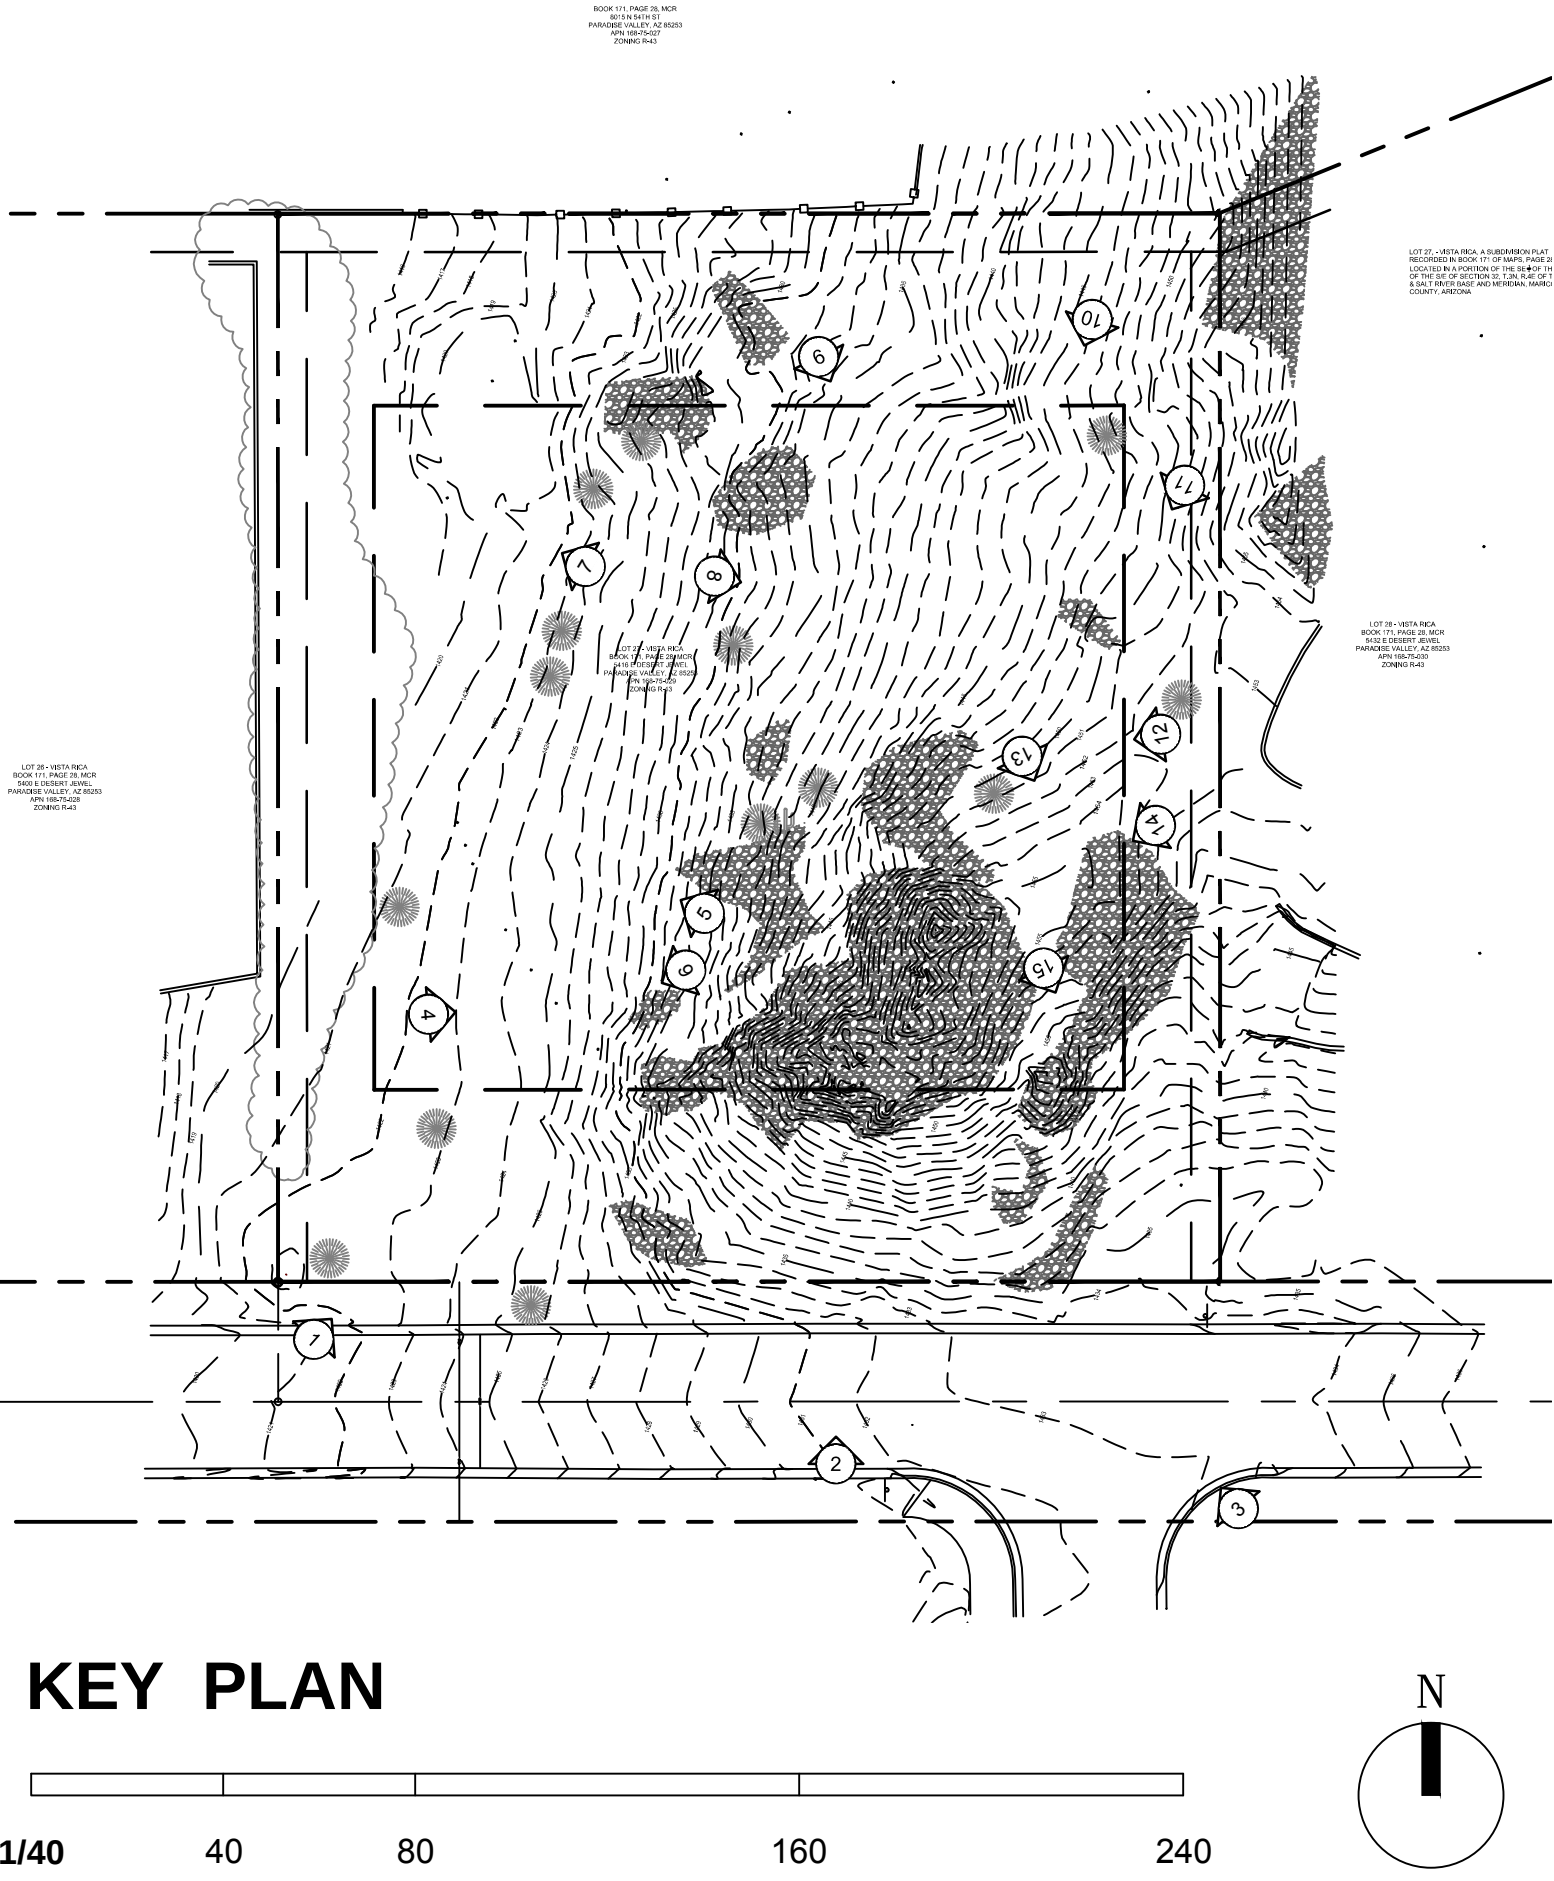

RENDERING

NTS

Scherr
Residence

5416 E. Desert Jewel Drive,
Paradise Valley, AZ
85253

All drawings and written material appearing herein constitute the original and unpublished work of Kendle Design Collaborative. Any duplication or reproduction of these documents or any portion herein without the expressed written permission from Kendle Design Collaborative is prohibited by law.

5		
4		
3		
2		
1		
MARK	DATE	DESCRIPTION

ISSUE: 12/5/17 - FORMAL REVIEW

PROJECT NO:
CAD DWG FILE:

DRAWN BY: CK, RVH
CHECKED BY: BK


SHEET TITLE:

RENDERING &
SITE PHOTOS



A-2.0

BUILDING LIGHTING FIXTURE SCHEDULE



TYPE	QTY	MFR	DESCRIPTION	LUMENS	WATTAGE
4	3	SOLLOS	ADJUSTABLE LED BULLET	<200 LM	2.5W
5	2	HEVILITE	ADJUSTABLE MINI IN-GRADE WELL FIXTURE LED	<146 LM	3W OR 8W
6	2	CSL	LED STEPLIGHT, BRONZE SERIES SS3008-BZ	<120 LM	3 W
7	26	NORA LIGHTING	LED DOWN LIGHT 2"	<750LM	13-14 W

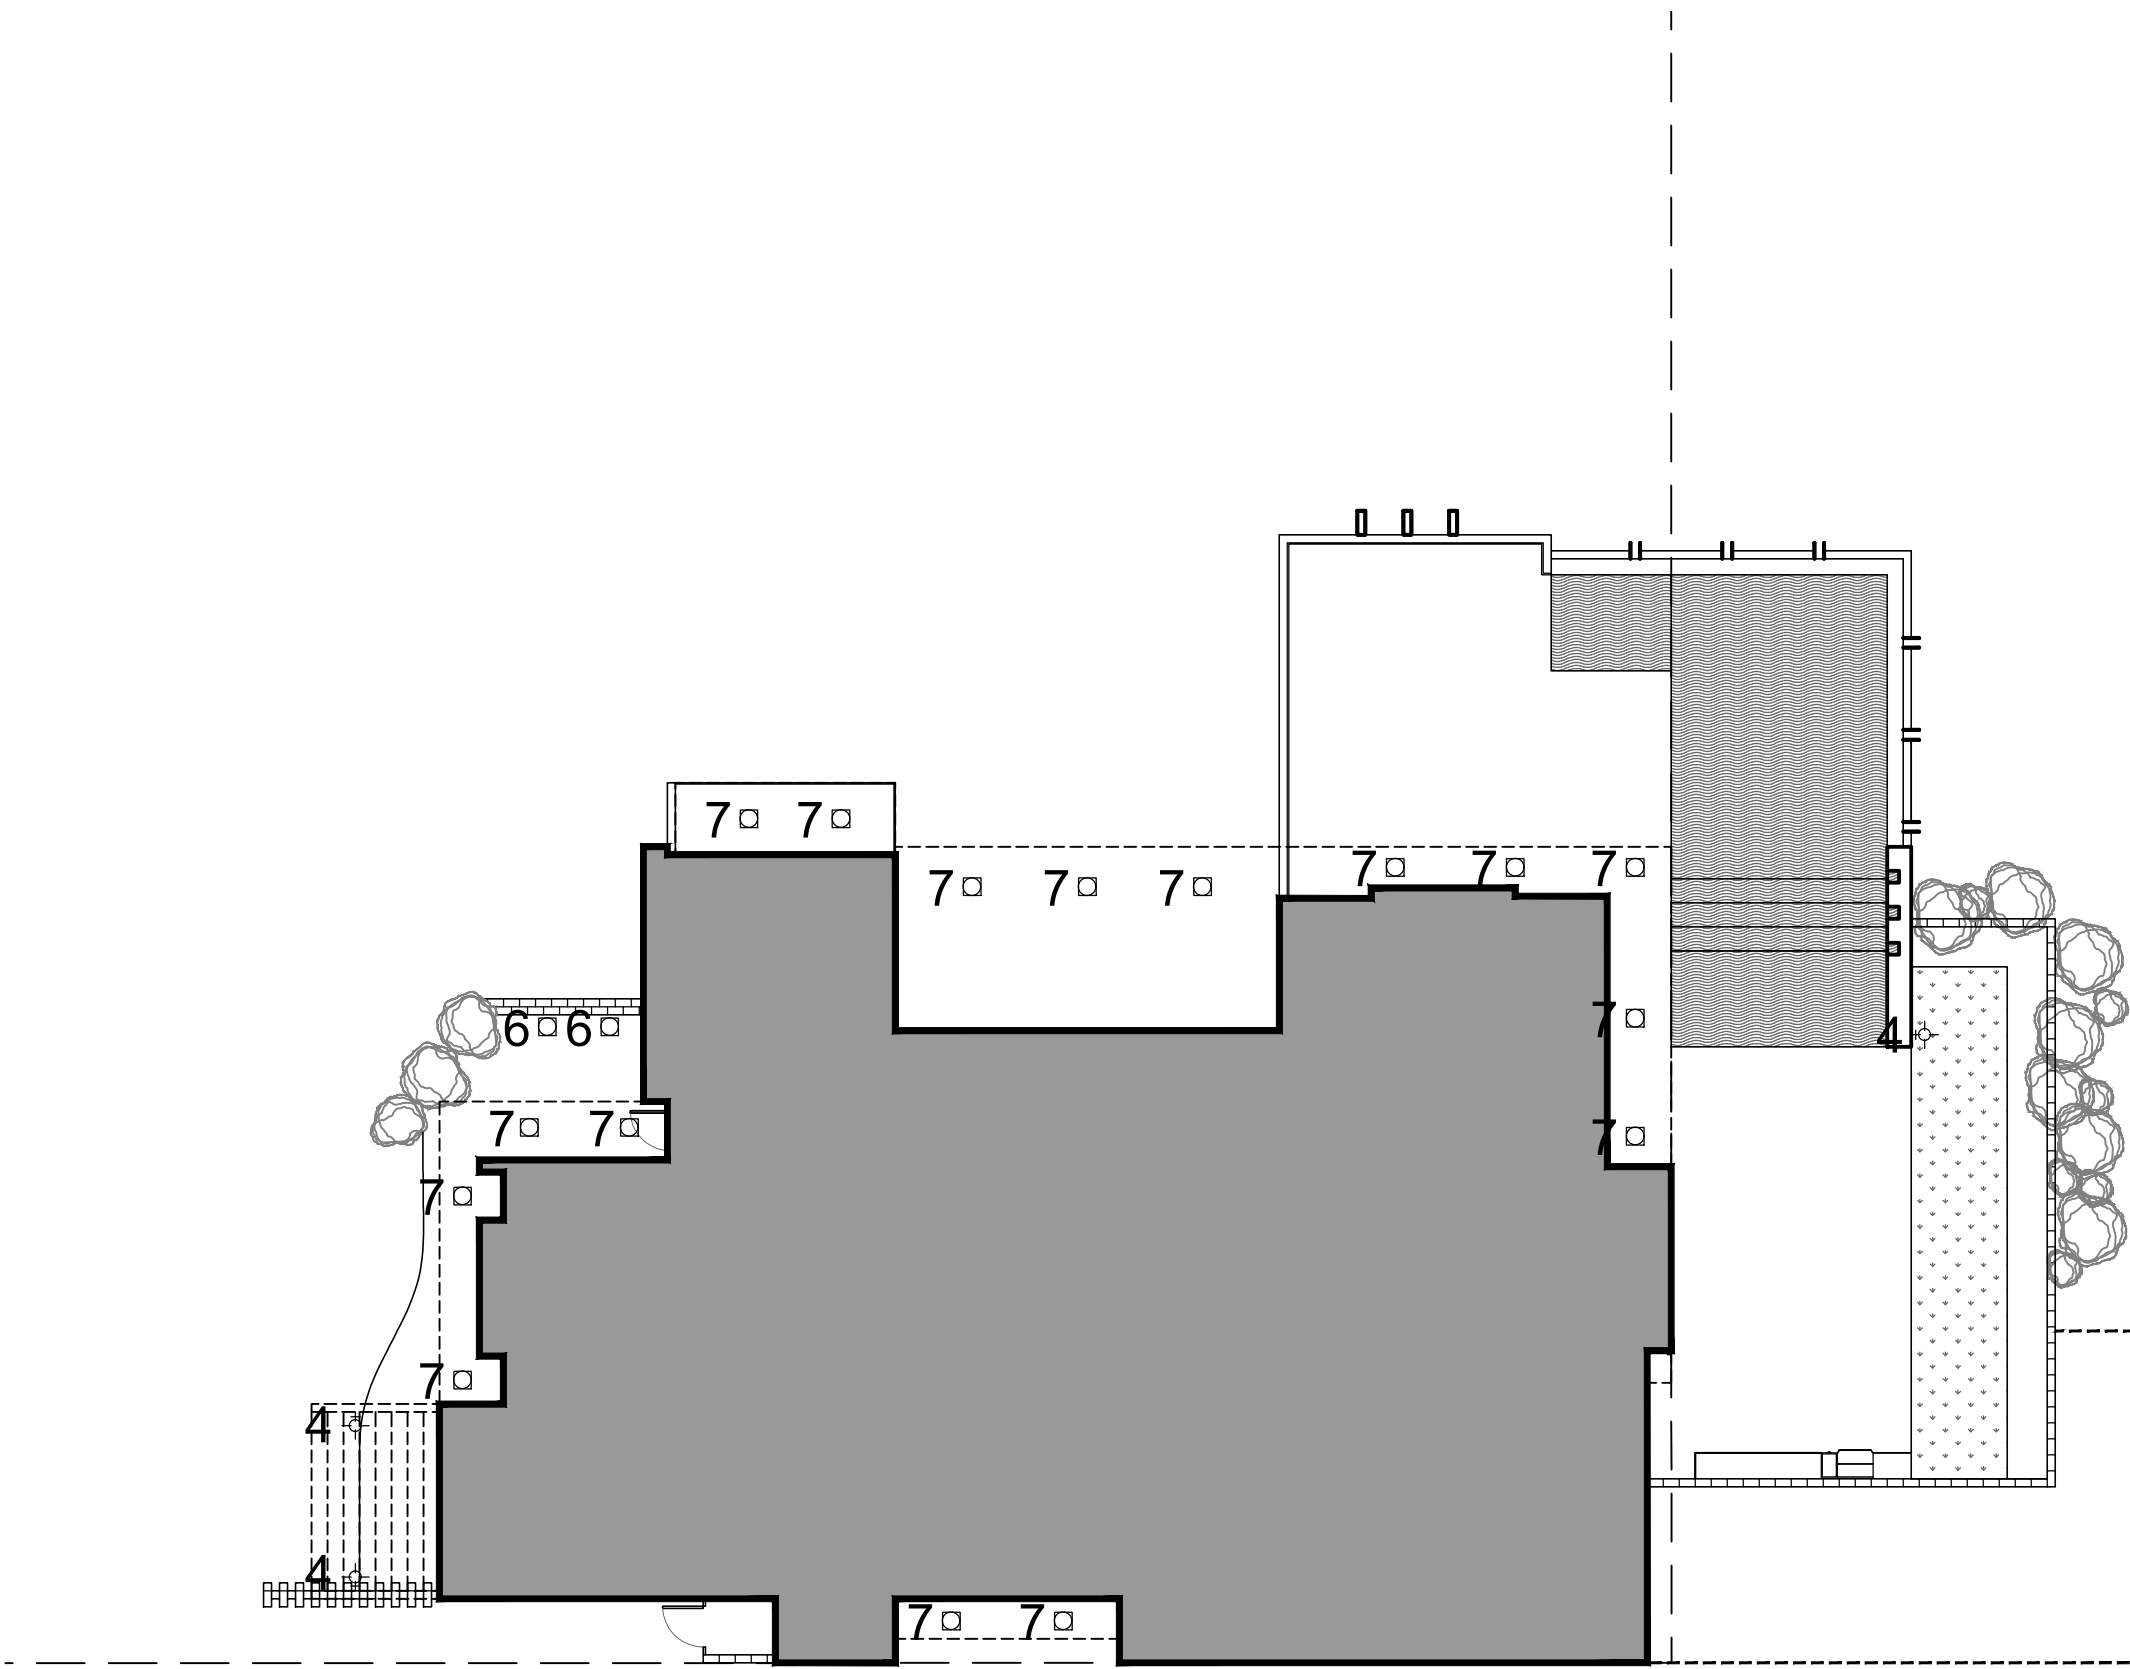

EXTERIOR LIGHTING - MAIN LEVEL PLAN

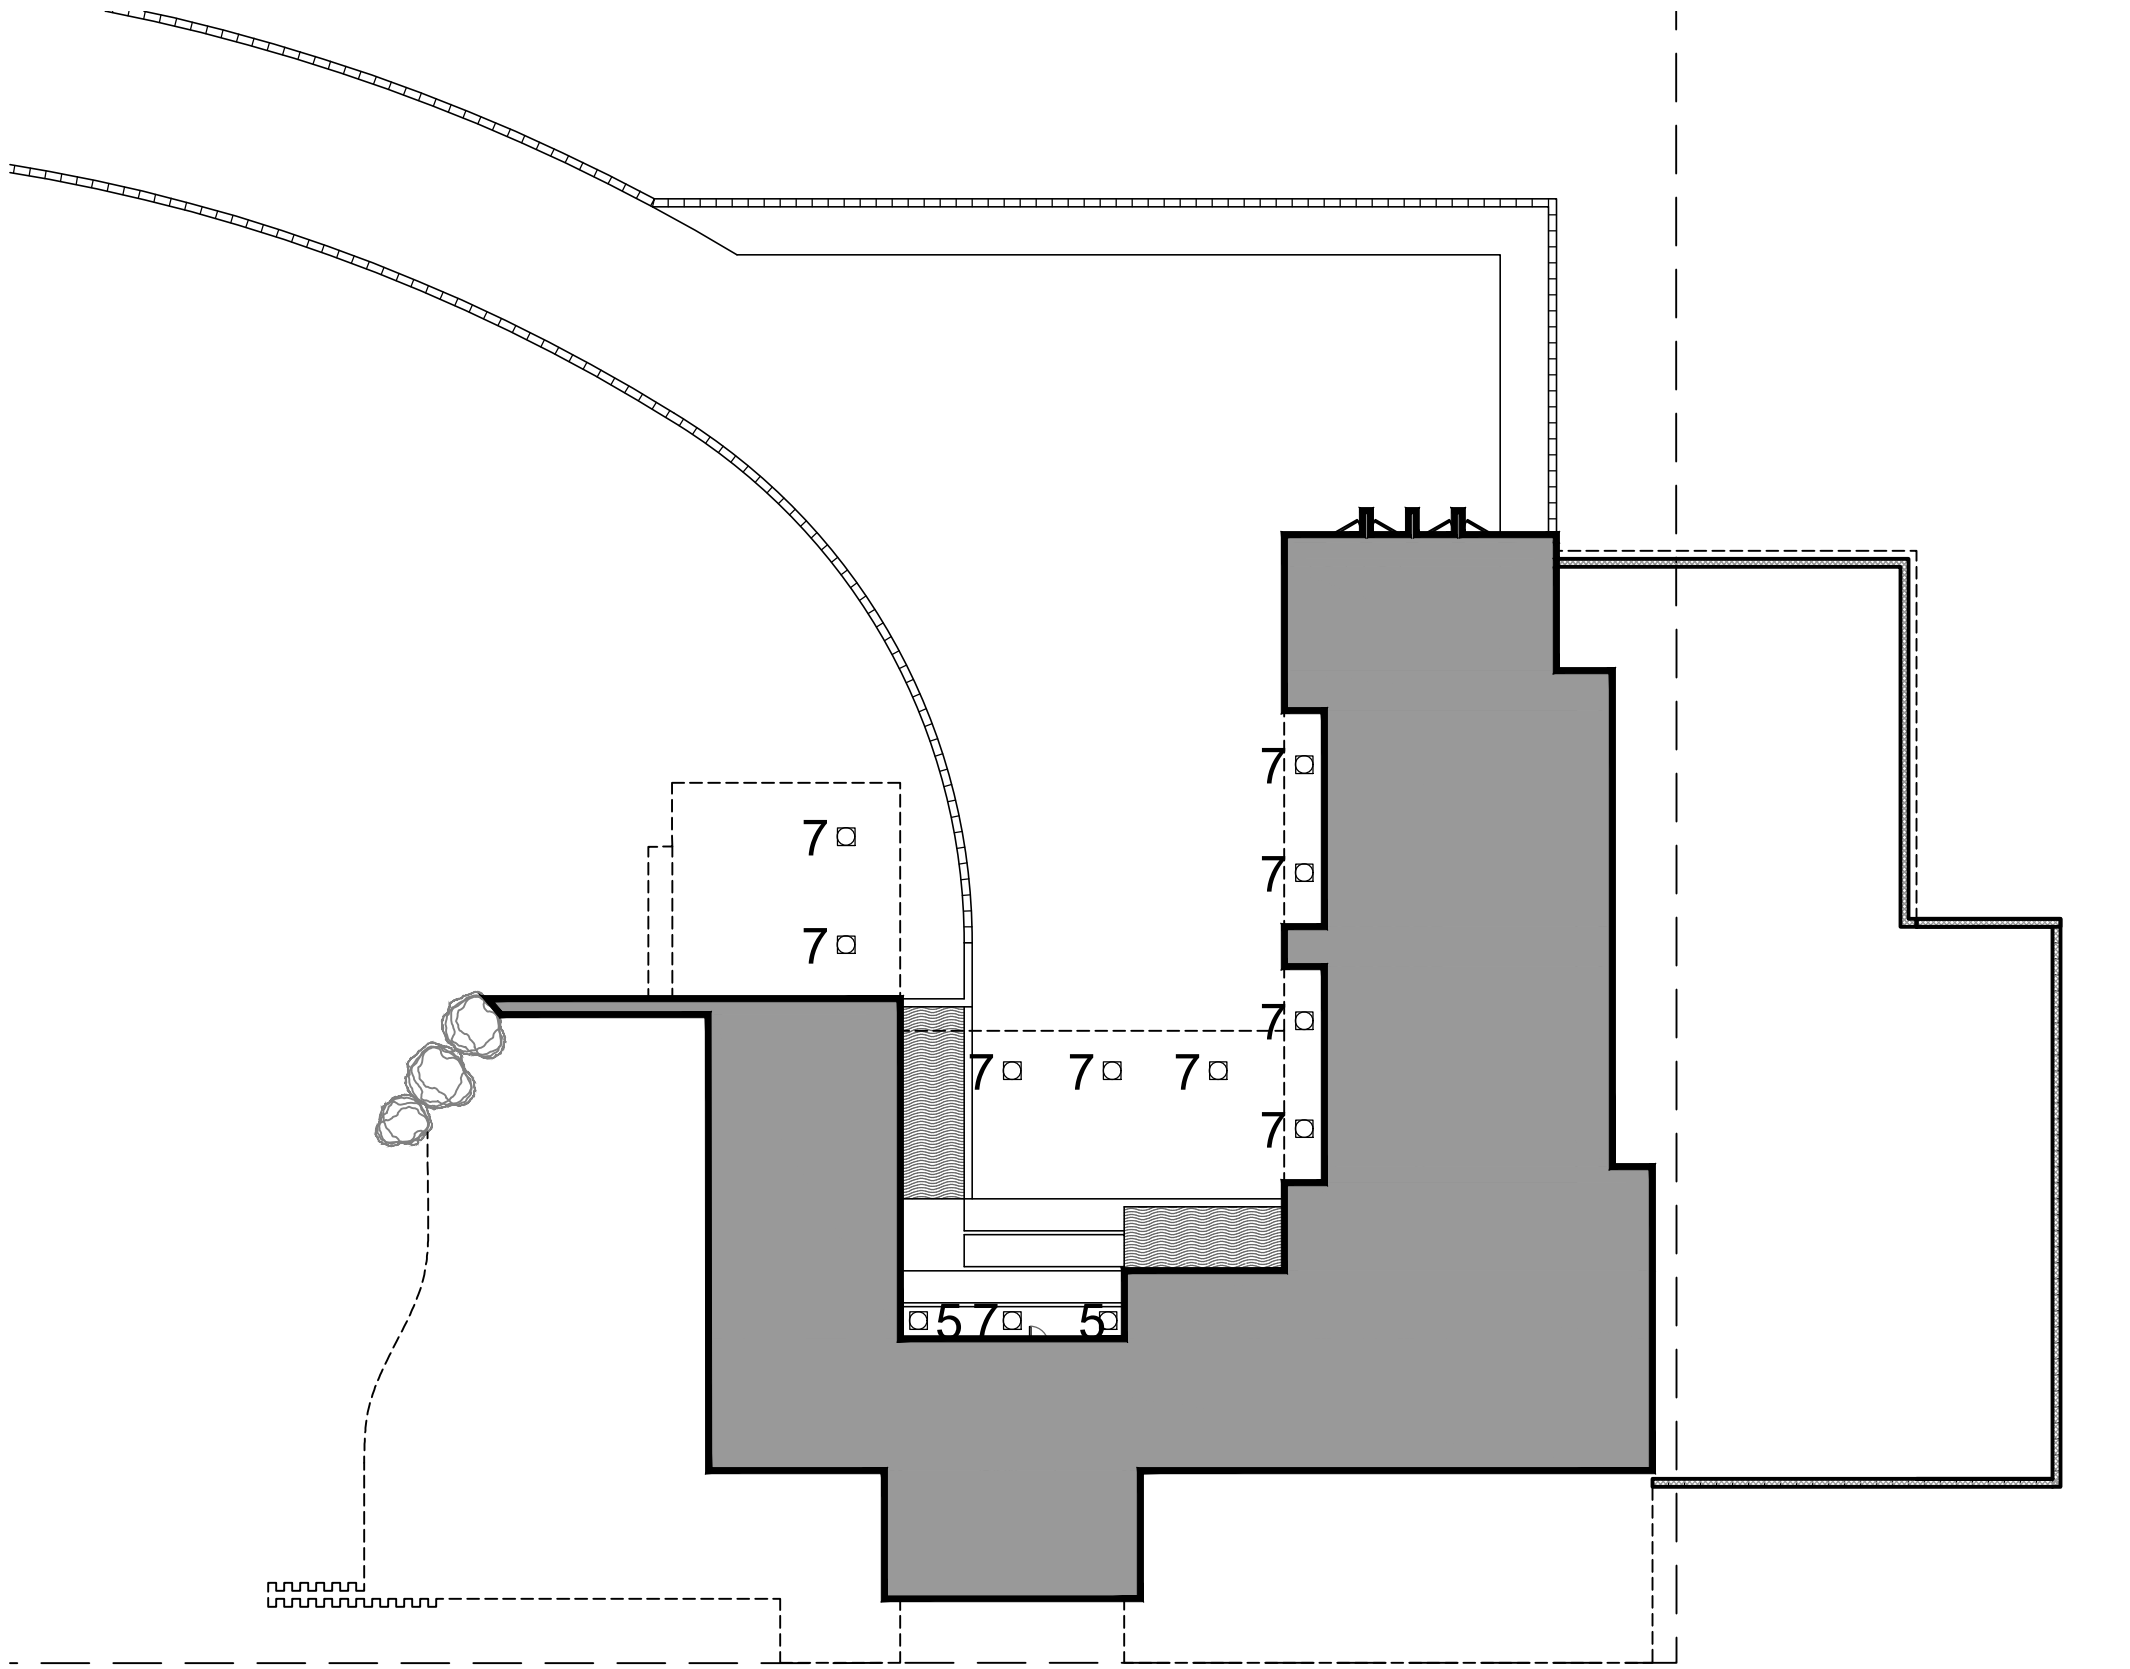 

EXTERIOR LIGHTING - LOWER LEVEL PLAN

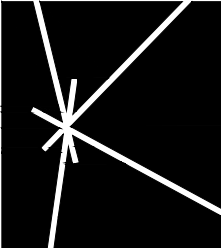 

KENDLE DESIGN
COLLABORATIVE
6115 NORTH CATTLETRACK
SCOTTSDALE, ARIZONA 85250
PH 480.951.8558
BRENT@KENDLEDESIGN.COM
KENDLEDESIGN.COM

Scherr
Residence

5416 E. Desert Jewel Drive,
Paradise Valley, AZ
85253

sollos.
LANDSCAPE LIGHTING

BSB060
Straight Bullet
Architectural Aluminum

Fixture Ordering Guide

Product Code	Finish
BSB060	TB - Textured Black
	TZ - Textured Bronze

Order Lamp Separately
Example: BSB060-TZ-MR16AB/827/LED



- Shroud:**
- Textured Black or Textured Bronze
 - UV resistant powder coat protects the finish from salt-spray induced corrosion
 - Brass slotted thumb screw for easy, tool-free lamp replacement

- Housing:**
- Architectural-grade die cast aluminum base, knuckle and shroud
 - Fully adjustable swivel arm with locking teeth maintains desired angles
 - Two silicone o-rings provide a low-friction, watertight seal
 - Gasketed knuckle to prevent water intrusion


- Lens:**
- Shock and heat-resistant clear, tempered glass

- Socket:**
- Ceramic GU5.3 bi-pin socket
 - Stainless steel retention clip ensures secure lamp seating and protects the lamp from shock and vibration
 - Heat-resistant wire leads

- Lamp:**
- MR16 - 50W maximum
 - ProLED® MR16 lamps offer 40,000 hour rated life, 10-15V input voltage range, multiple beam spreads (flood, narrow flood, spot and wide flood) and 2700K, amber, blue, green, red and color changing options

- Mounting:**
- 8" black ground stake included
- Electrical:**
- 12 Volt system
 - Pre-wired with 36", 18-2 lead wire
 - Two King® DryConn™ waterproof connectors included
- Certifications:**
- ETL Listed to UL Standard 1838 and CSA C22.2 No. 250.7
- Fasteners:**
- All fasteners are corrosion-resistant stainless steel
- Warranty:**
- Backed by a 5-year limited warranty to be free from defects in material and/or workmanship
 - ProLED® MR16 lamps installed in Sollos fixtures per installation instructions are backed by a 20-year limited warranty

Photometrics:

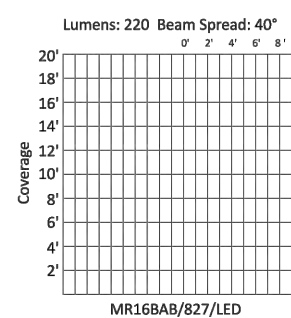

Sollos Landscape Lighting | 2940 Pacific Drive, Norcross GA 30071 | Toll Free 888.976.5567 (888.Sollos) | Toll Free Fax 888.576.5567 (888.Sollos) | solloslighting.com
©2014 Sollos Landscape Lighting. All sizes and specifications are subject to change. All rights reserved. All product names are trademarks or registered trademarks of Sollos Landscape Lighting. Sollos Landscape Lighting is a Halo Lighting Technologies Company. Online Edition 02/05/14.

SPECIFICATIONS

DESCRIPTION:
Compact LED recessed in-grade fixture with adjustable light source. Suitable for wet/damp location installations.

MATERIAL:
Standard overall material is 6061 aluminum.

FINISH:
AA - Anodized Satin Aluminum
AP - Powder Coat Aluminum
BK - Powder Coat Black
BZ - Powder Coat Bronze
WT - Powder Coat White

LED OPTIONS:
Integral high output LED, warm white (3000K CCT) standard, others available.
SLED - 3W LED
BLED - 8W LED
Options:
SP - Spot, 12°
NF - Narrow Flood, 24°
FL - Flood, 36°

VOLTAGE:
12 - 12 VAC output transformer required, not included.

MOUNTING:
Suitable for installation into concrete, masonry, or any non-combustible material

OPTIONS:
Lenses/Louvers/Color Filters
LA-1 - Hexcell Louver (Black)
LA-2 - Prismatic lens
LA-3 - Linear spread lens
LA-4 - Soft focus lens (diffused)
LA-5 - Moonlight lens
LA-6 - Blue lens


Other:
LA-820 - Lens and lower holder
Four housing
HL-20PH - Aluminum
See fixture accessories for more information.

SAMPLE ORDER SPECIFICATION:
HL-822-SLED-NF-12-LA-LA-LA-820-HL-20PH

RATING:
Wet/damp location - IP67



MADE IN THE USA

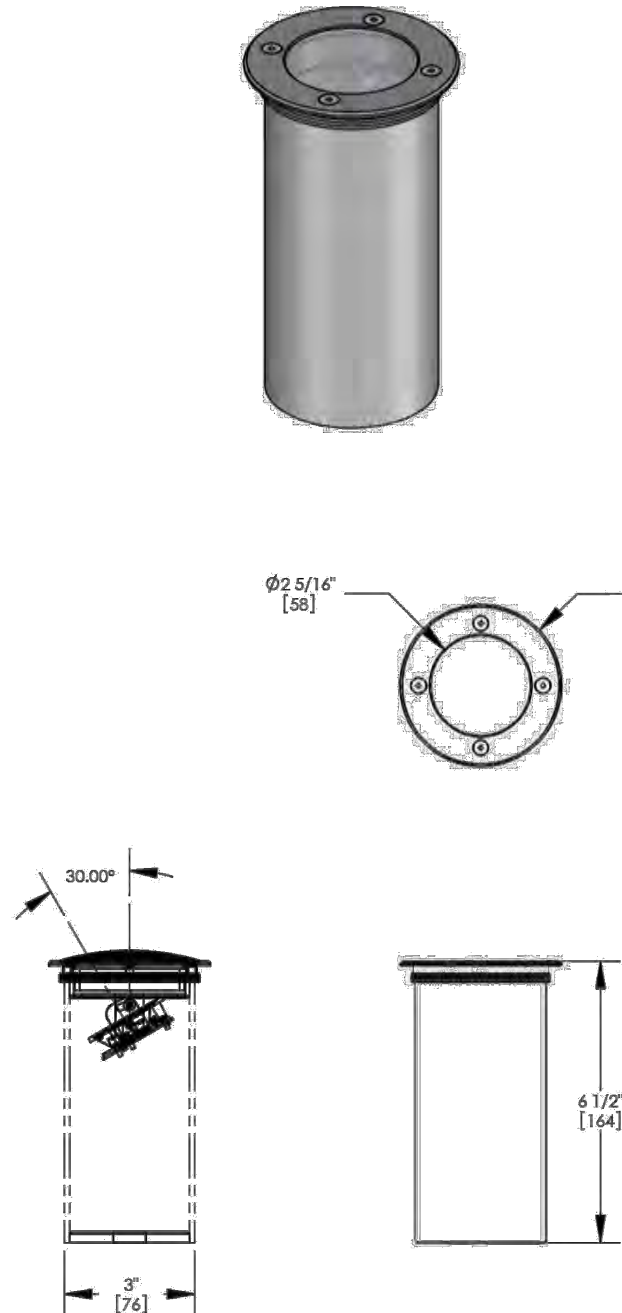

ORDER SPECIFICATION: Fixture Finish Lamping Voltage Options/Access

PROJECT:

APPROVED:

NOTE:

TYPE:

HEVI LITE, INC.
9714 Varlei Ave, Chatsworth, CA 91311
Tel., (818) 341-8091 - Fax (818) 998-1988
Web Site <http://www.hevillite.com>

CATALOG NUMBER:
HL-822-LED


LED Steplight
2.5" Width
Integral 120V Driver

- Fixture**
- Cree XP-E LEDs
 - 2850K ±100K, 80 CRI, 120 lm
 - Integral 120V input driver
 - Diecast aluminum
 - UL /cUL Listed for wet location

- Finishes**
- BZ: Bronze
 - SM: Silver Metallic
 - WT: White

- Mounting**
- Fits in standard single-switch box; also available in a 2" x 3" handy box configuration
 - Step- and wall-mount applications

SS3008 Series
3W 120lm

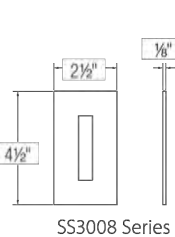

2.5" Width

- 1 - 2.5W Cree XP-E LEDs
700mA, 2850K ±100K, 80 CRI, 120 lm
Integral 120V input driver

☐ SS3008-BZ	Bronze	2 1/2" w x 4 1/2" h x 1 1/2" d
☐ SS3008-SM	Silver Metallic	2 1/2" w x 4 1/2" h x 1 1/2" d
☐ SS3008-WT	White	2 1/2" w x 4 1/2" h x 1 1/2" d

2" x 3" Handy Box Option

Fixtures may be ordered to fit the handy box - add "2x3" to the end of the part number.

☐ SS3008-SM-2x3	Sample part number
--	--------------------

Project _____
Fixture Type _____
Location _____
Contact _____
Phone _____



A Division of Troy CSL Lighting, Inc.
SS3008-X2.0

14508 Nelson Avenue City of Industry, CA 91744 Tel: 626.336.4511 Fax: 626.330.4266 www.cslighting.com
COPYRIGHT © 2013 TROY CSL LIGHTING, INC.

FIXTURE TYPE: 6

ILLUMINATING THE FUTURE. SINCE 1989

Type _____
Project _____
Catalog No. _____
Lamp/Wattage _____

NH0ICD-2
IC Air-Tight LED Housing for 2" IOLITE

PRODUCT DESCRIPTION
New construction housing for use in insulated ceilings can be in direct contact with thermal insulation. Rated for use with Iolite Series fixture

CONSTRUCTION
Housing
0.140" Aluminum shallow housing constructed of Aluminum with integral bar hangers

Air Flow Restriction
Meets requirements of Air tight (AT) <2CFM (cubic feet per minute) in accordance with ASTM-283 Air-Tight requirements.

Bar Hangers
Two 13-3/4" to 24-1/2" adjustable bar hangers with captive nails are included on housing. Bar hangers are parallel to junction box, but can be repositioned 90° perpendicular to junction box if desired. "L" Shaped bar hanger foot to align to bottom of construction joint. A T-Bar notch allows for easy installation in a suspended ceiling.

Junction Box
Prewired SS cubic inch 0.064" thick galvanized steel, with seven 1/2" knockouts, four Romex® pigtails, and snap on covers. All leads are #18AWG wire, the ground wire is connected to the bottom, and quick connectors are supplied on all leads. Through branch circuit wiring, (4-in, 4-out). Access above ceiling required.

ELECTRICAL
Electronic
Thermally protected, single tap input voltage available in 120V 60Hz.
Operating Ambient Temperature: 122°F (50°C) Max.
Power Factor: >0.90
Amps: 300mA - 330mA, 350mA MAX
Voltage: 120 or 277V as specified
Wattage: 13-14W

DIMMING
LED3 - 120V Triac dimmer
LED4 - 120V 0-10V / 277V 0-10V dimmer

Housings (Compatible with NIO-2 Series Trims)
NH0ICD-2BLBZ: 2" Iolite IC Air-Tight LED Dedicated Housing (120V Trac / ELV Dimming)
NH0ICD-2BLBZ: 2" Iolite IC Air-Tight LED Dedicated Housing (120V Trac / ELV or 0-10V / 277V 0-10V Dimming)

Page 1 of 1
NORA NSPEC® 8009 Grayhart St., Commerce, CA 90040 | Phone: 800.988.6672 | FAX: 800.500.9855 www.norahousing.com | e-mail: norahousing@norahousing.com
Specifications subject to change without notice. © 2016

Source: LED

Housing Length: 12"
Housing Width: 7-5/8"
Housing Height: 4"
Out-out: 3-1/4"

Labels and Listings
cULus for Wet Location
Meets or exceeds ASTM-283 Air-Tight Requirements
Washington State and California Approved

All drawings and written material appearing herein constitute the original and unpublished work of Kendle Design Collaborative. Any duplication or reproduction of these documents or any portion herein without the expressed written permission from Kendle Design Collaborative is prohibited by law.

5		
4		
3		
2		
1		

MARK	DATE	DESCRIPTION
------	------	-------------

ISSUE: 12/5/17 - FORMAL REVIEW

PROJECT NO:

CAD DWG FILE:

DRAWN BY: CK, RVH

CHECKED BY: BK

SHEET TITLE:

EXTERIOR
BULIDING
LIGHTING PLAN


A-3.0

FIXTURE TYPE: 4



FIXTURE TYPE: 5

FIXTURE TYPE: 6



FIXTURE TYPE: 7

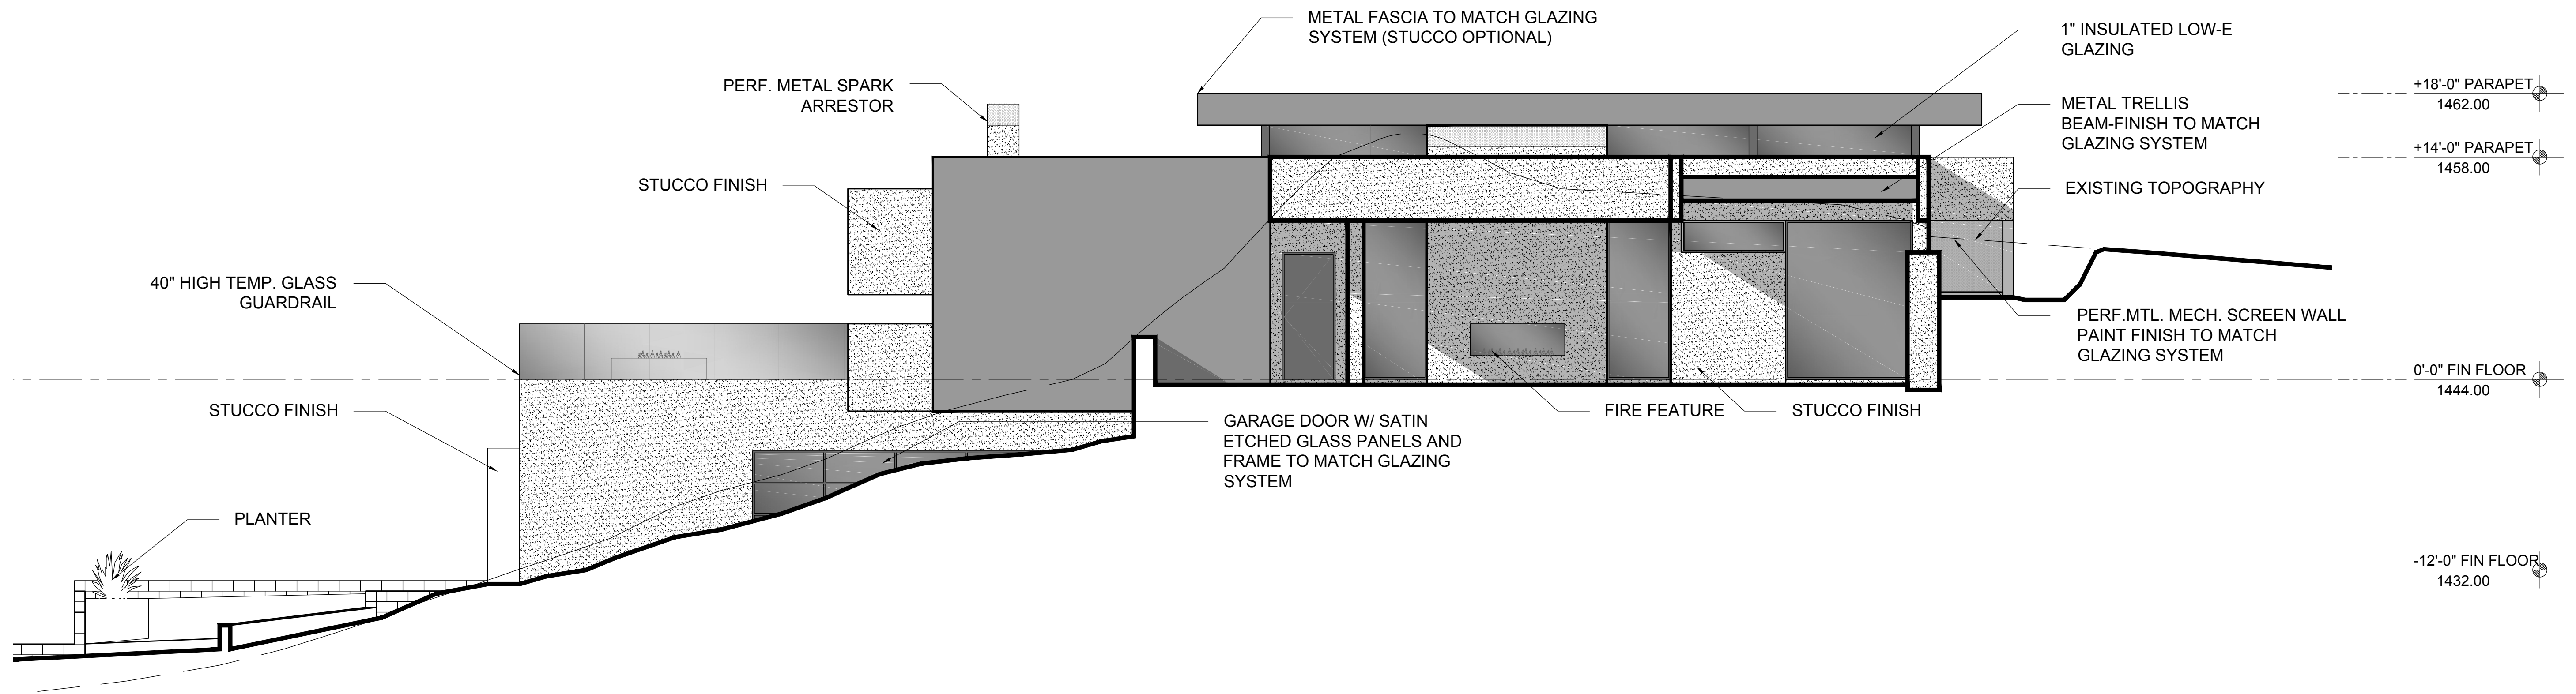

SOUTH ELEVATION

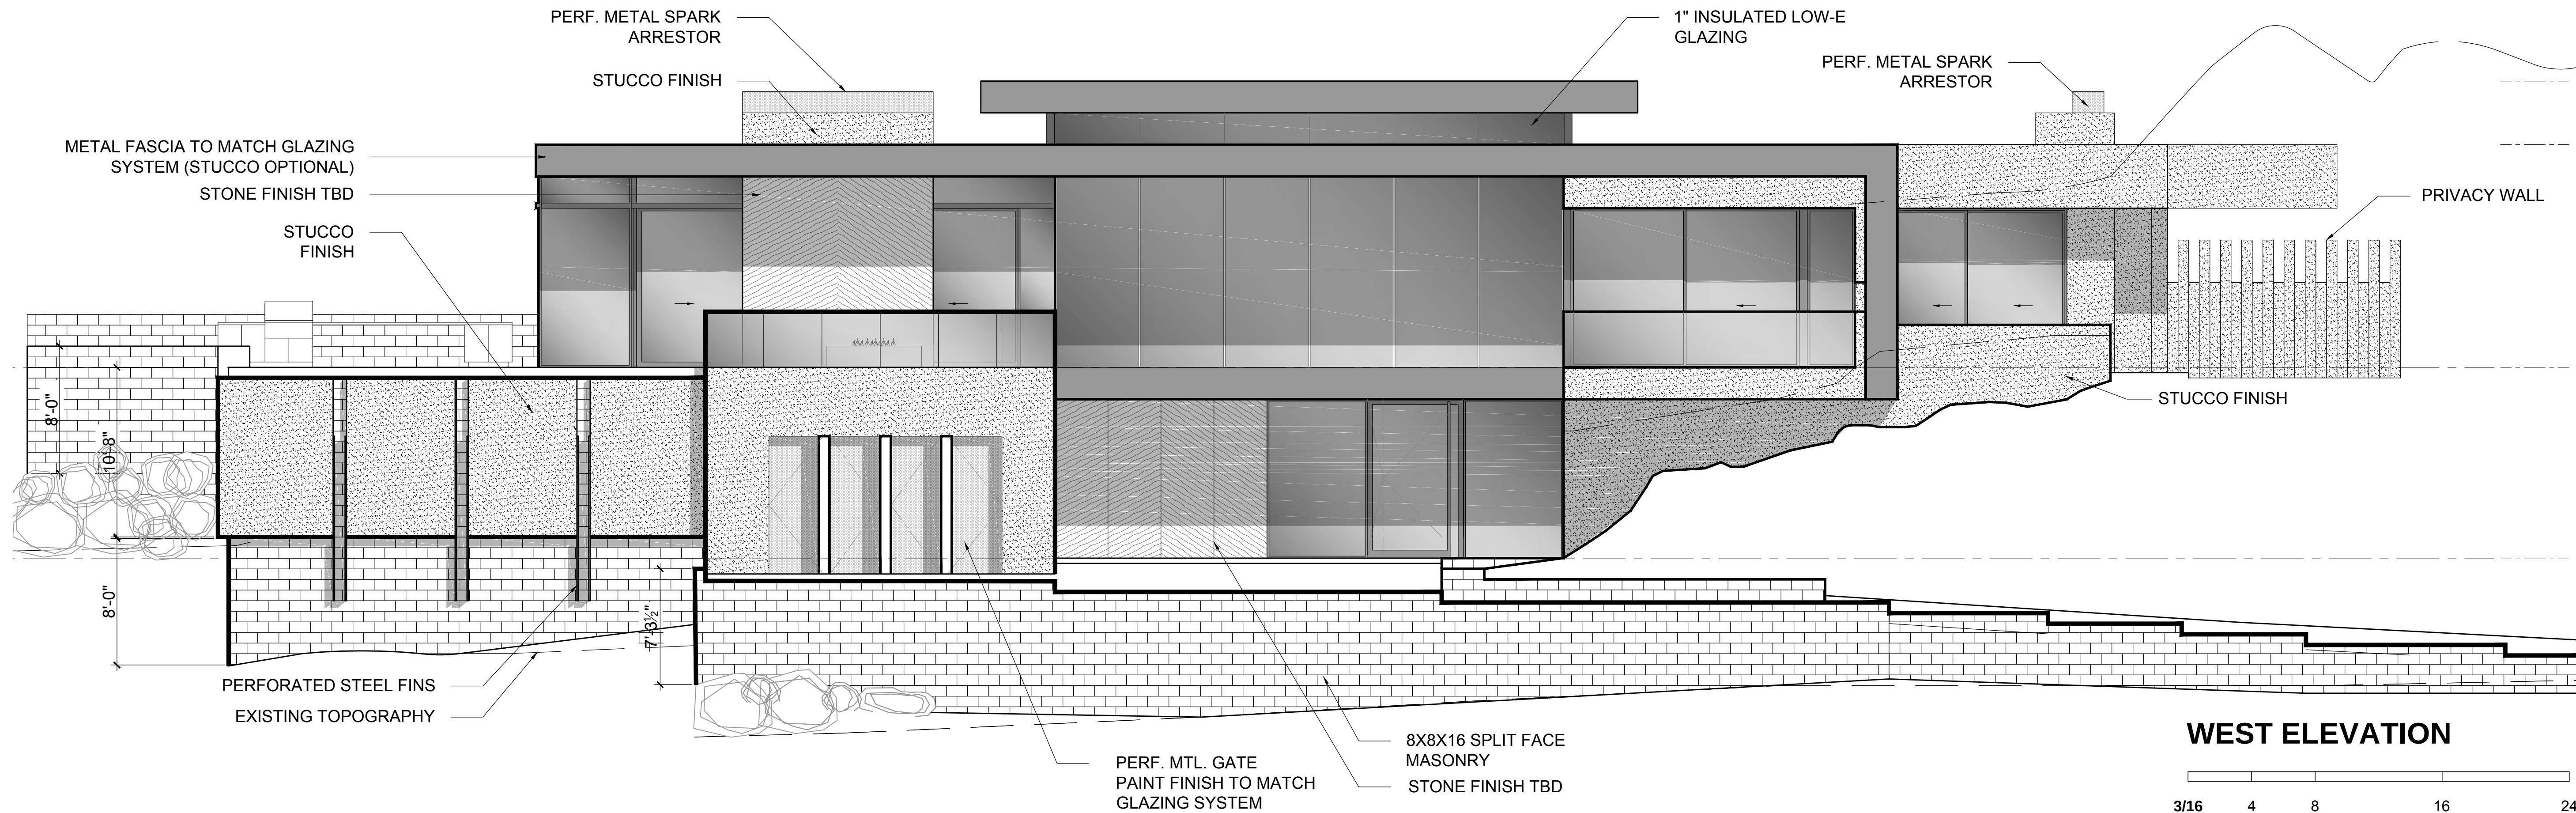 

WEST ELEVATION

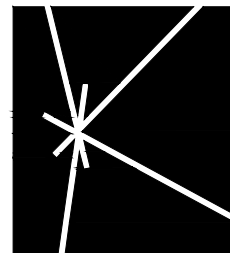 

KENDLE DESIGN
COLLABORATIVE

6115 NORTH CATTLETRACK
SCOTTSDALE, ARIZONA 85250
PH 480.951.8558
BRENT@KENDLEDESIGN.COM
KENDLEDESIGN.COM

Scherr Residence

5416 E. Desert Jewel Drive,
Paradise Valley, AZ
85253

All drawings and written material appearing herein constitute the original and unpublished work of Kendle Design Collaborative. Any duplication or reproduction of these documents or any portion herein without the expressed written permission from Kendle Design Collaborative is prohibited by law.

5		
4		
3		
2		
1		
MARK	DATE	DESCRIPTION

ISSUE: 12/5/17 - FORMAL REVIEW

PROJECT NO:

CAD DWG FILE:




DRAWN BY: CK, RVH

CHECKED BY: BK

SHEET TITLE:

**EXTERIOR
ELEVATIONS**

A-4.0

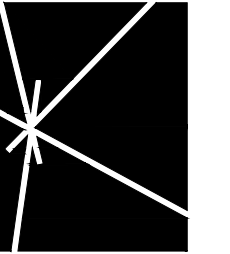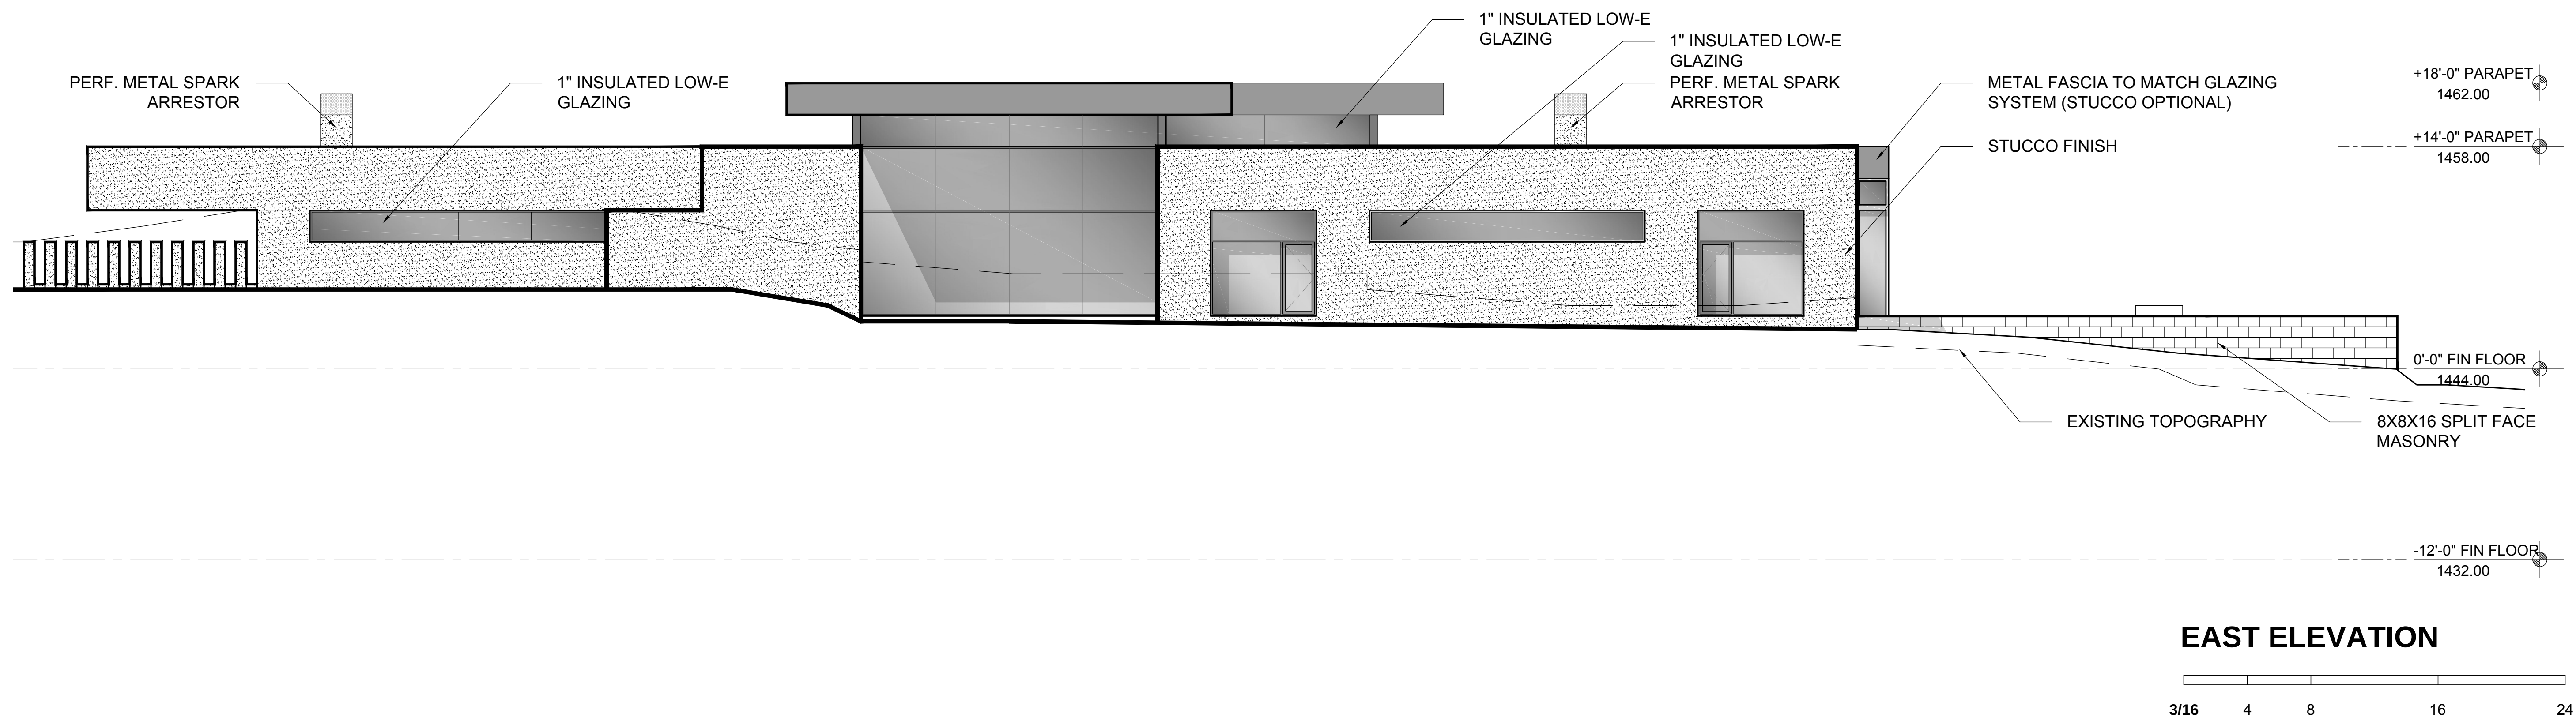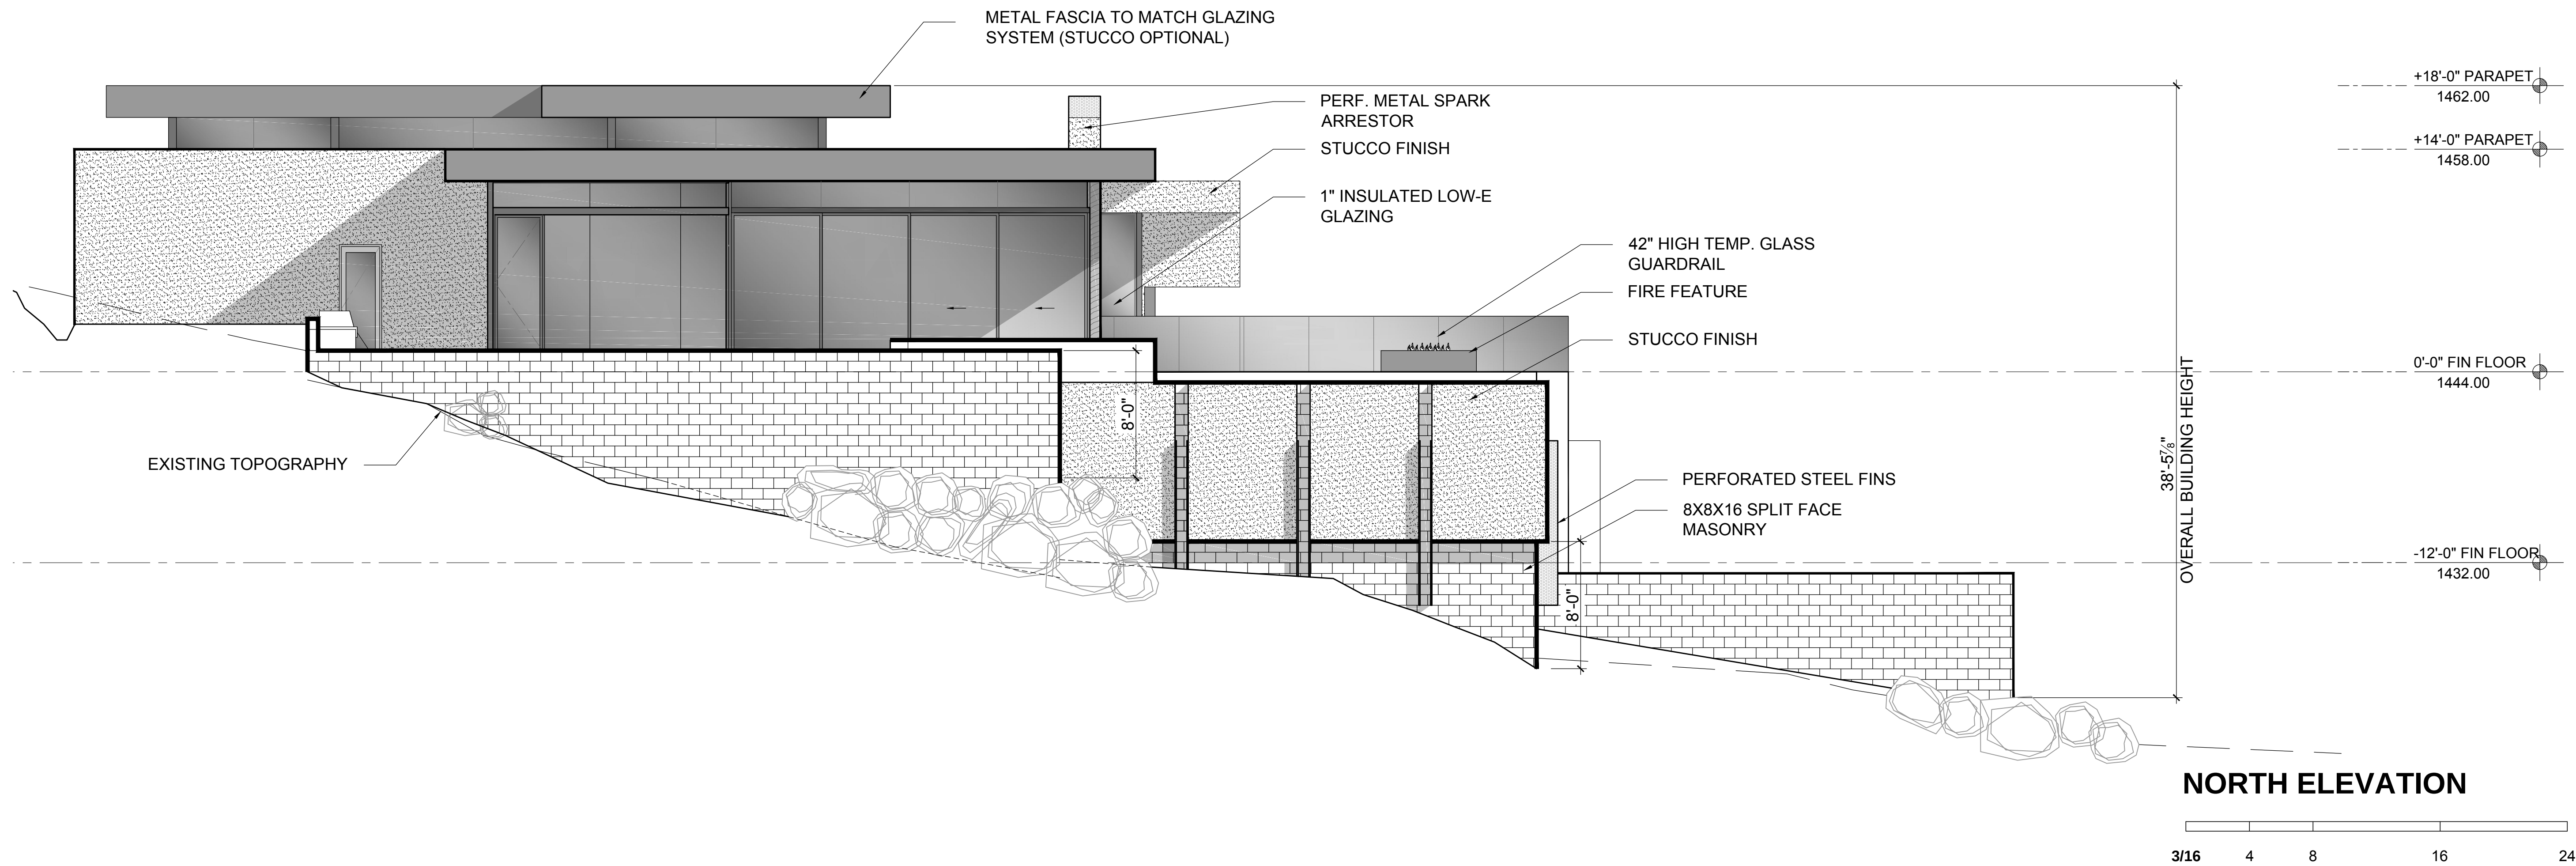

KENDLE DESIGN
COLLABORATIVE

6115 NORTH CATTLETRACK
SCOTTSDALE, ARIZONA 85250
PH 480.951.8558
BRENT@KENDLEDESIGN.COM
KENDLEDESIGN.COM

Scherr Residence

5416 E. Desert Jewel Drive,
Paradise Valley, AZ
85253

All drawings and written material appearing herein constitute the original and unpublished work of Kendle Design Collaborative. Any duplication or reproduction of these documents or any portion herein without the expressed written permission from Kendle Design Collaborative is prohibited by law.

5		
4		
3		
2		
1		
MARK	DATE	DESCRIPTION

ISSUE: 12/5/17 - FORMAL REVIEW

PROJECT NO:

CAD DWG FILE:


DRAWN BY: CK, RVH

CHECKED BY: BK



SHEET TITLE:

EXTERIOR
ELEVATIONS



A-4.1

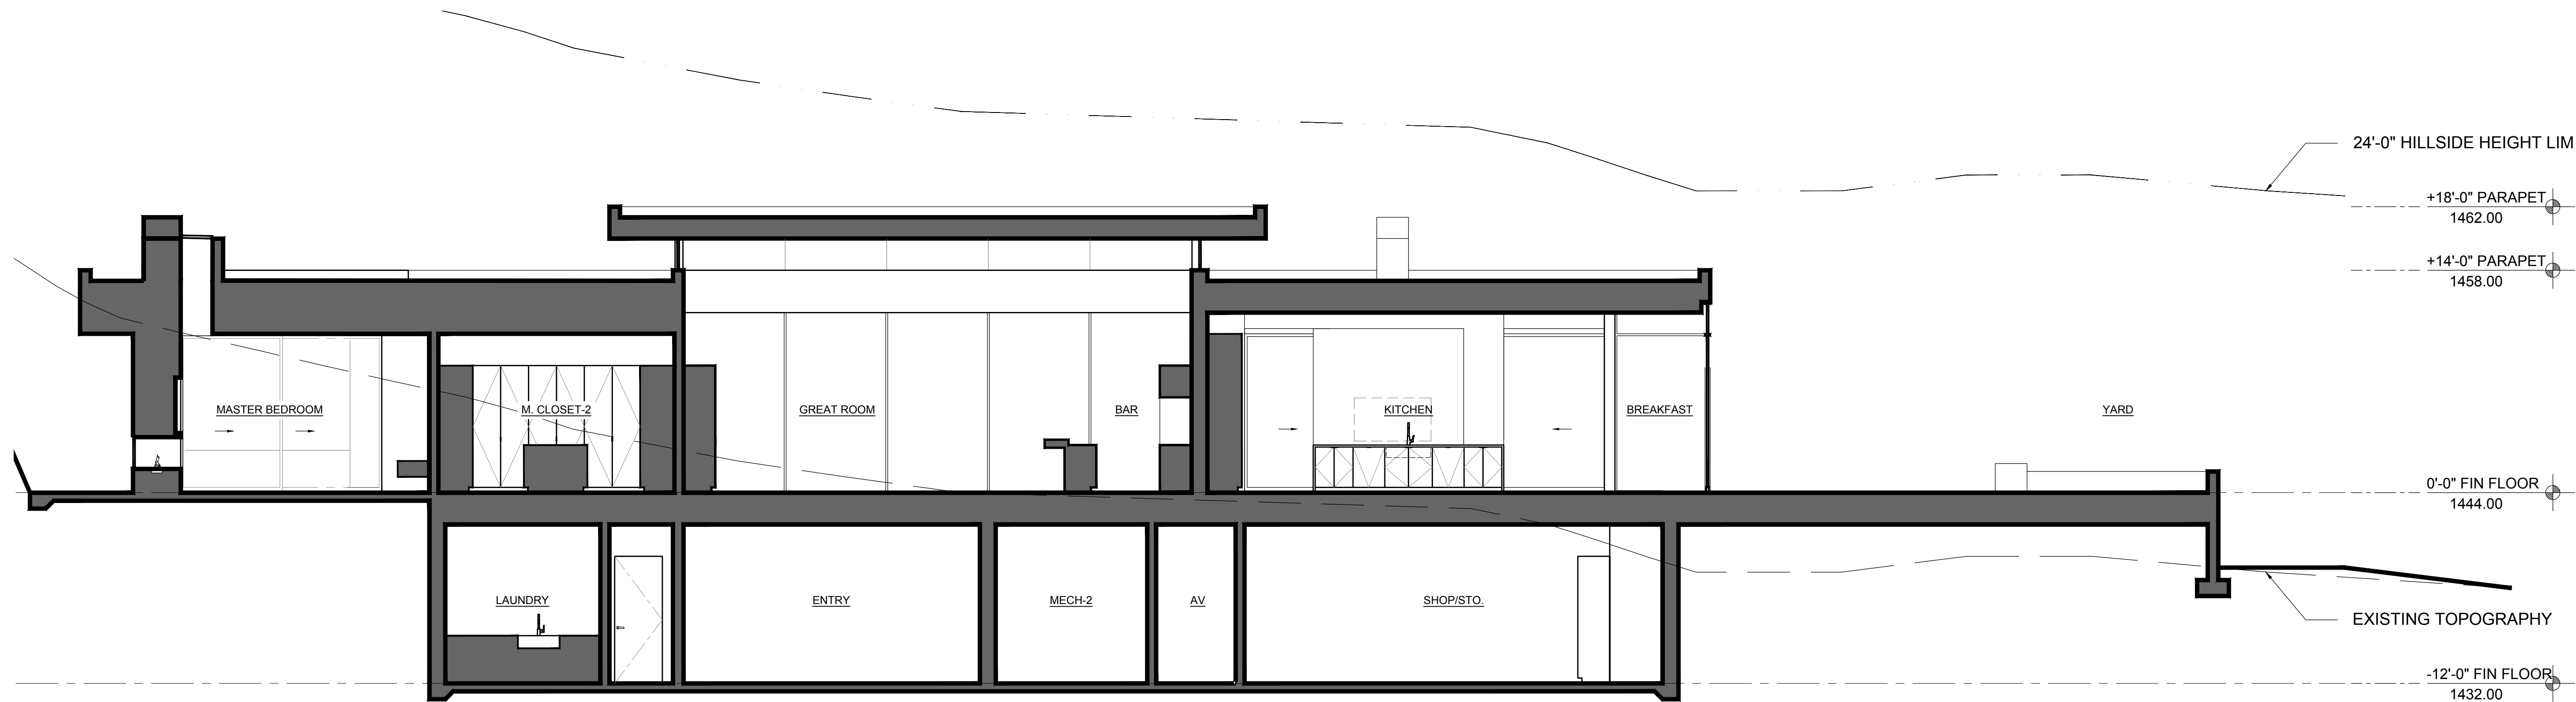

SECTION A

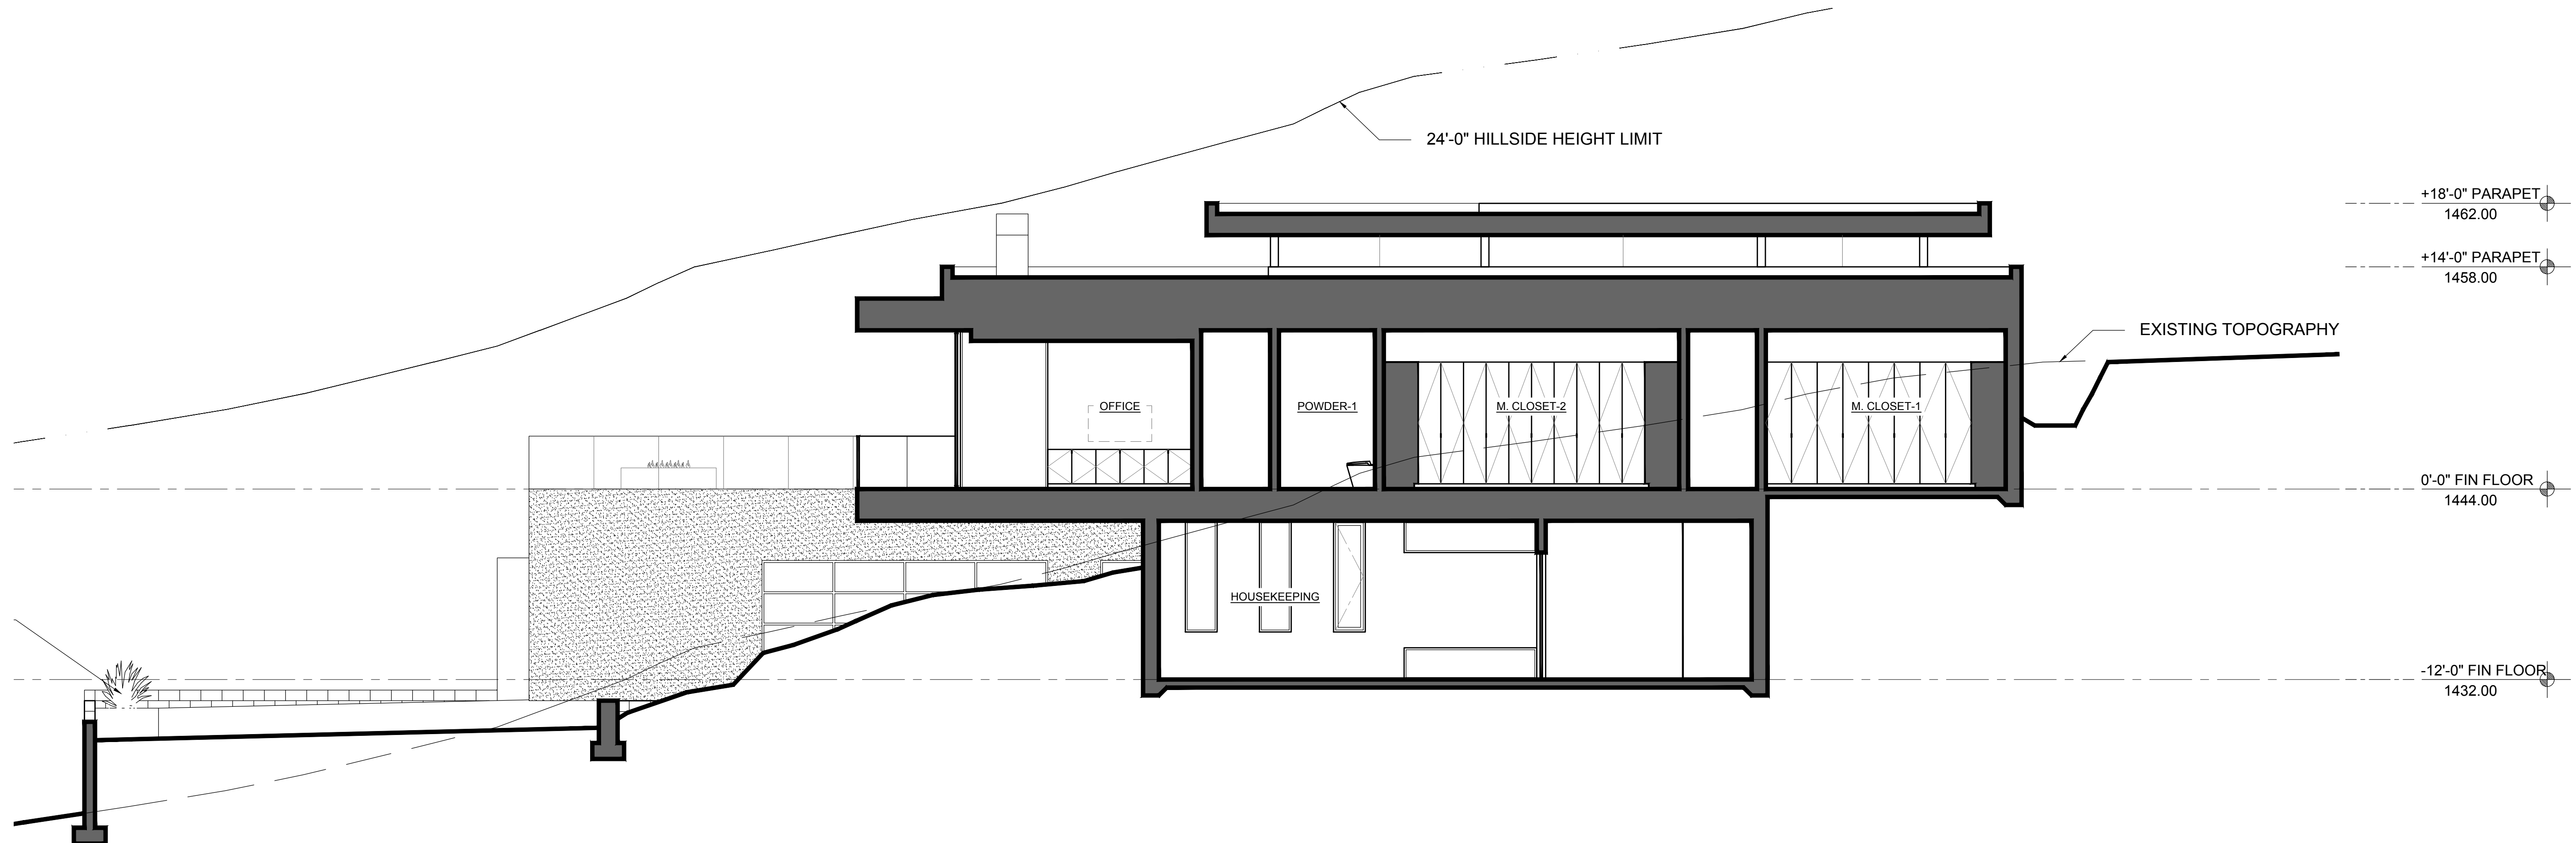 

SECTION B

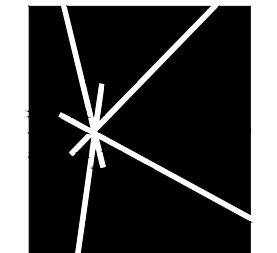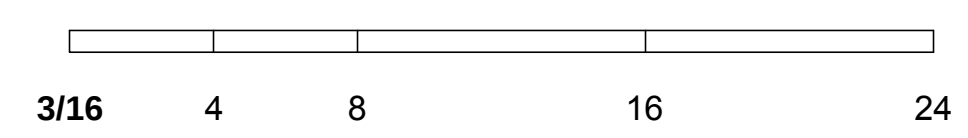

KENDLE DESIGN
COLLABORATIVE
6115 NORTH CATTLETRACK
SCOTTSDALE, ARIZONA 85250
PH 480.951.8558
BRENT@KENDLEDESIGN.COM
KENDLEDESIGN.COM

Scherr
Residence

5416 E. Desert Jewel Drive,
Paradise Valley, AZ
85253

All drawings and written material appearing herein constitute the original and unpublished work of Kendle Design Collaborative. Any duplication or reproduction of these documents or any portion herein without the expressed written permission from Kendle Design Collaborative is prohibited by law.

5		
4		
3		
2		
1		
MARK	DATE	DESCRIPTION

ISSUE: 12/5/17 - FORMAL REVIEW

PROJECT NO:

CAD DWG FILE:


DRAWN BY: CK, RVH

CHECKED BY: BK



SHEET TITLE:

BUILDING
SECTIONS



A-5.0

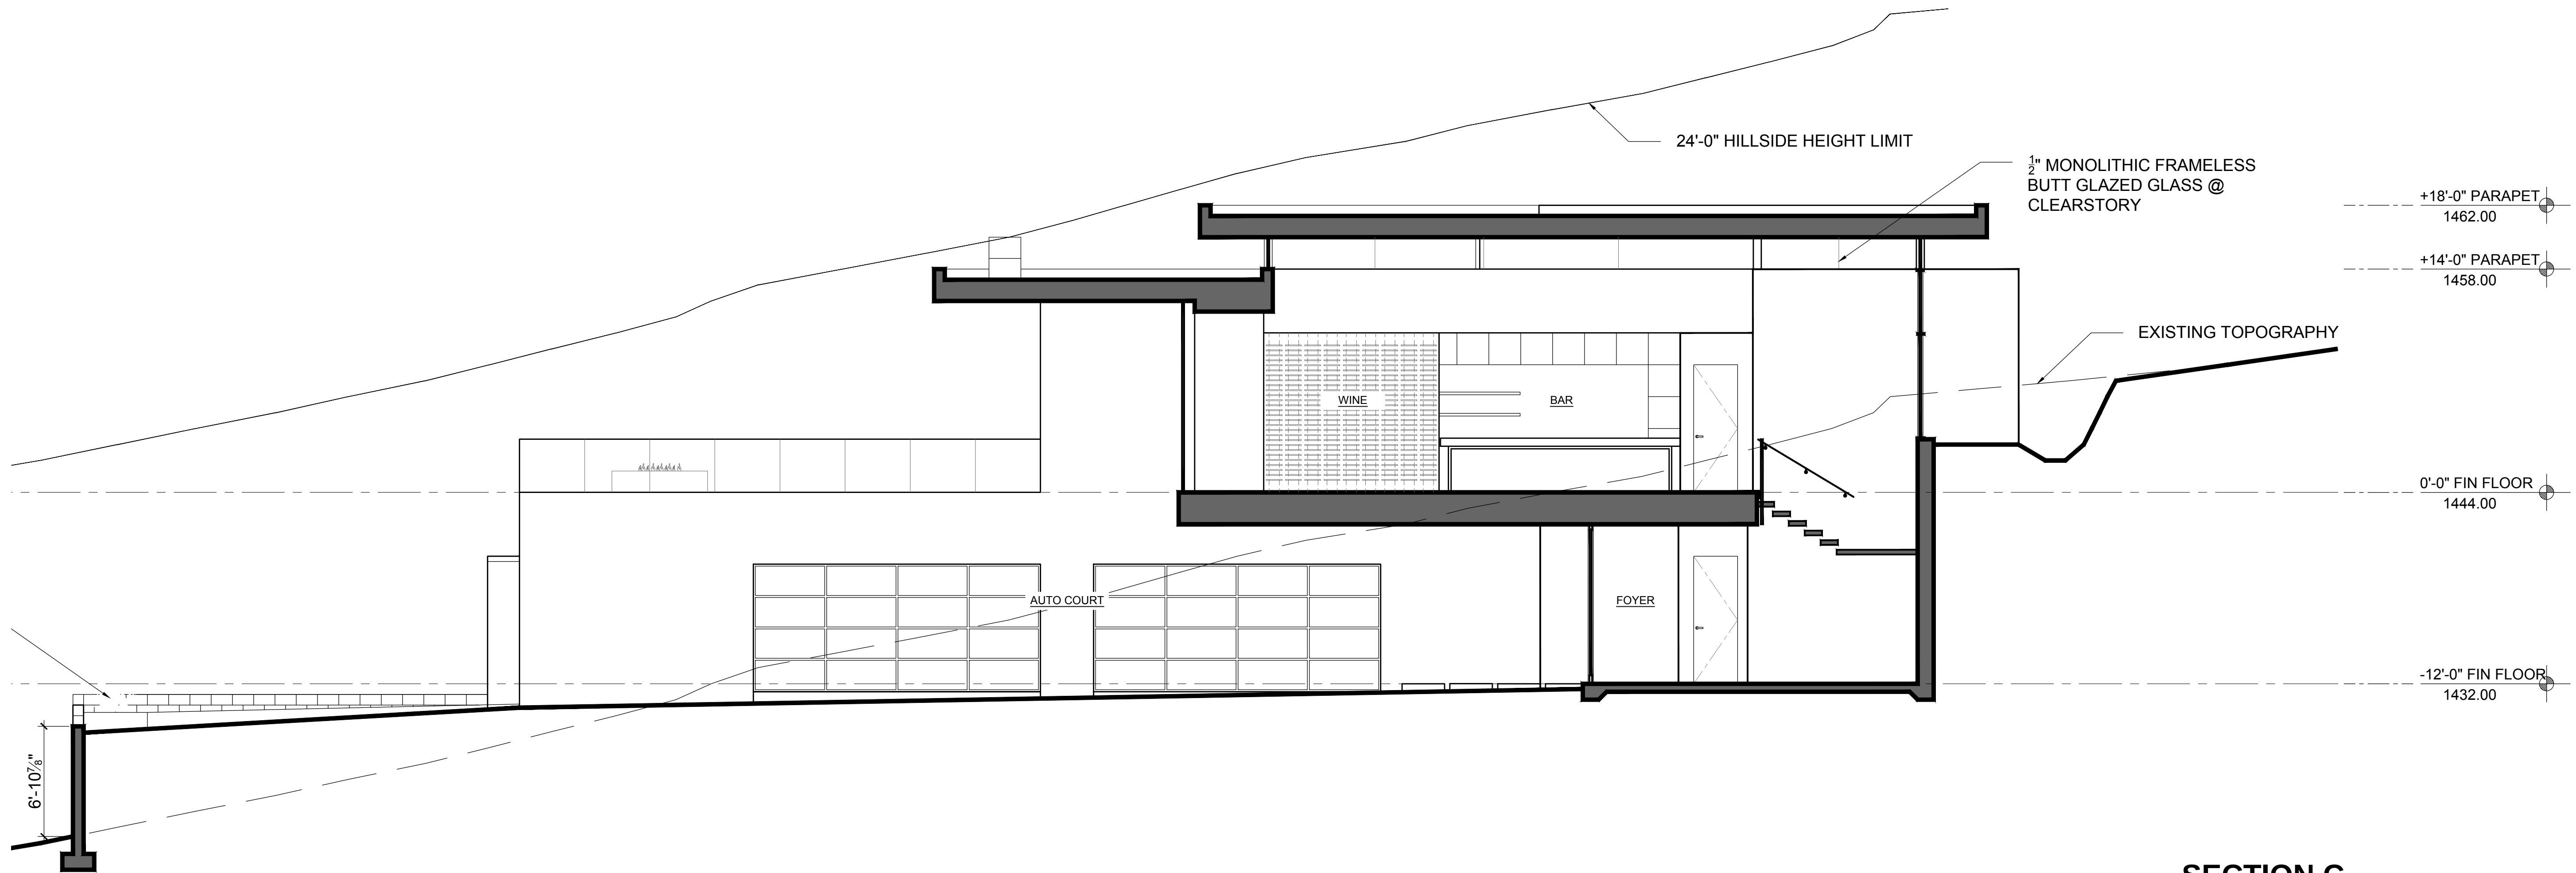

SECTION C

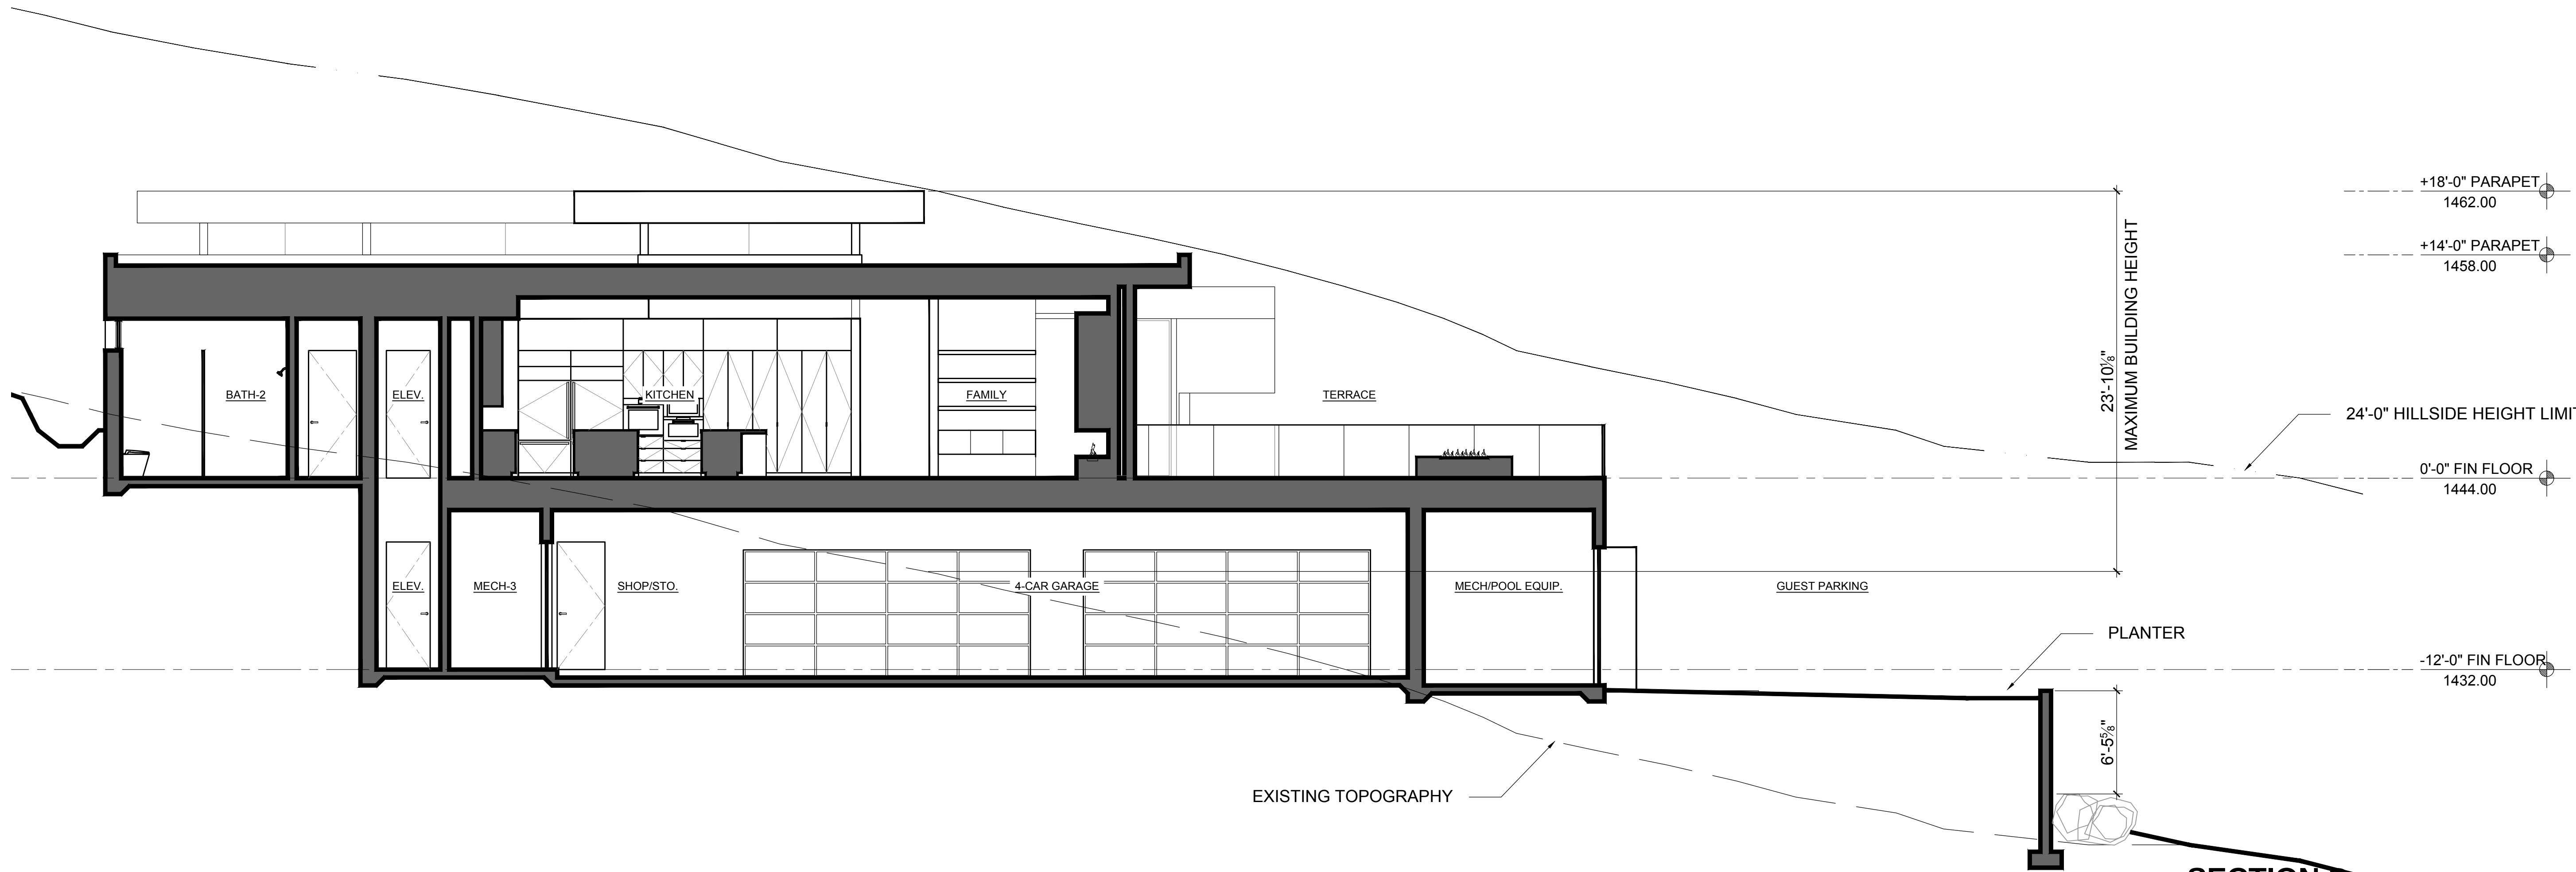 

SECTION D

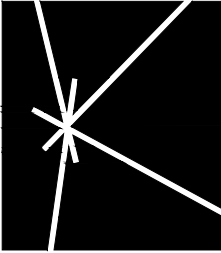 

KENDLE DESIGN
COLLABORATIVE
6115 NORTH CATTLETRACK
SCOTTSDALE, ARIZONA 85250
PH 480.951.8558
BRENT@KENDLEDESIGN.COM
KENDLEDESIGN.COM

Scherr
Residence

5416 E. Desert Jewel Drive,
Paradise Valley, AZ
85253

All drawings and written material appearing herein constitute the original and unpublished work of Kendle Design Collaborative. Any duplication or reproduction of these documents or any portion herein without the expressed written permission from Kendle Design Collaborative is prohibited by law.

5		
4		
3		
2		
1		
MARK	DATE	DESCRIPTION

ISSUE: 12/5/17 - FORMAL REVIEW

PROJECT NO:
CAD DWG FILE:

DRAWN BY: CK, RVH
CHECKED BY: BK

SHEET TITLE:

BUILDING
SECTIONS

A-5.1



VIEW 1



VIEW 2



VIEW 3



VIEW 4



VIEW 5




VIEW 6



VIEW 7





VIEW 8

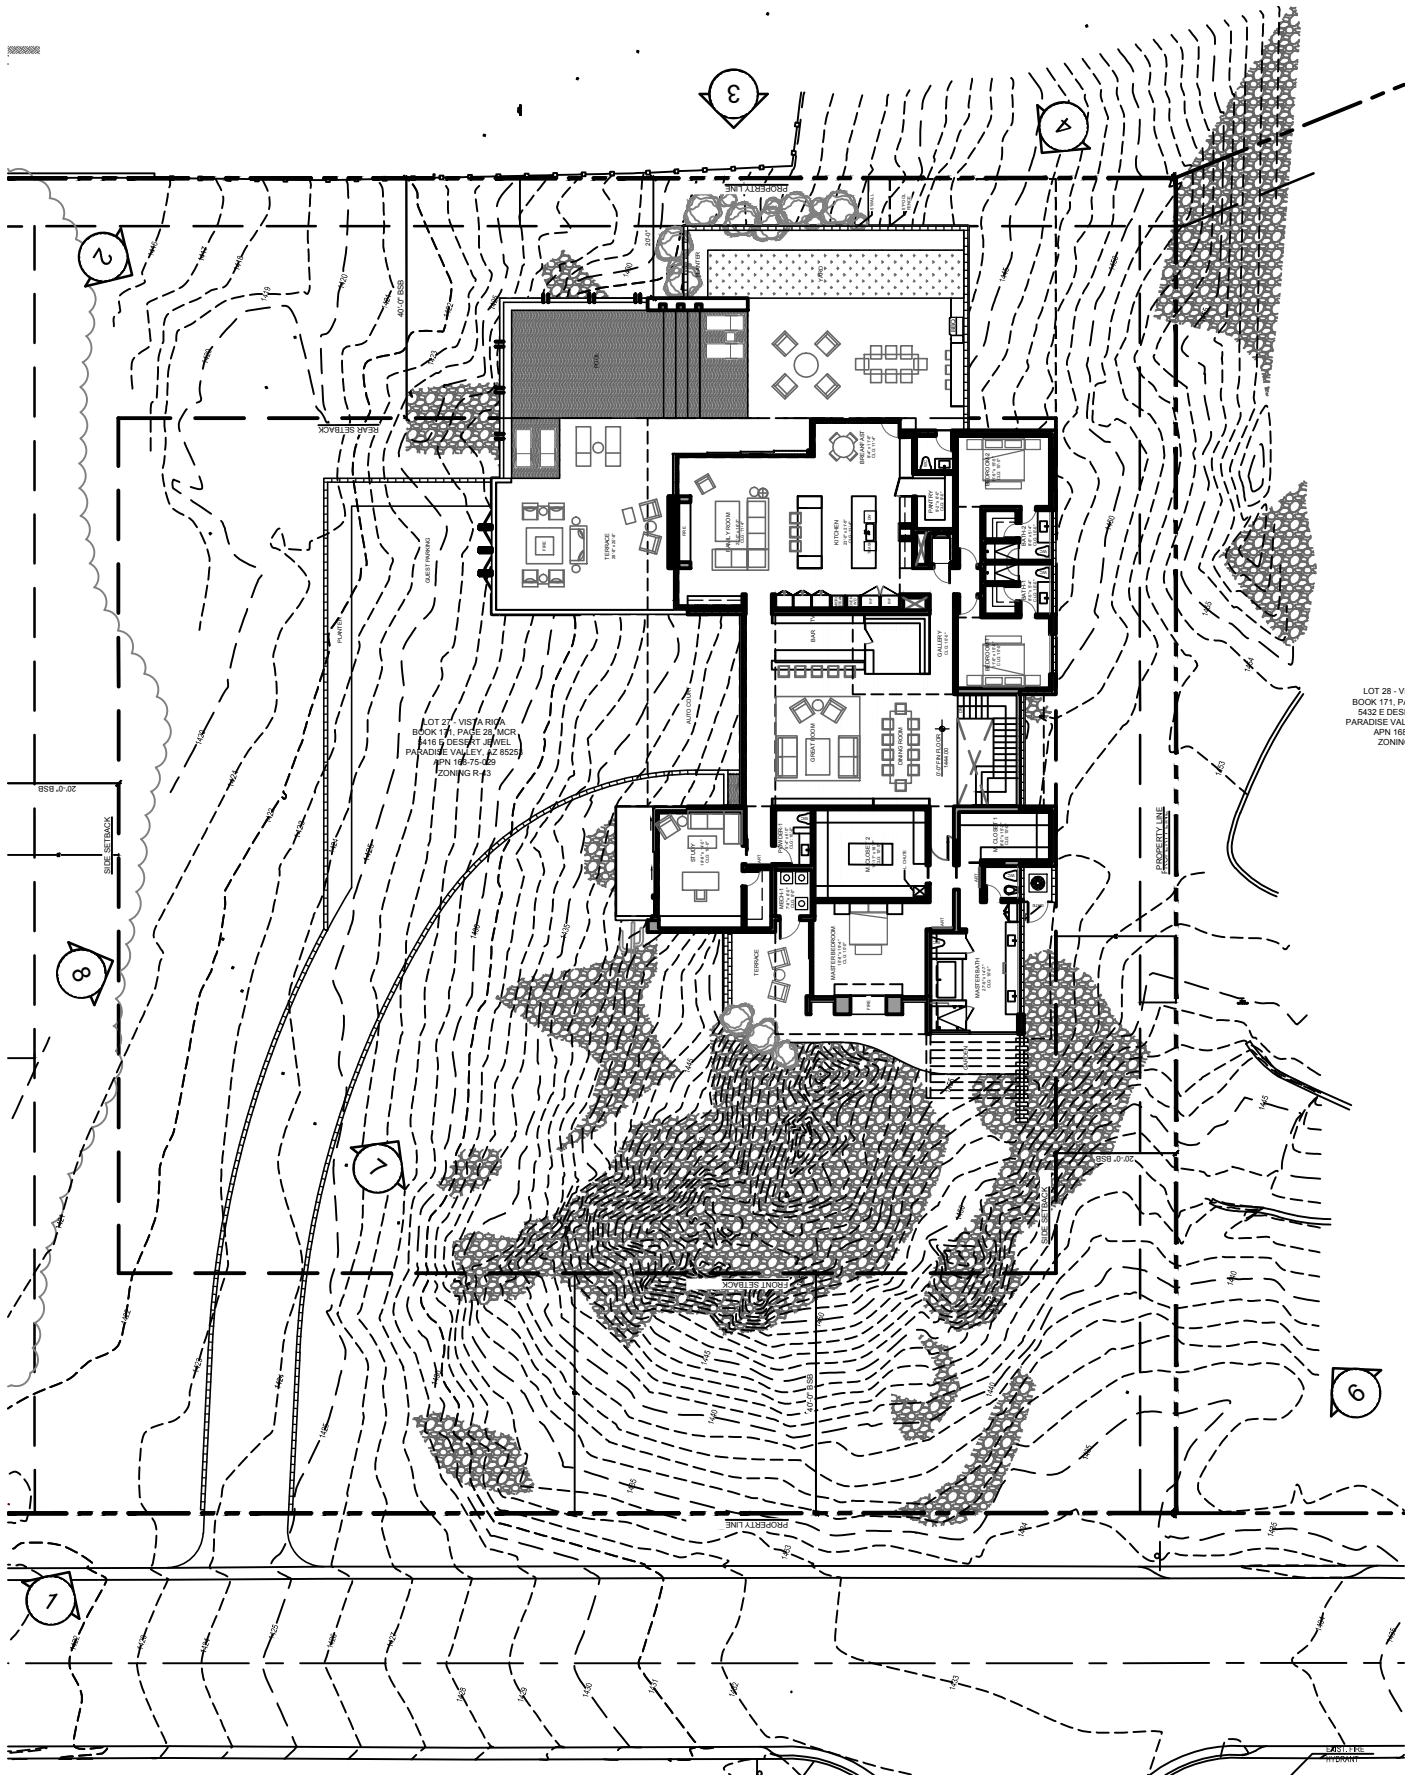

KEY PLAN

1"=32' 32' 64' 128' 192'

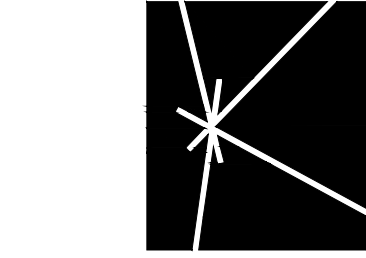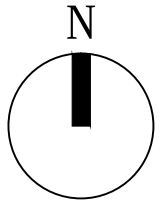

KENDLE DESIGN
COLLABORATIVE

6115 NORTH CATTLETRACK
SCOTTSDALE, ARIZONA 85250
PH 480.951.8558
BRENT@KENDLEDESIGN.COM
KENDLEDESIGN.COM

Scherr
Residence

5416 E. Desert Jewel Drive,
Paradise Valley, AZ
85253

All drawings and written material appearing herein constitute the original and unpublished work of Kendle Design Collaborative. Any duplication or reproduction of these documents or any portion herein without the expressed written permission from Kendle Design Collaborative is prohibited by law.

5		
4		
3		
2		
1		
MARK	DATE	DESCRIPTION

ISSUE: 12/5/17 - FORMAL REVIEW

PROJECT NO:
CAD DWG FILE:

DRAWN BY: CK, RVH
CHECKED BY: BK

SHEET TITLE:

MASSING
MODEL

A-6.0



HARDSCAPE
TO MATCH INTERIOR: TBD

GUARDRAIL
42" HIGH TEMP. GLASS, CLEAR



METAL 1
TO MATCH WINDOW SYSTEM FINISH
LRV: 2.5



FLAT ROOF
DURO-LAST SINGLE PLY ROOF
MEMBRANE. COLOR: DARK GREY
LRV: 25



PERMEABLE PAVERS
ACKER-STONE PALOMINO GRIND
GROUND FACE
LRV: 24



SPLIT FACE CMU
Superlite Block, Integrally colored CMU
Color: Monterey Stone
LRV: 16.14



STUCCO
SMOOTH SAND FINISH. MATCH BENJAMIN
MOORE HC-166 KENDALL CHARCOAL
LRV: 12.6



STUCCO
SMOOTH SAND FINISH. MATCH BENJAMIN
MOORE AF-675 FUSION
LRV 36.3



GARAGE DOORS
TRANSLUCENT PANELS W/ FRAME
TO MATCH METAL 2




STONE
TBD:
LRV: TO NOT BE IN GREATER THEN
38%



METAL 2
TO MATCH WINDOW SYSTEM FINISH
LRV: 2.5



GLAZING
CLEAR, LOW-E INSULATED GLAZING
IN DARK BRONZE ANODIZED FRAME

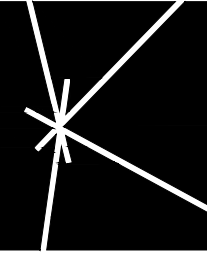

KENDLE DESIGN
COLLABORATIVE

6115 NORTH CATTLETRACK
SCOTTSDALE, ARIZONA 85250
PH 480.951.8558
BRENT@KENDLEDESIGN.COM
KENDLEDESIGN.COM

Scherr Residence

5416 E. Desert Jewel Drive,
Paradise Valley, AZ
85253

All drawings and written material appearing herein constitute the original and unpublished work of Kendle Design Collaborative. Any duplication or reproduction of these documents or any portion herein without the expressed written permission from Kendle Design Collaborative is prohibited by law.

5		
4		
3		
2		
1		
MARK	DATE	DESCRIPTION

ISSUE: 12/5/17 - FORMAL REVIEW

PROJECT NO:

CAD DWG FILE:

DRAWN BY: CK, RV/H

CHECKED BY: BK

SHEET TITLE:

EXTERIOR
MATERIALS

A-7.0